


LEGEND

PRIMARY SEWERLINE

PROPOSED SEWERLINE

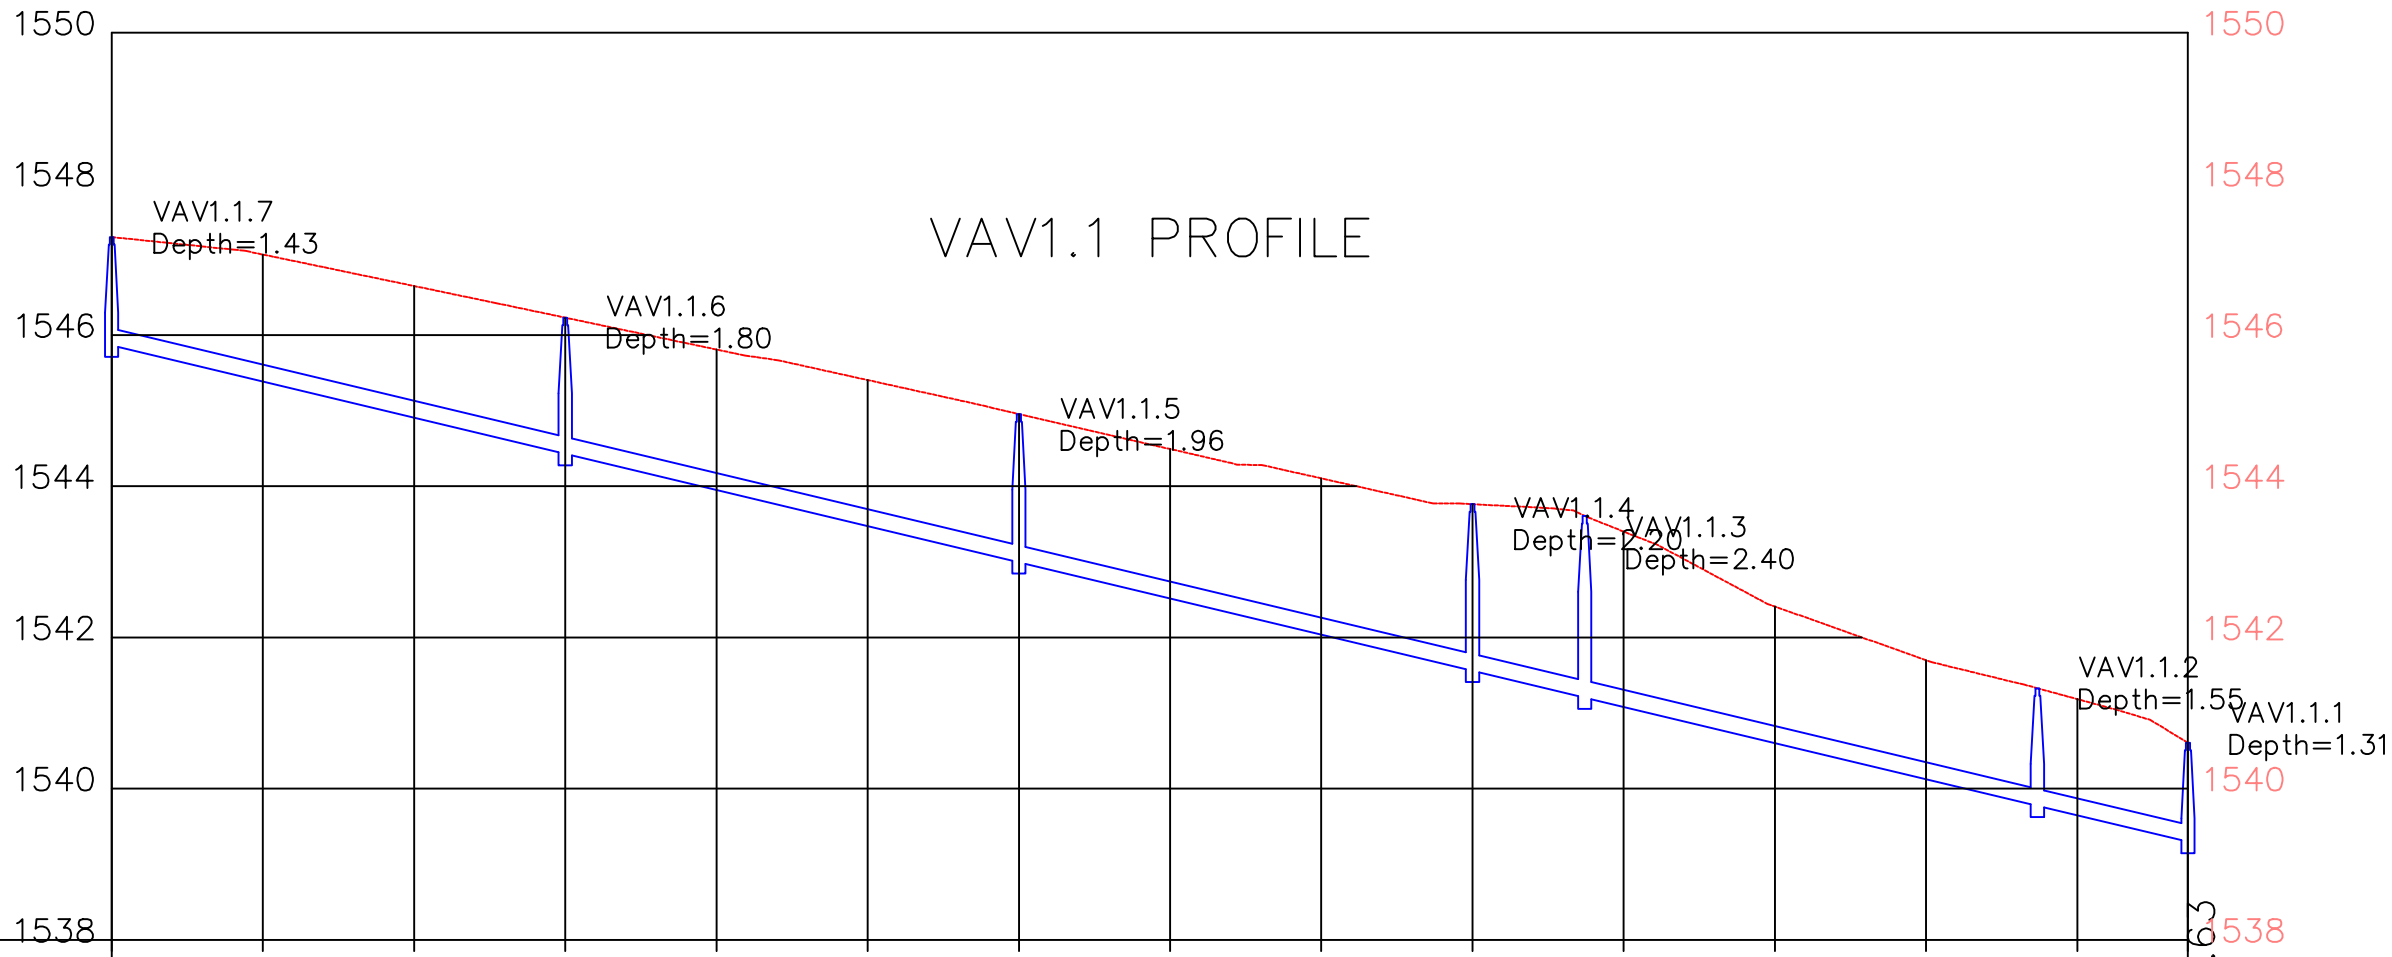

Stations	0+000	0+020	0+040	0+060	0+080	0+100	0+120	0+140	0+160	0+180	0+200	0+220	0+240	0+260	0+274.63
Manhole No.	VAV1.1.6 0+000.00			VAV1.1.5 0+060.00			VAV1.1.4 0+120.00			VAV1.1.3 0+180.00	VAV1.1.2 0+194.85			VAV1.1.1 0+254.72	VAV1.1.2 0+274.63
Ground Level	1547.30	-1547.06	-1546.65	1546.23	-1545.81	-1545.40	1544.95	-1544.49	-1544.10	1543.76	-1543.40	-1542.41	-1541.70	-1541.18	-1540.61
Invert Elevations	1545.86			1544.43			1542.99	1542.99		1541.56	1541.20		1539.77	1539.77	1539.30
Pipe Data	S=2.4% L=60.0m		S=2.4% L=60.0m		S=2.4% L=60.0m		S=2.4% L=60.0m		S=2.4% L=59.9m		S=2.4% L=59.9m		S=2.4% L=19.9m		
Dia. & Material	300mm Concrete Pipe														

Reference Drawings					DESIGN CONSULTANT SINCE 1984 Runji & Partners Consulting Engineers and Planners Ltd 3, Kindaruma road ,Off Ngong Road Telephone (020) 2717213/4 Telefax (020) 2717215 P.O. Box 68053-00200, Nairobi. Intercontinental Consultants and Technocrats Pvt. Ltd A-8, Green Park, New Delhi - 110 016, INDIA					Drawn		Date : JUNE. 2017		Designed		Date		NAIROBI CITY WATER & SEWERAGE COMPANY (NCW&C) Kampala Road, P.O Box 30656 - 00100, NAIROBI -KENYA.						ENGINEERING SERVICES FOR DESIGN AND DOCUMENTATION OF PRIMARY AND SECONDARY SEWERLINES-LOT 4							
										Name : M.N.M				Name : D.M.O										Drawing Title							
										Checked		Date		Approved		Date		PLAN AND PROFILE - VALLEY VIEW LINE VAV 1.1													
										Name : N.M				Name : R.N																	
B																		Date		CONTRACT NO.				Date		Scales		Hor. 1:1000 (A1)		Drg No.	
A																										Vert. 1:100 (A1)					
REV		REVISIONS					Checked		Date		Appr. WD				DEPARTMENT HEAD		Rev		Managing Director						WS 621-L4-VAV-002						