



THE GOVERNMENT OF KENYA
MINISTRY OF WATER, SANITATION AND IRRIGATION
AFRICAN DEVELOPMENT BANK
ATHI WATER WORKS DEVELOPMENT AGENCY



CONSULTANCY SERVICES FOR DETAILED DESIGN AND CONSTRUCTION SUPERVISION FOR REHABILITATION AND EXPANSION OF DANDORA ESTATE SEWAGE TREATMENT PLANT (DESTP) INLET WORKS – COMPONENT 1: DESIGN AND TENDER DOCUMENTATION

DETAILED DESIGN DRAWINGS

MARCH 2022



FRAME Consultants Ltd

3rd Floor, Pension Towers – Loita Street
P. O. Box 58624 – 00200
Nairobi, Kenya
info@frameconsultants.com
www.frameconsultants.com



Ditech Engineering Services


5th Floor, Nextgen Building
P.O. Box 231 - 00507
Nairobi, Kenya
design@ditech.co.ke
www.ditechengineering.co.ke




CIVIL WORKS

[illegible][illegible]


GENERAL LAYOUT PLAN

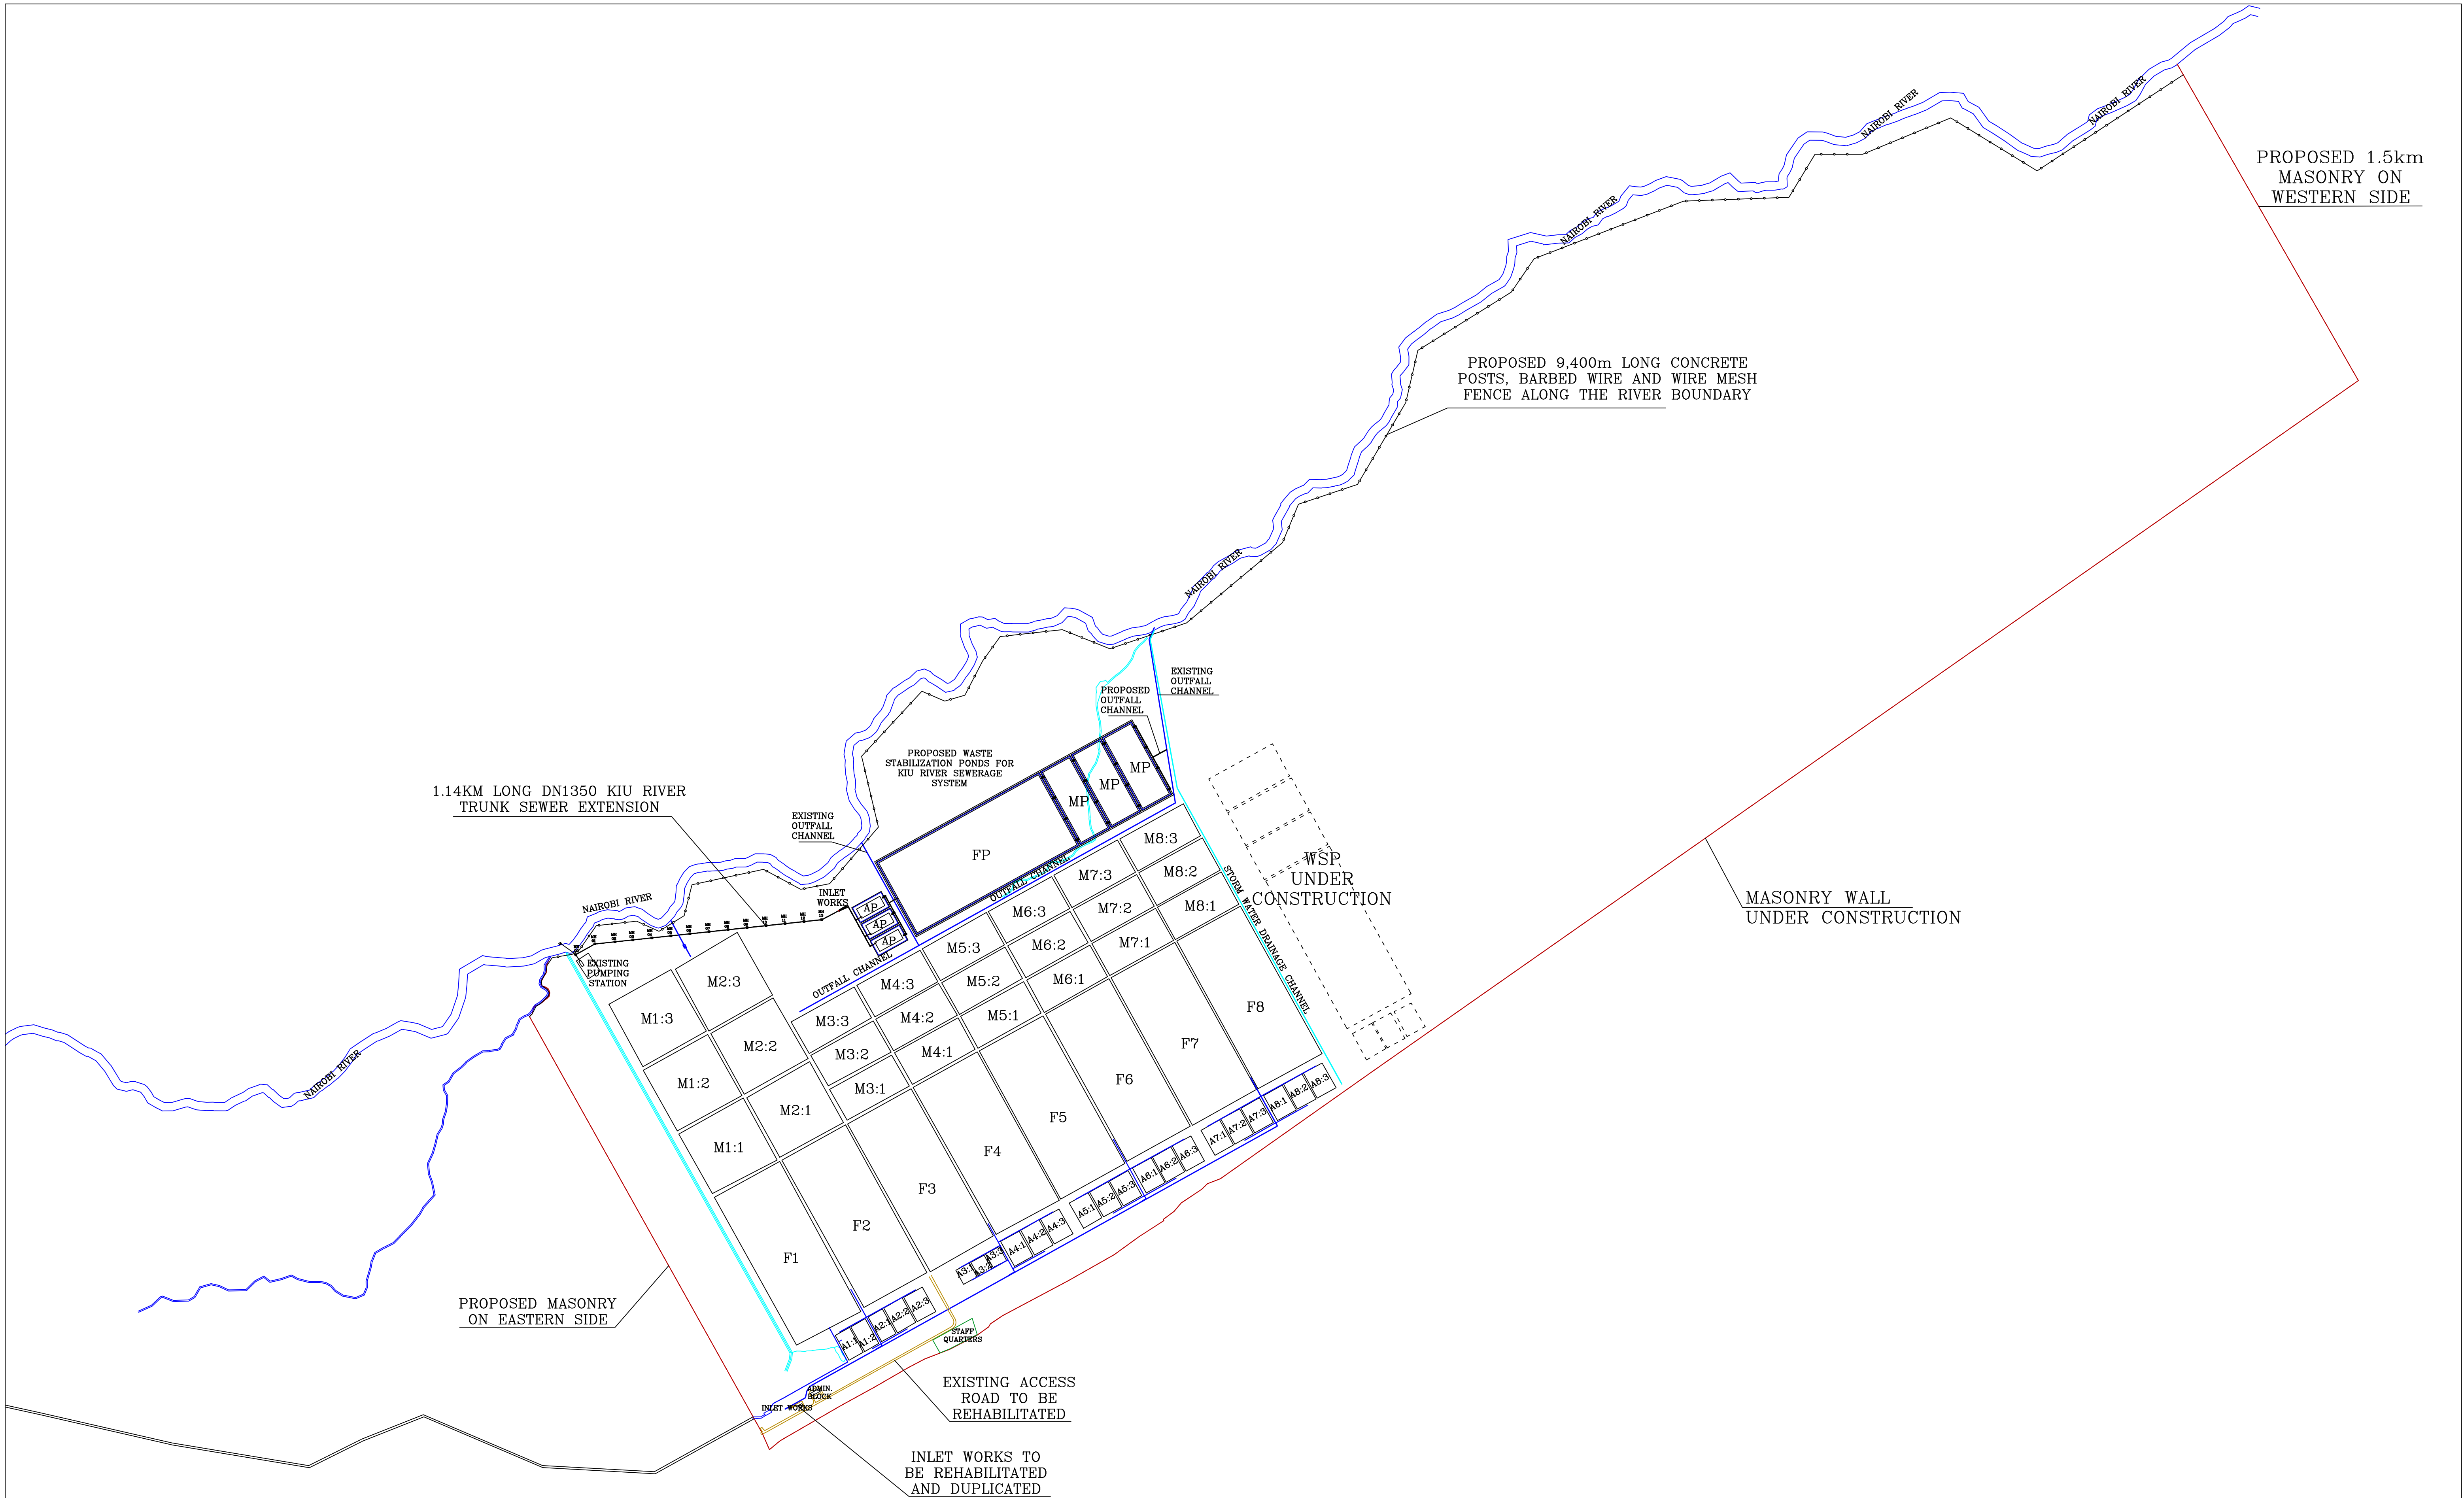


DUPLICATION OF DESTP INLET WORKS

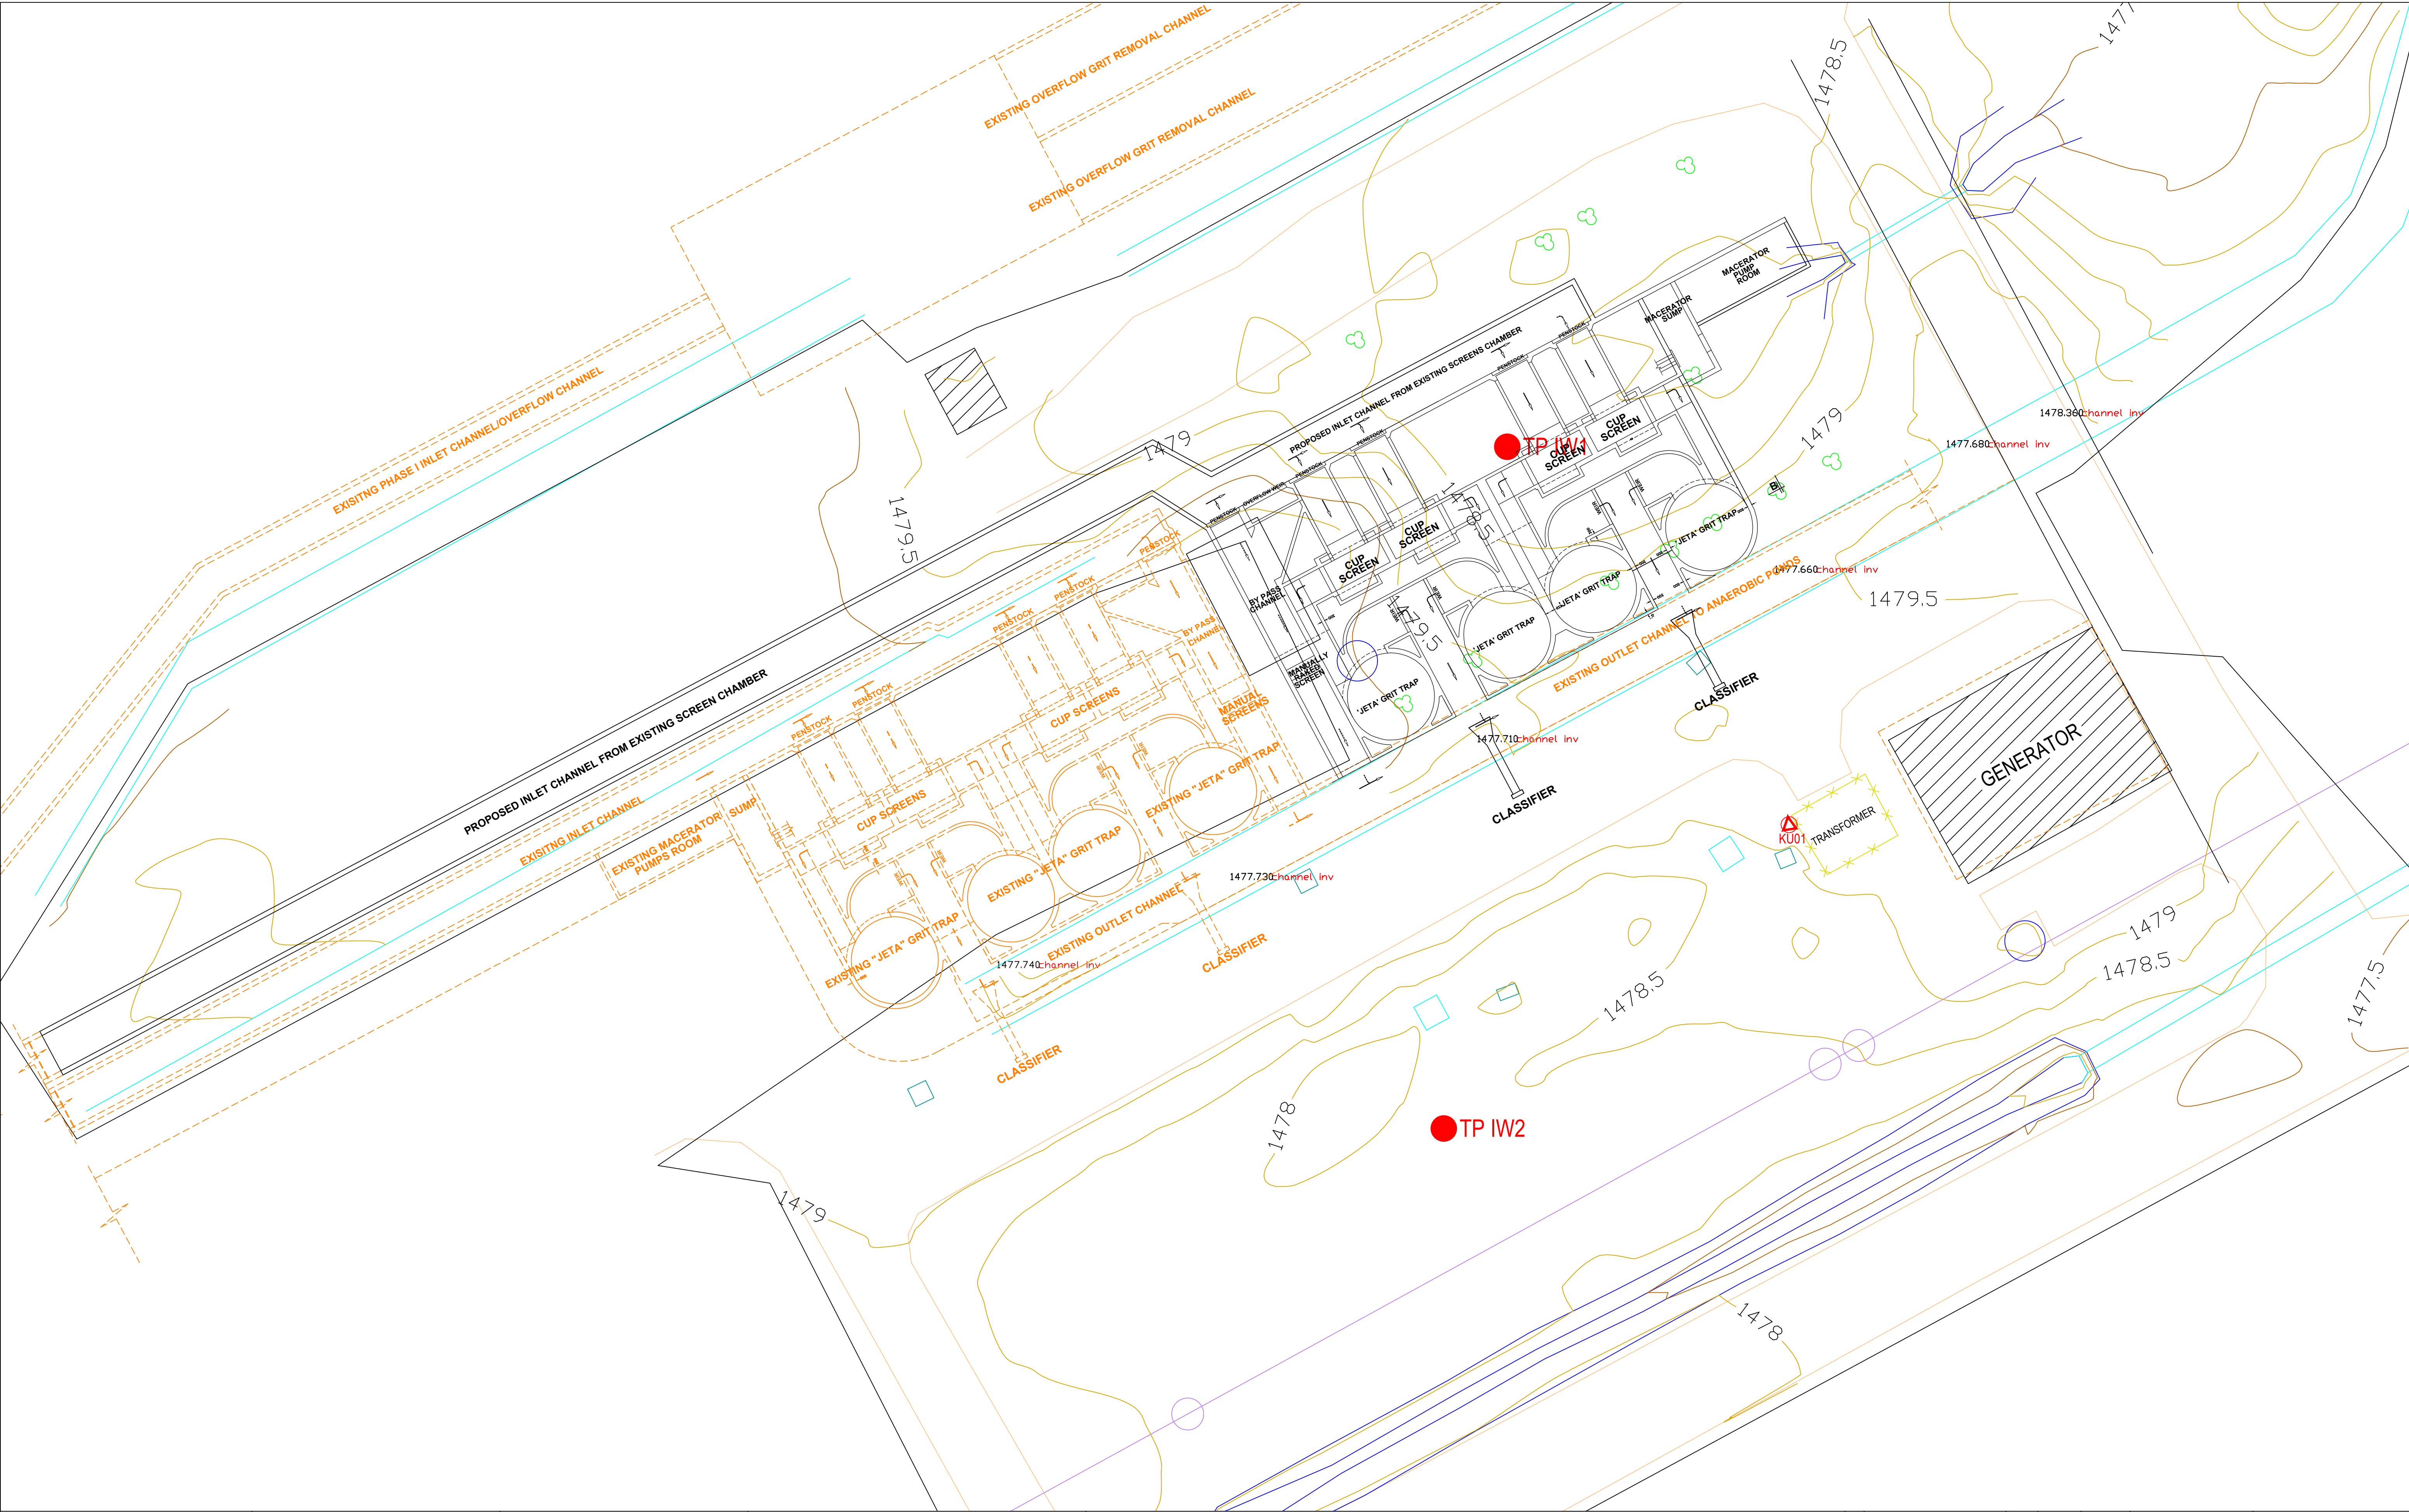


Civil Engineer:  Frame Consultants Ltd P.O. BOX 58624-00200, NAIROBI. TEL: 2213744, 2251505, 0720523850 E-mail:info@frameconsultants.com		Client:  ATHI WATER WORK DEVELOPMENT AGENCY P.O BOX 45283 - 00100 NAIROBI, Tel: +254 (0) 274292/3 Email: info@awwa.go.ke		Project NAIROBI RIVERS BASIN REHABILITATION AND RESTORATION PROGRAMME: SEWERAGE IMPROVEMENT PROJECT PHASE II (NaRSIP II) REHABILITATION AND EXPANSION OF DANDORA ESTATE SEWERAGE TREATMENT PLANT (DESTP) INLET WORKS		Drawing Title DANDORA ESTATE SEWAGE TREATMENT PLANT (DESTP) LAYOUT PLAN OF EXISTING AND PROPOSED WORKS		NOTES 1. DRAWING TO SCALE ON A1 PAPER SIZE 2. DRAWING TO BE READ INCONJUNCTION WITH OTHER RELEVANT CIVIL, STRUCTURAL, ELECTRICAL AND MECHANICAL DRAWINGS 3. ALL DIMENSIONS AND LEVELS TO CHECKED ON SITE BEFORE COMMENCING ANY WORK. ANY DISCREPANCY TO BE REPORTED TO THE ENGINEER 4. ONLY FIGURED DIMENSIONS TO BE TAKEN FROM THIS DRAWING		<table><tr><th>REV</th><th>REVISIONS</th><th>BY</th><th>SIGN</th><th>DATE</th><th>APPROVED</th></tr><tr><td>D</td><td></td><td>CHECKED</td><td></td><td></td><td></td></tr><tr><td>C</td><td></td><td>BY</td><td></td><td></td><td></td></tr><tr><td>B</td><td></td><td>CHECKED</td><td></td><td></td><td></td></tr><tr><td>A</td><td></td><td>BY</td><td></td><td></td><td></td></tr><tr><td></td><td></td><td>CHECKED</td><td></td><td></td><td></td></tr></table> <table><tr><th>Designed by</th><th>D.K</th><th>Drawn by</th><th>D.K</th></tr><tr><td>Checked by</td><td>FMK</td><td>Approved by</td><td>FMK</td></tr><tr><td>Scales</td><td>1:150</td><td>Date:</td><td>OCTOBER 2021</td></tr><tr><td>Job No.</td><td>FC/CE108</td><td>ACAD File:</td><td>CE108_PL_02</td></tr><tr><td>P STATUS</td><td>DRG No.</td><td>FC/CE108/PL/02</td><td>REV</td></tr></table>		REV	REVISIONS	BY	SIGN	DATE	APPROVED	D		CHECKED				C		BY				B		CHECKED				A		BY						CHECKED				Designed by	D.K	Drawn by	D.K	Checked by	FMK	Approved by	FMK	Scales	1:150	Date:	OCTOBER 2021	Job No.	FC/CE108	ACAD File:	CE108_PL_02	P STATUS	DRG No.	FC/CE108/PL/02	REV
REV	REVISIONS	BY	SIGN	DATE	APPROVED																																																														
D		CHECKED																																																																	
C		BY																																																																	
B		CHECKED																																																																	
A		BY																																																																	
		CHECKED																																																																	
Designed by	D.K	Drawn by	D.K																																																																
Checked by	FMK	Approved by	FMK																																																																
Scales	1:150	Date:	OCTOBER 2021																																																																
Job No.	FC/CE108	ACAD File:	CE108_PL_02																																																																
P STATUS	DRG No.	FC/CE108/PL/02	REV																																																																

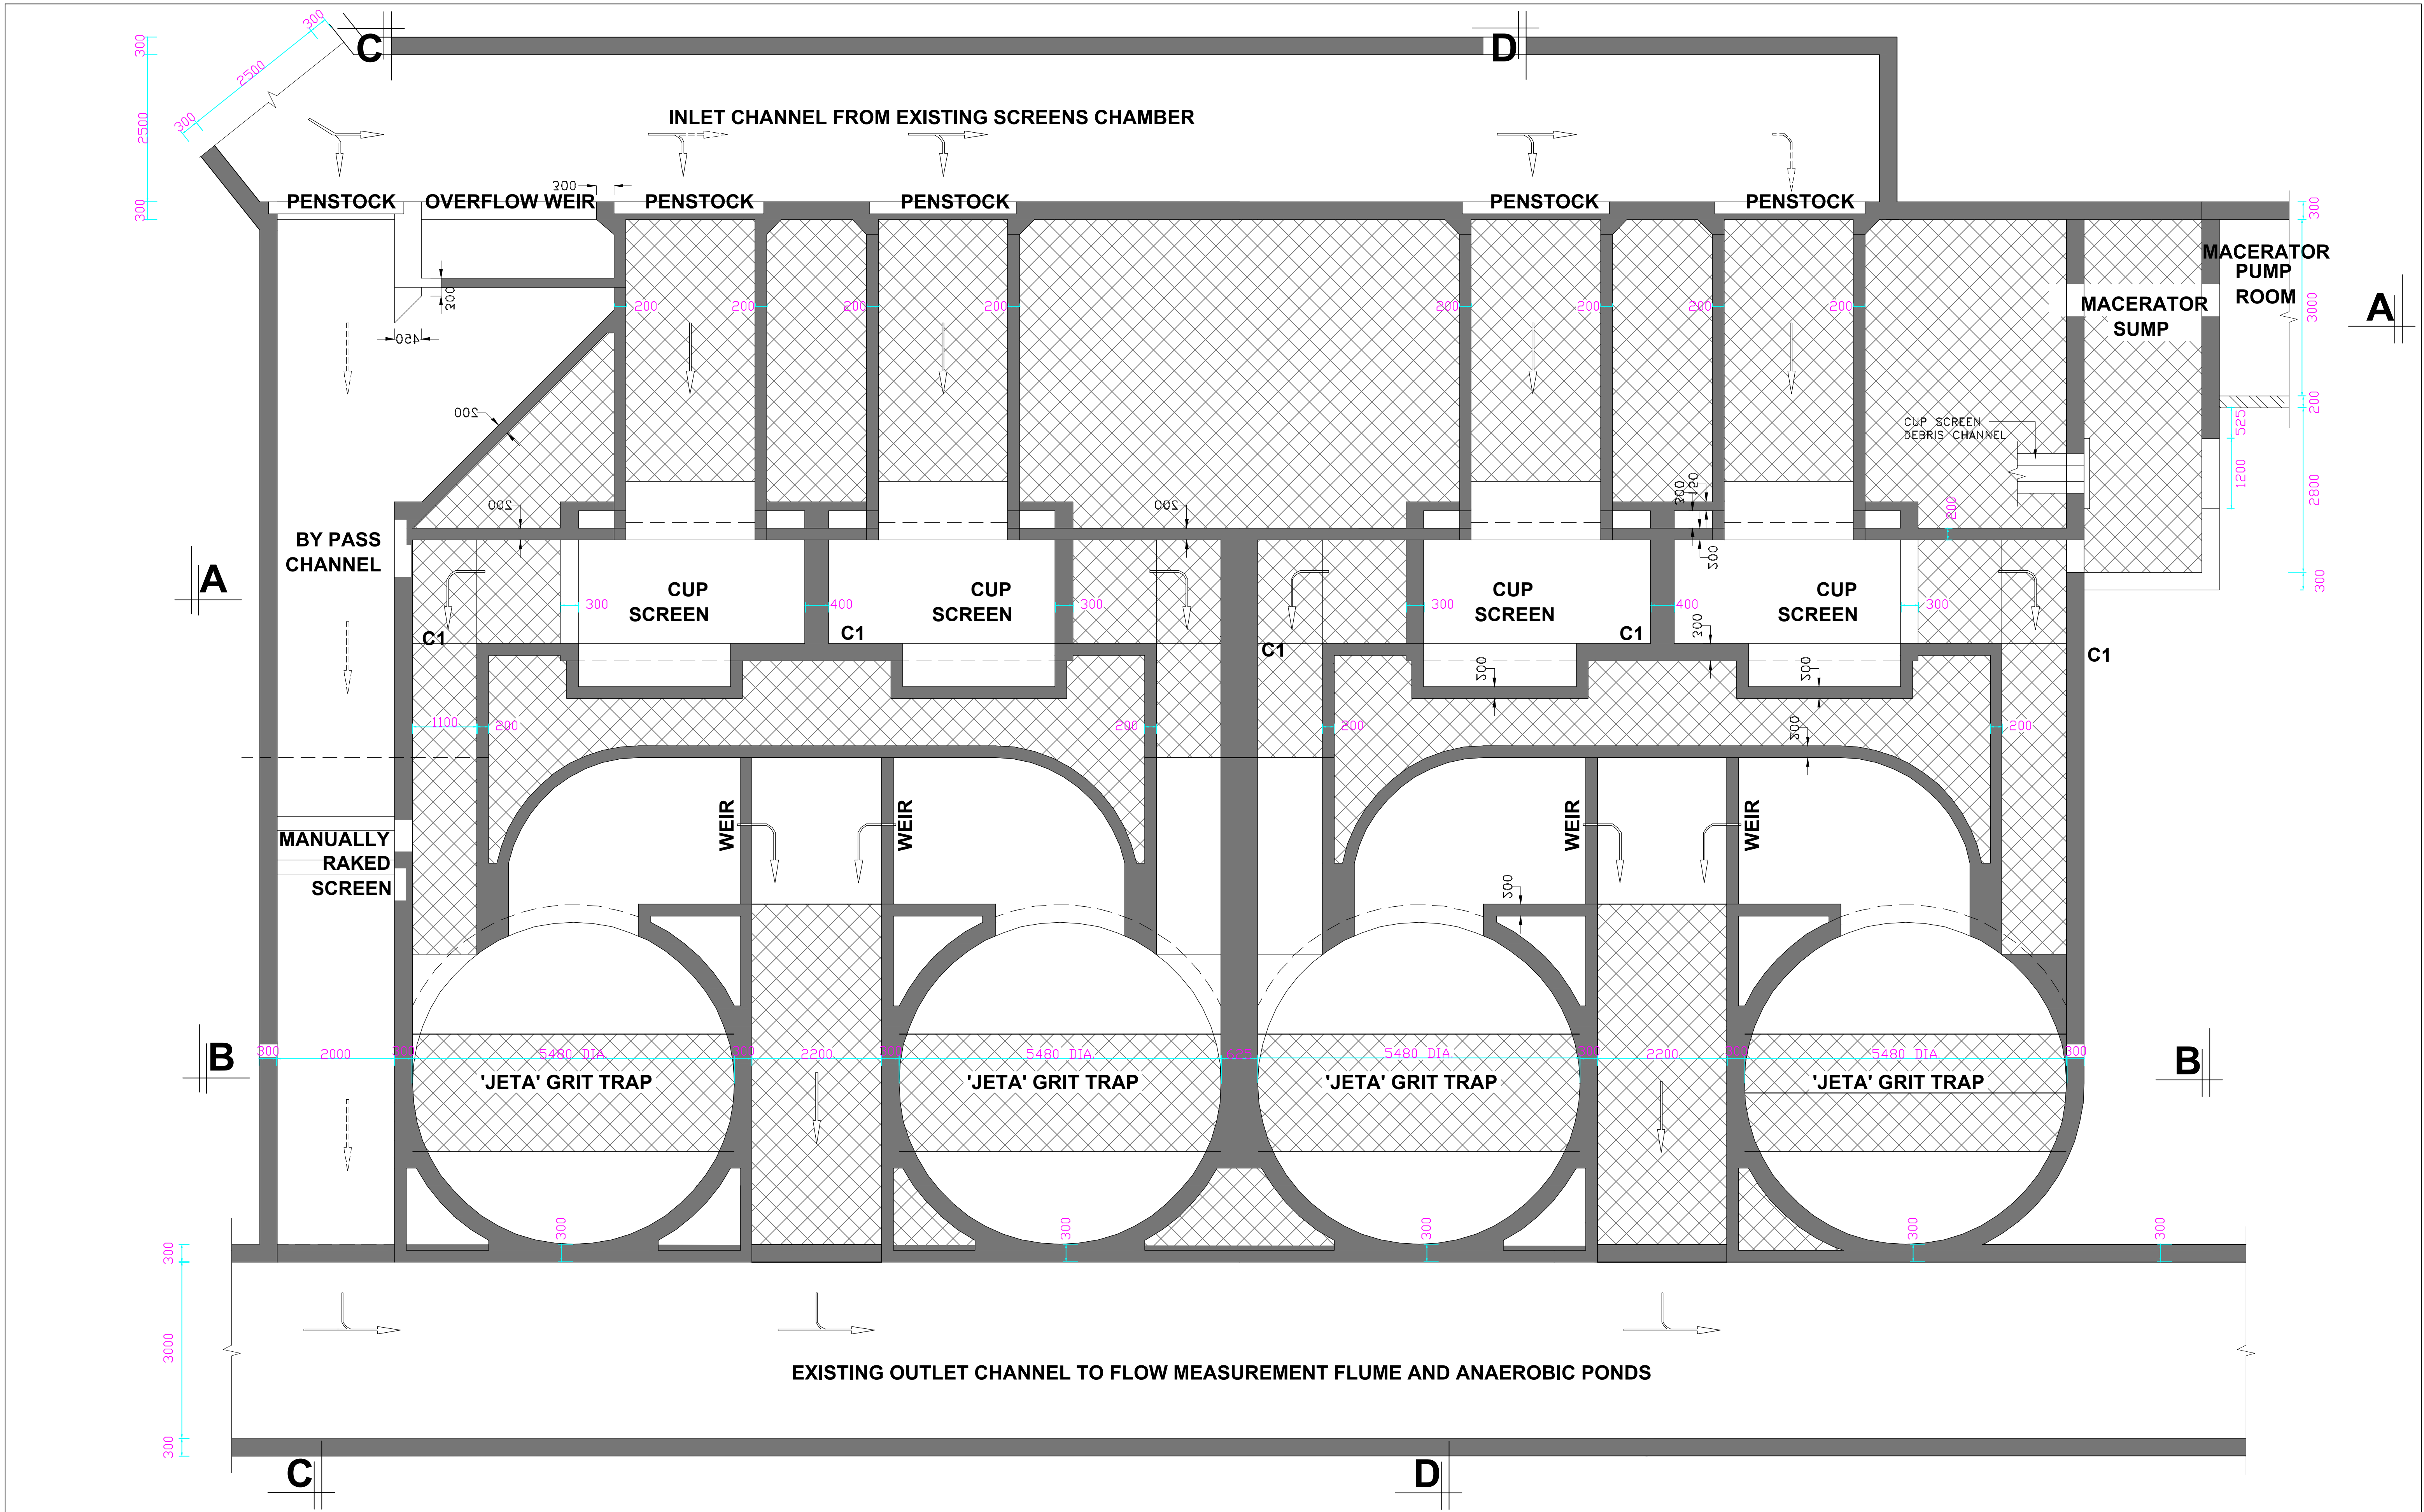

Civil Engineer:		Client:		Project:		Drawing Title:		NOTES:		REV.		ACTIONS	
 Frame Consultants Ltd P.O. BOX 58624-00200, NAIROBI. TEL: 2213744, 2251505, 0720523850 E-mail: info@frameconsultants.com		 ATHI WATER WORKS DEVELOPMENT AGENCY P.O BOX 45283 - 00100 NAIROBI, Tel: +254 (0) 274292/3 Email: info@awwda.go.ke		NAIROBI RIVERS BASIN REHABILITATION AND RESTORATION PROGRAMME: SEWERAGE IMPROVEMENT PROJECT PHASE II (NaRSIP II) REHABILITATION AND EXPANSION OF DANDORA ESTATE SEWAGE TREATMENT PLANT (DESTP) INLET WORKS		DANDORA ESTATE SEWAGE TREATMENT PLANT (DESTP) LAYOUT PLAN OF PROPOSED WORKS		1. DRAWING TO SCALE ON A1 PAPER SIZE 2. DRAWING TO BE READ IN CONJUNCTION WITH OTHER RELEVANT DRAWINGS 3. ALL DIMENSIONS AND LEVELS TO CHECKED ON SITE BEFORE COMMENCING ANY WORK. ANY DISCREPANCY TO BE REPORTED TO THE ENGINEER 4. ONLY FIGURED DIMENSIONS TO BE TAKEN FROM THIS DRAWING		REVISIONS		SIGN	
										DATE		APPROVED	
										BY		DESIGNED BY	
										CHECKED BY		DRAWN BY	
										BY		APPROVED BY	
D		C		B		A		P		STATUS			
BY		CHECKED		BY		CHECKED		BY		CHECKED			
BY		CHECKED		BY		CHECKED		BY		CHECKED			
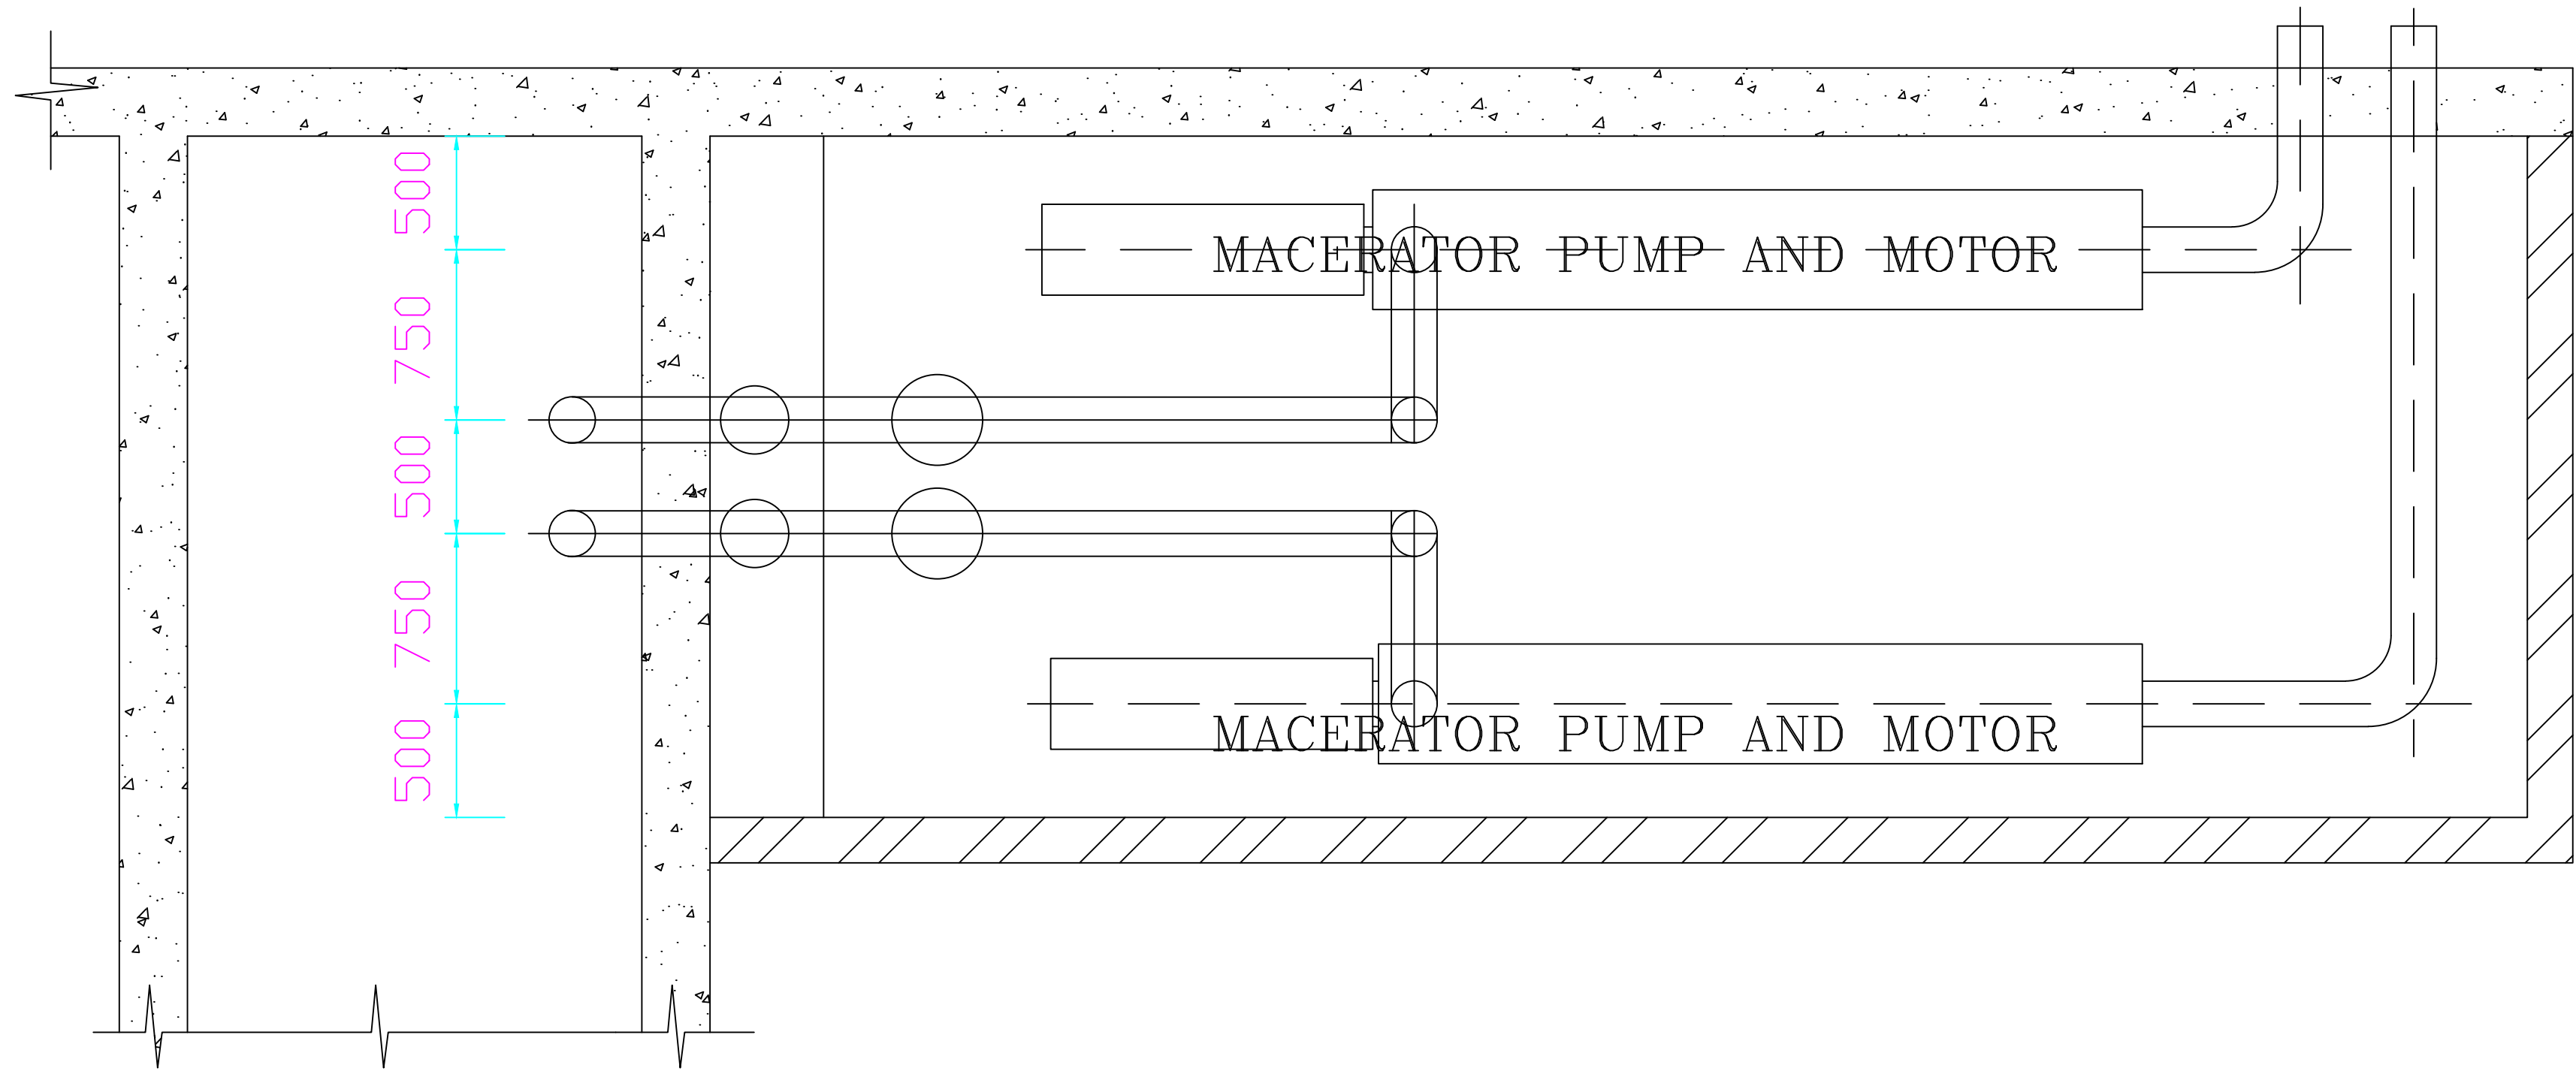


LAYOUT PLAN

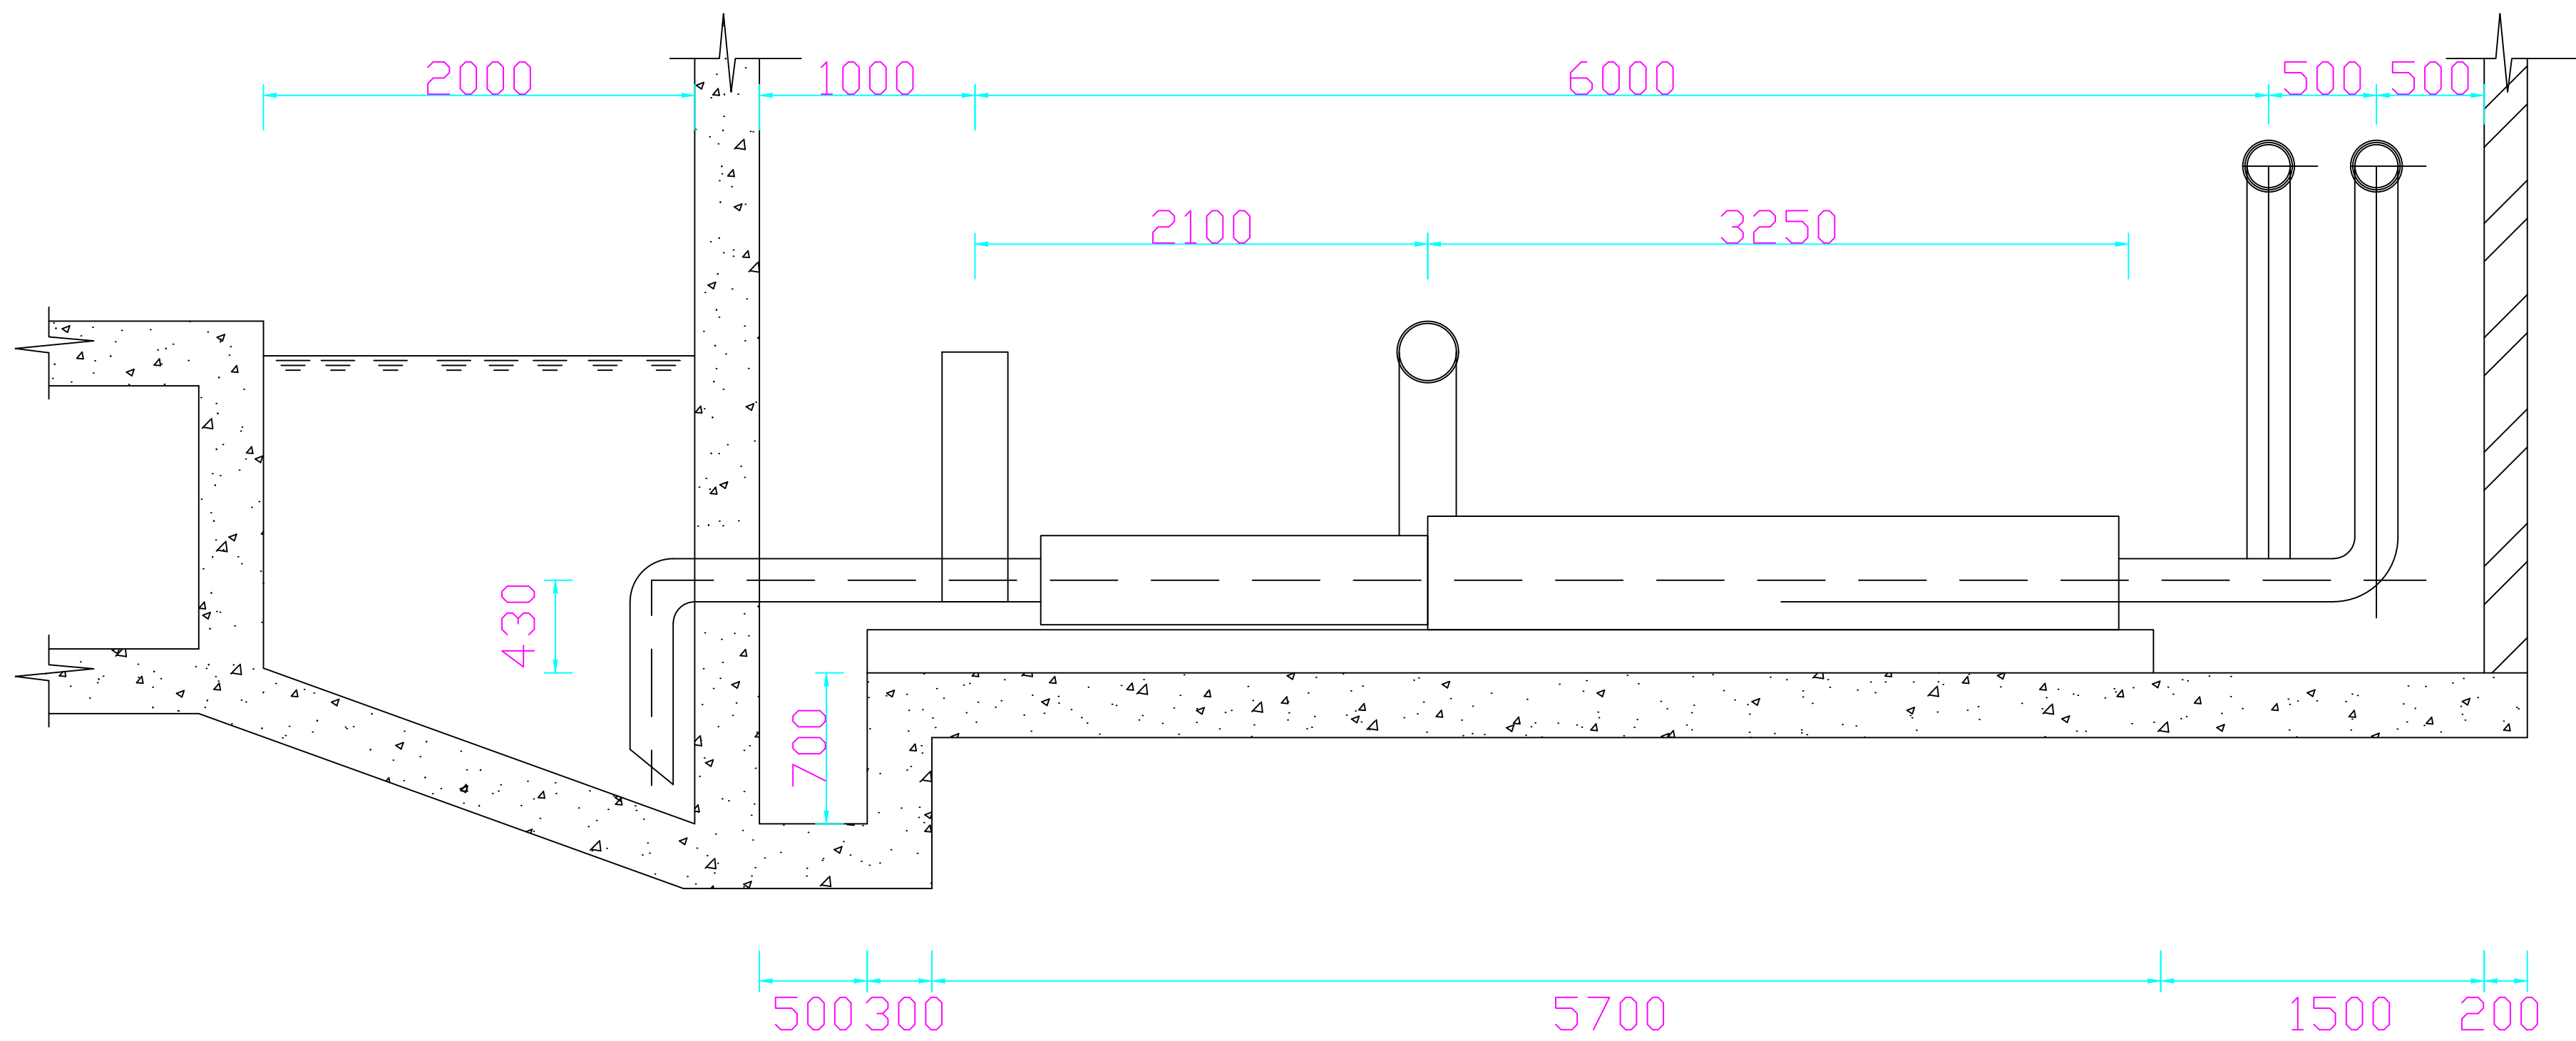


SECTION





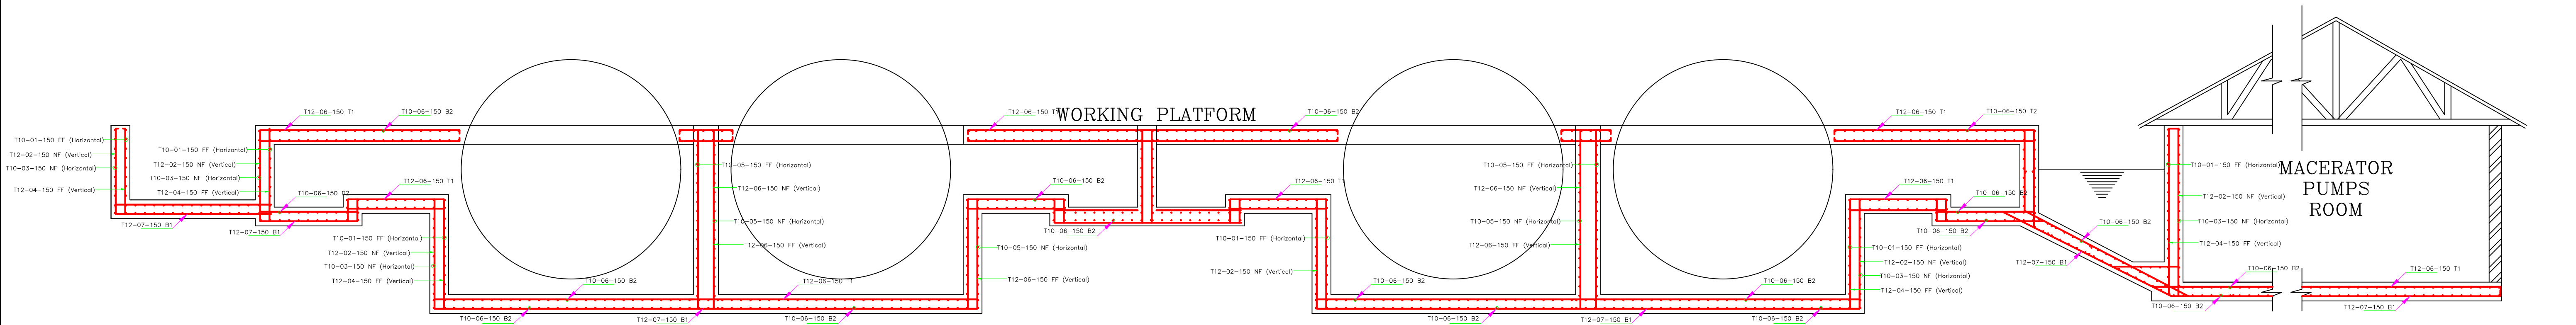


SECTION A-A
CUP SCREENS SECTION

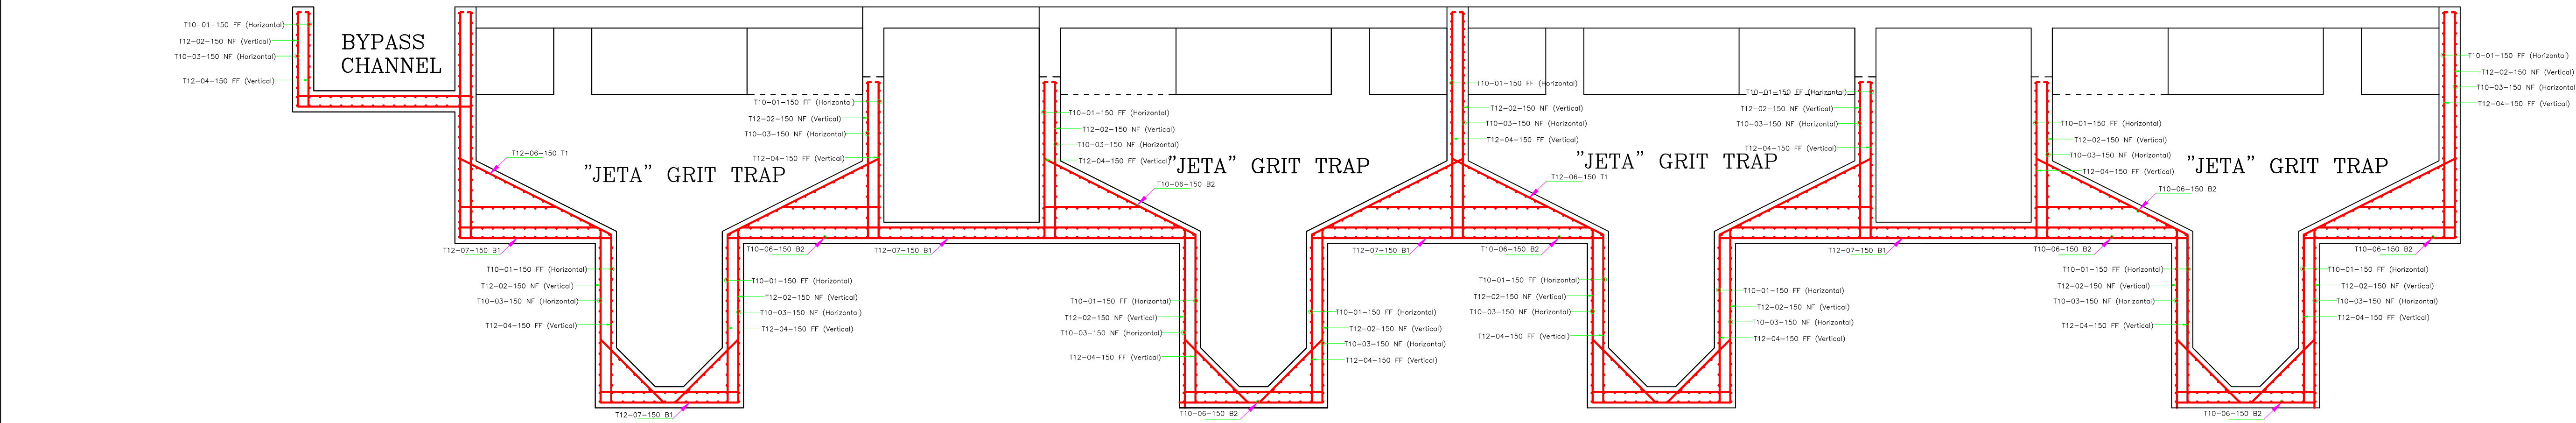

SECTION B-B
GRIT TRAP SECTION

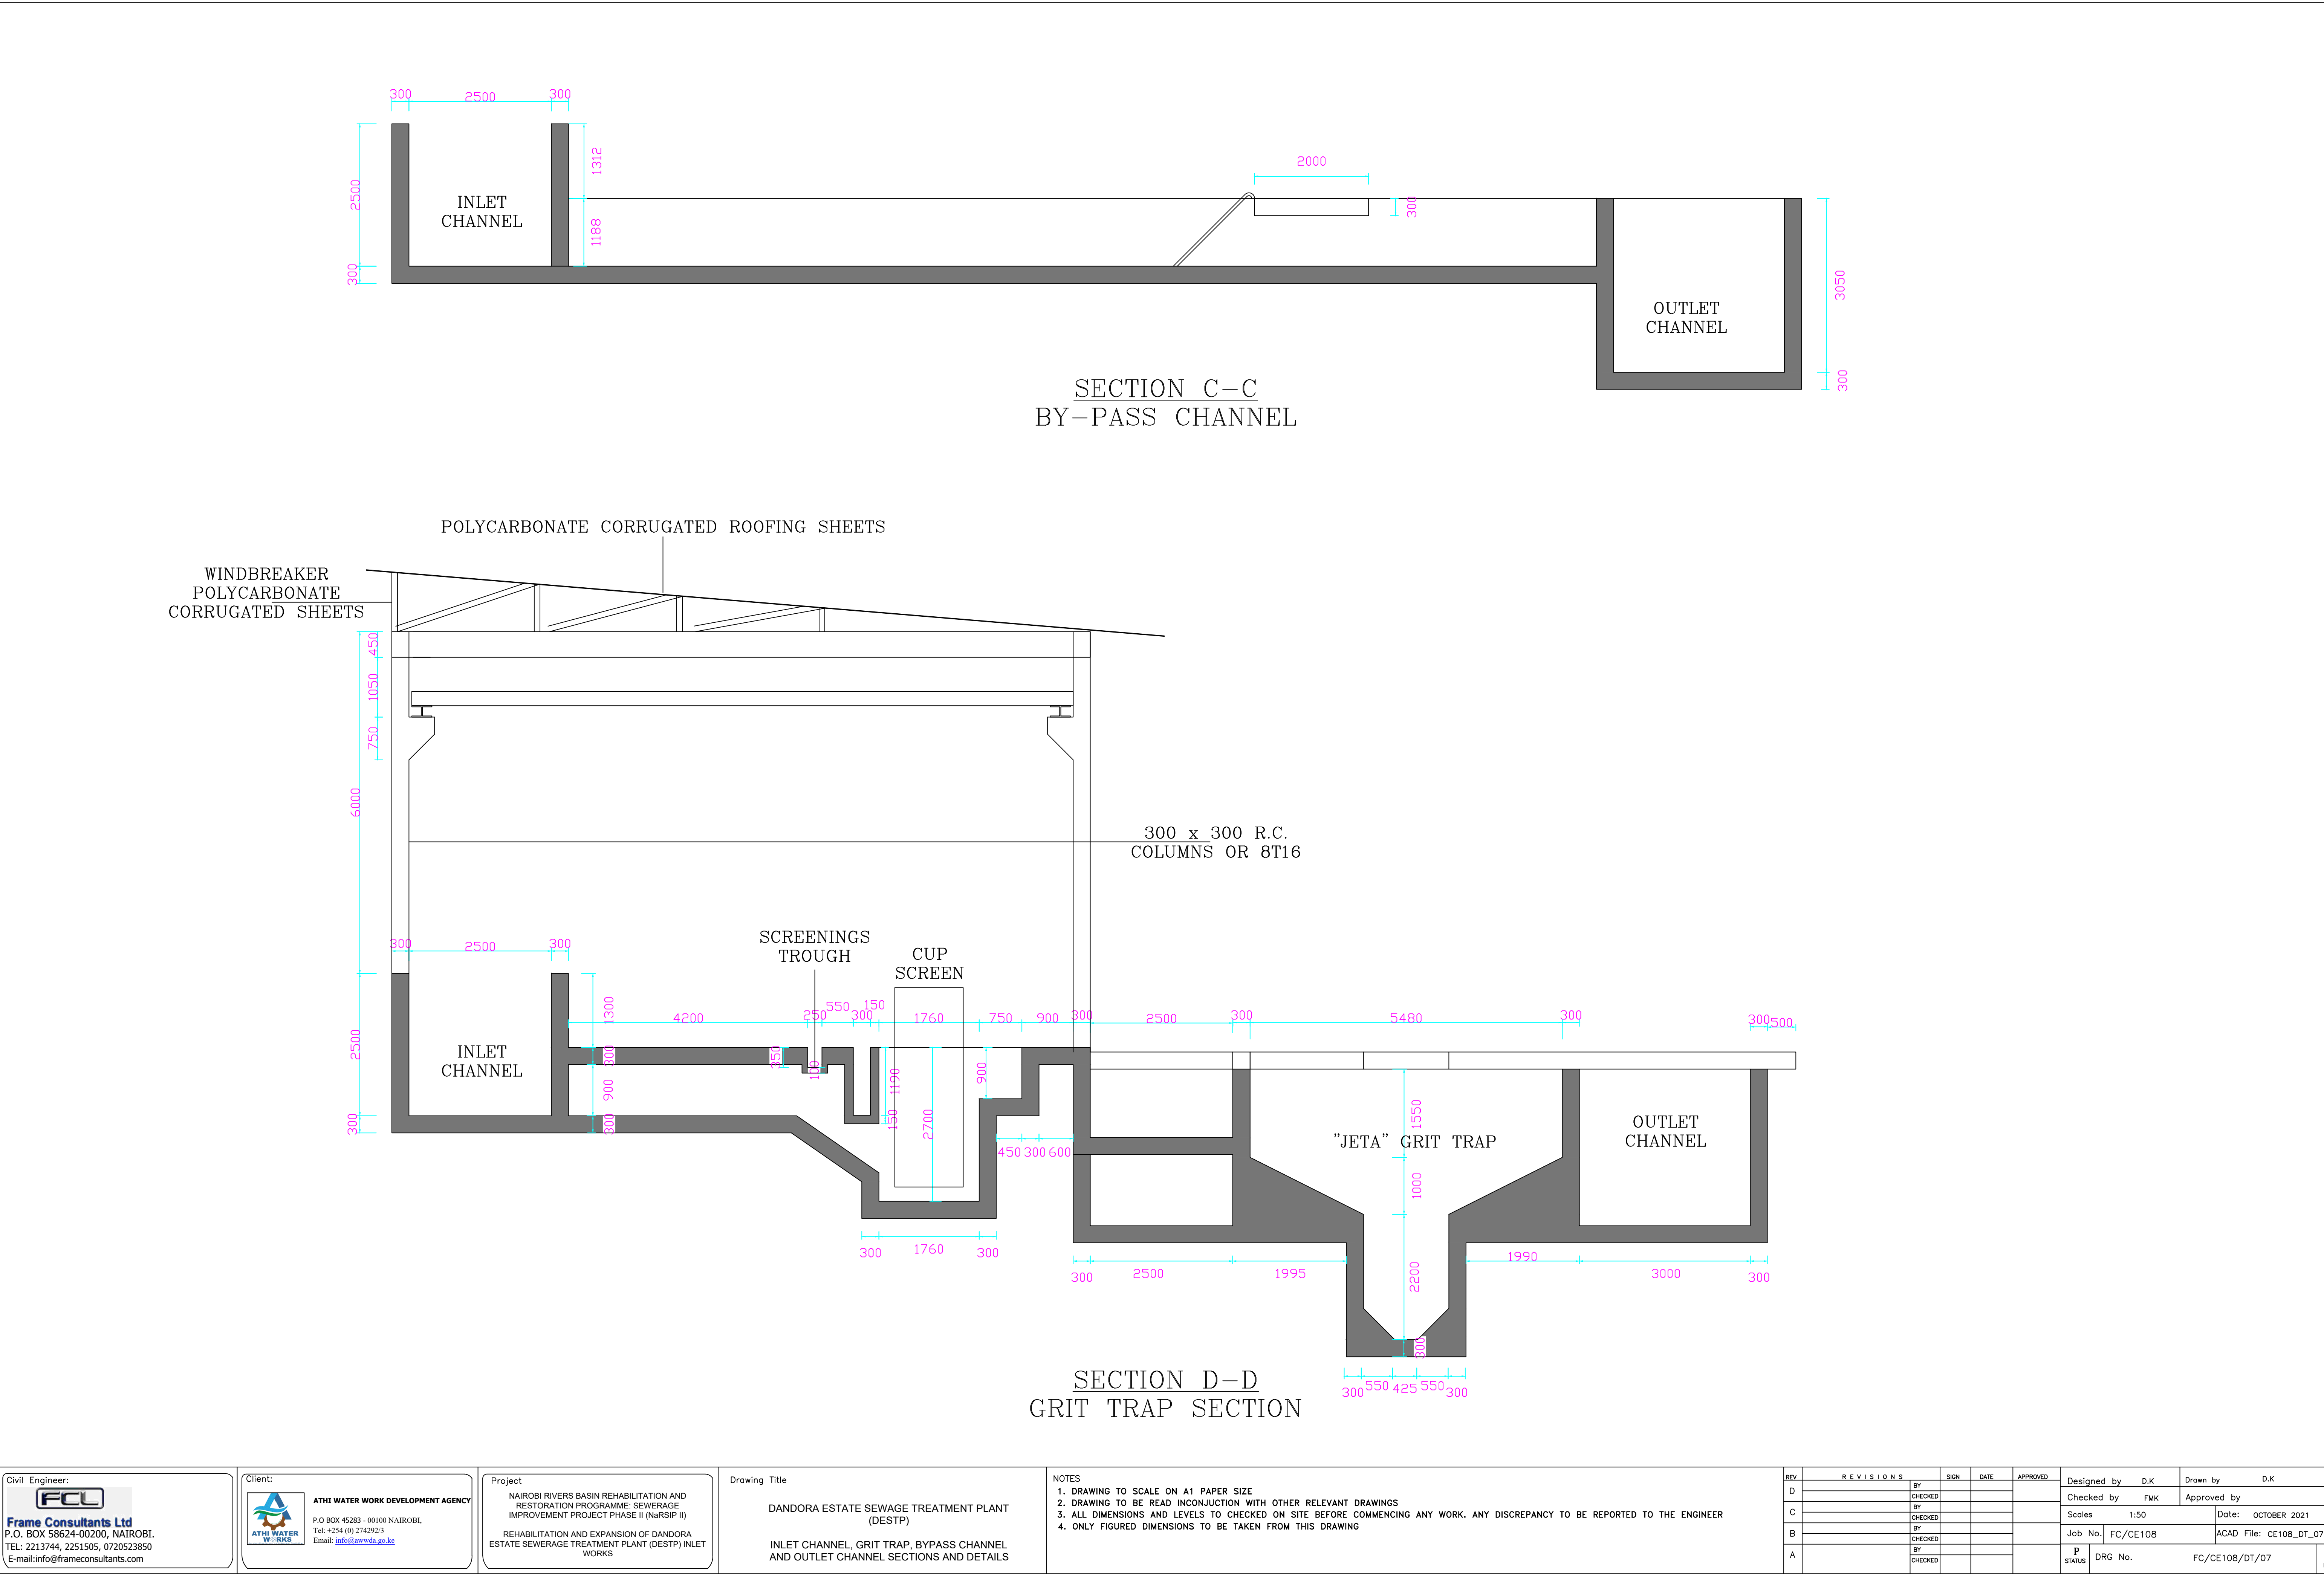

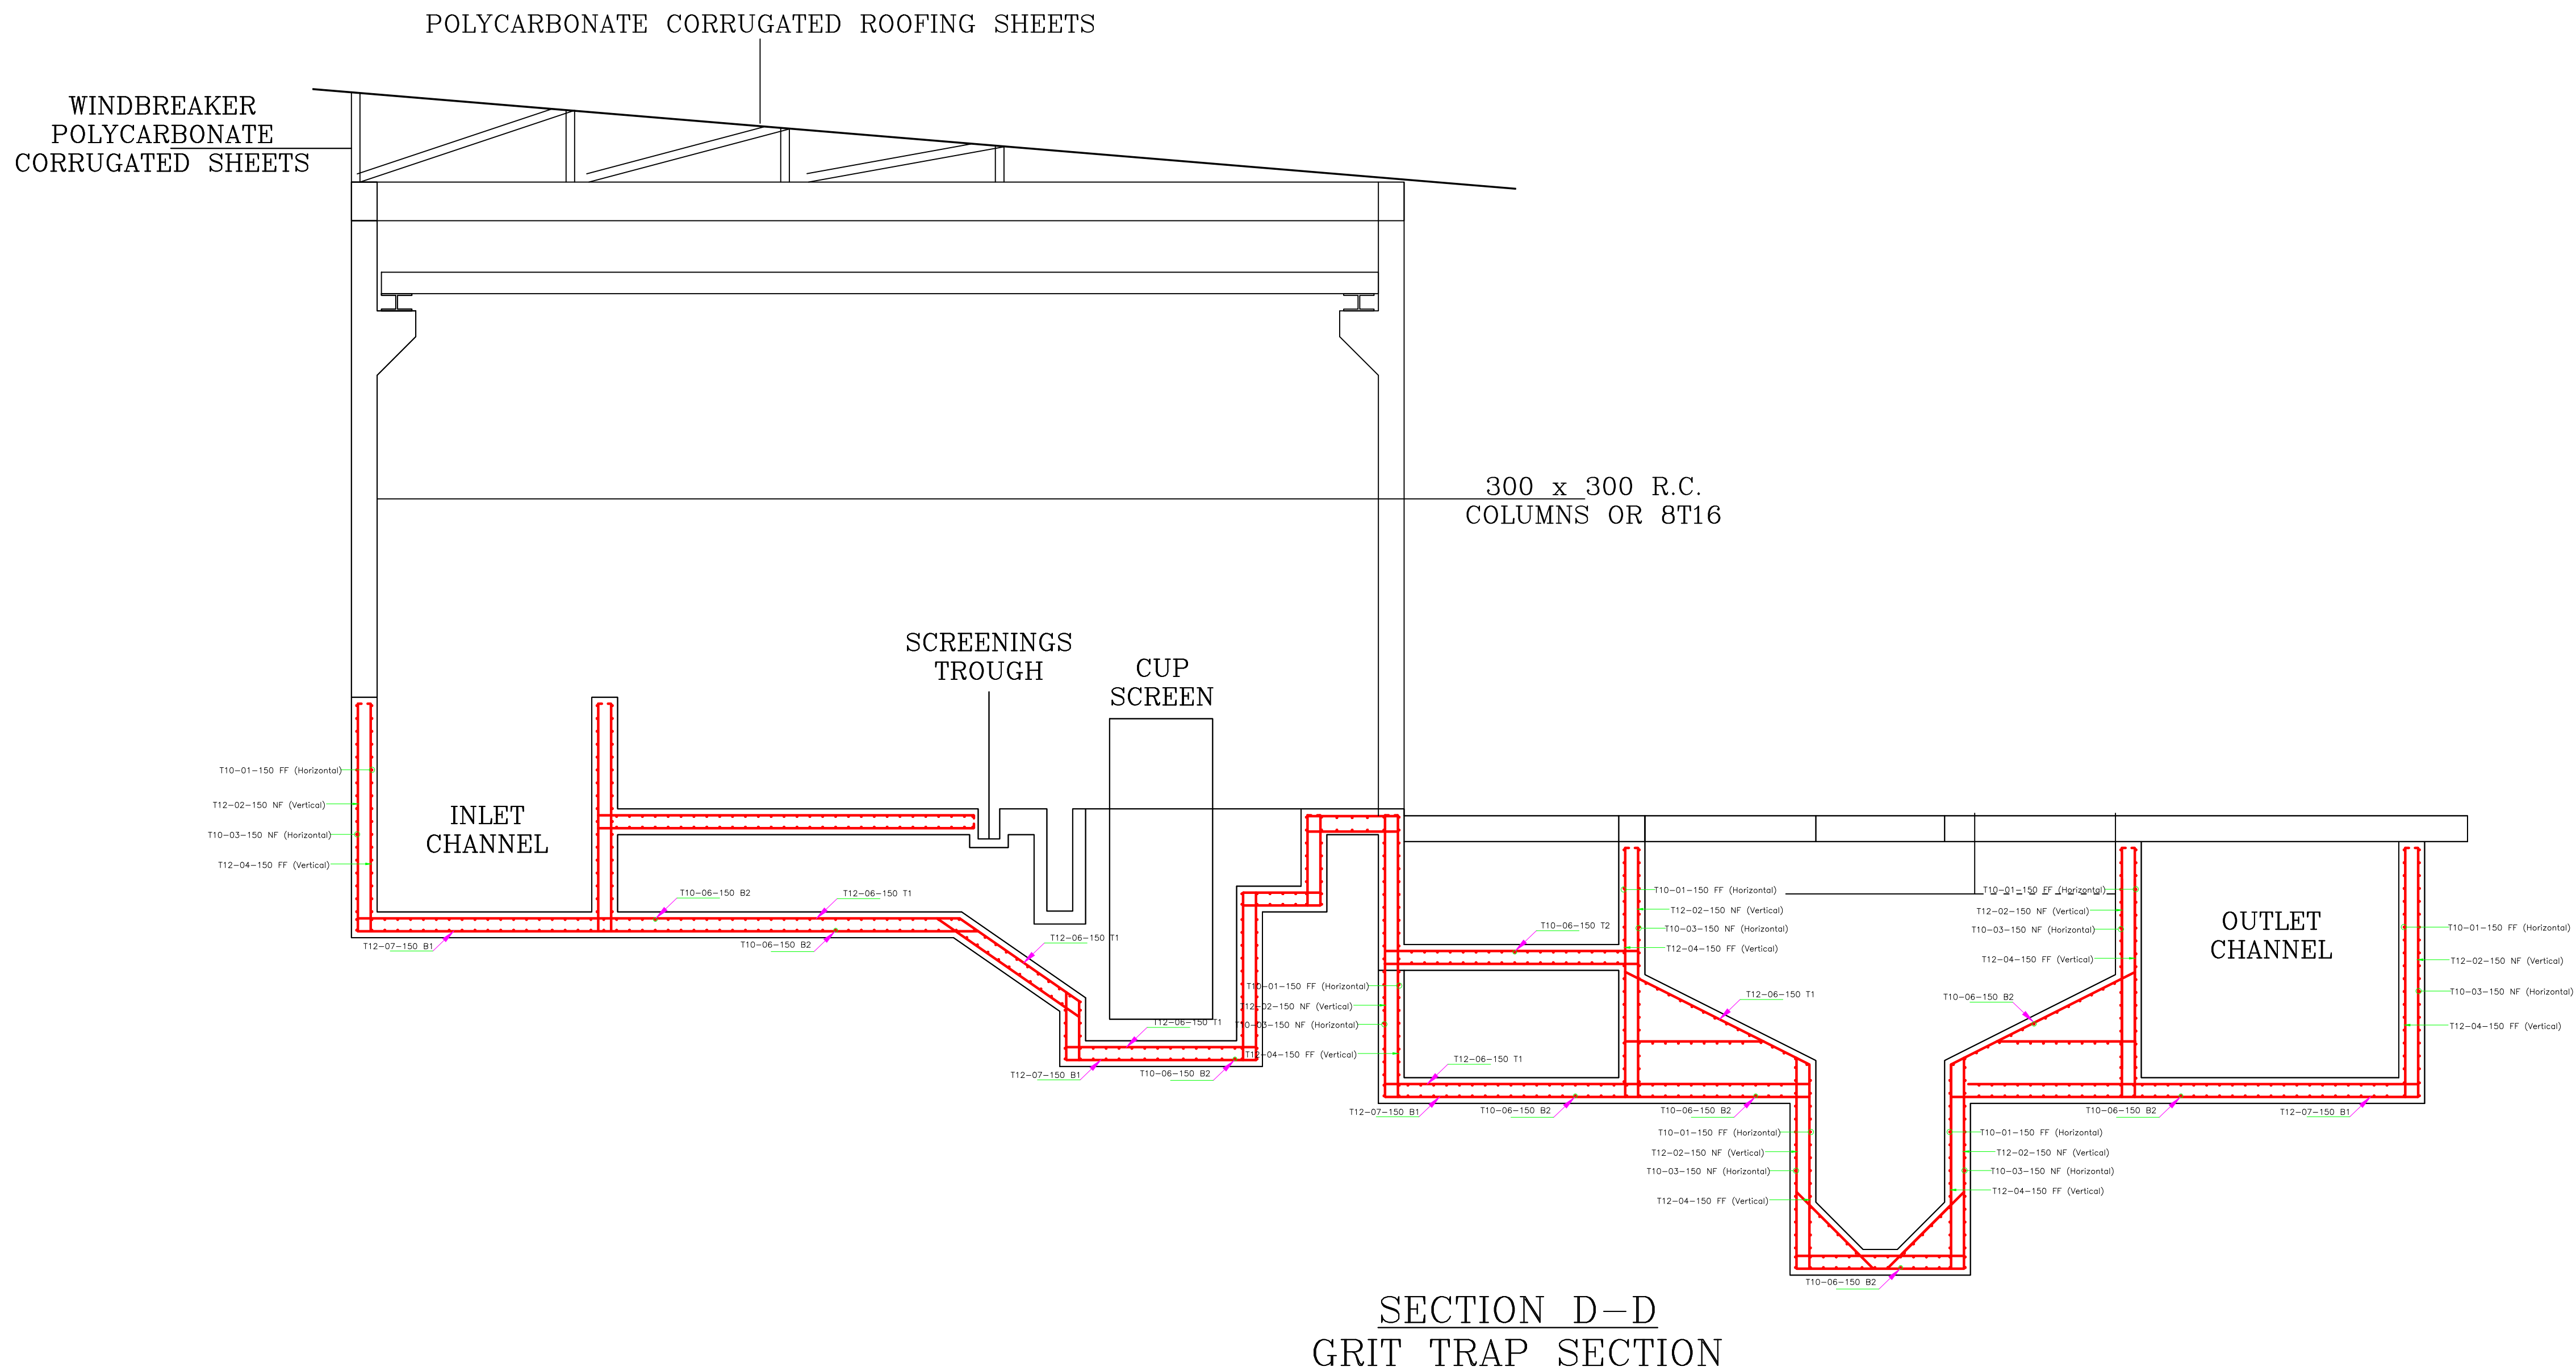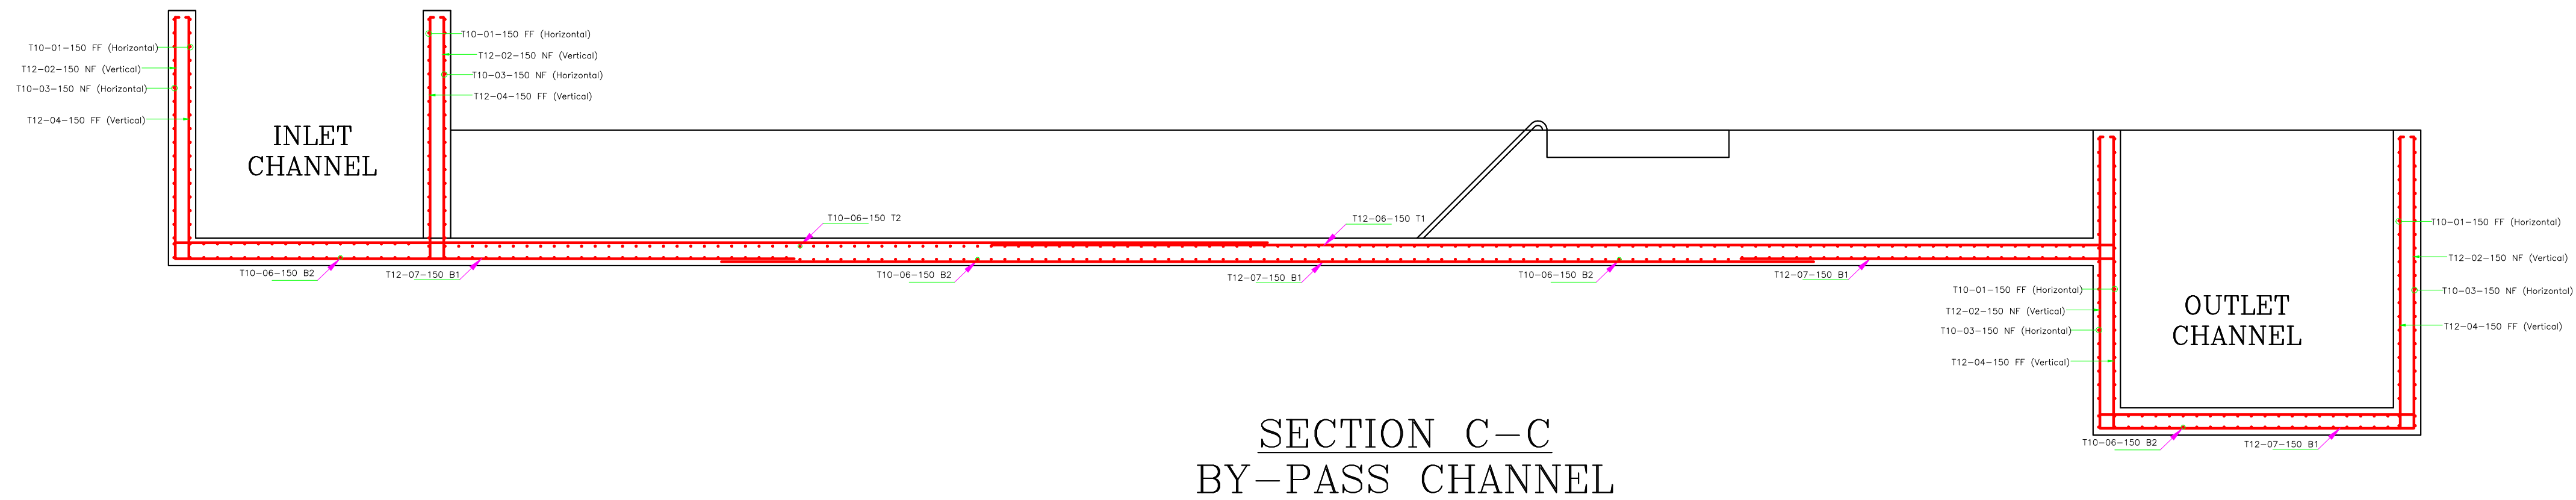

Civil Engineer:

Frame Consultants Ltd
P.O. BOX 58624-00200, NAIROBI.
TEL: 2213744, 2251505, 0720523850
E-mail: info@frameconsultants.com

Client:

ATHI WATER WORKS DEVELOPMENT AGENCY
P.O BOX 45283 - 00100 NAIROBI,
Tel: +254 (0) 274292/3
Email: info@awwda.go.ke

Project

NAIROBI RIVERS BASIN REHABILITATION AND RESTORATION PROGRAMME: SEWERAGE IMPROVEMENT PROJECT PHASE II (NARSIP II)
REHABILITATION AND EXPANSION OF DANDORA ESTATE SEWERAGE TREATMENT PLANT (DESTP) INLET WORKS

Drawing Title

DANDORA ESTATE SEWAGE TREATMENT PLANT (DESTP)
INLET CHANNEL, GRIT TRAP, BYPASS CHANNEL AND OUTLET CHANNEL REINFORCEMENT DETAILS

NOTES

1. Read this drawing in conjunction with relevant G.A., Services and Architectural drawings. Any discrepancy to be reported to the Engineer.
2. All dimensions are in millimetres unless specified otherwise.
3. All levels are indicated in mm unless specified otherwise.
4. All structural concrete to be Class 25 unless stated otherwise.


5. Minimum cover to all reinforcement to be:







- Stairs, Slabs & Walls = 20mm
 - Beams (main bars) = 30mm
 - Columns (main bars) = 40mm
 - Foundations = 50mm
6. All high tensile (Y) and mild steel (R) bars to be in accordance with BS 4449 and fabric mesh to be made from cold worked steel bars in accordance with BS 4483.


7. Maximum tolerance on concrete cover is +/- 5mm.

8. Minimum laps to all bars to be 550 unless stated otherwise.
9. Assumed Bearing Pressure taken to be 150 KN/m².
10. Nominal aggregate size to be 20mm.


REV	REVISIONS				APPROVED	Designed by	D.K	Drawn by	D.K
	BY	CHECKED	SIGN	DATE		Checked by	FMK	Approved by	
D		CHECKED				Scale	1:50	Date:	OCTOBER 2021
C		CHECKED				Job No.	FC/CE108	ACAD File:	CE108_DT_08
B		CHECKED				P STATUS	DRG No.	FC/CE108/DT/08	REV
A		CHECKED							

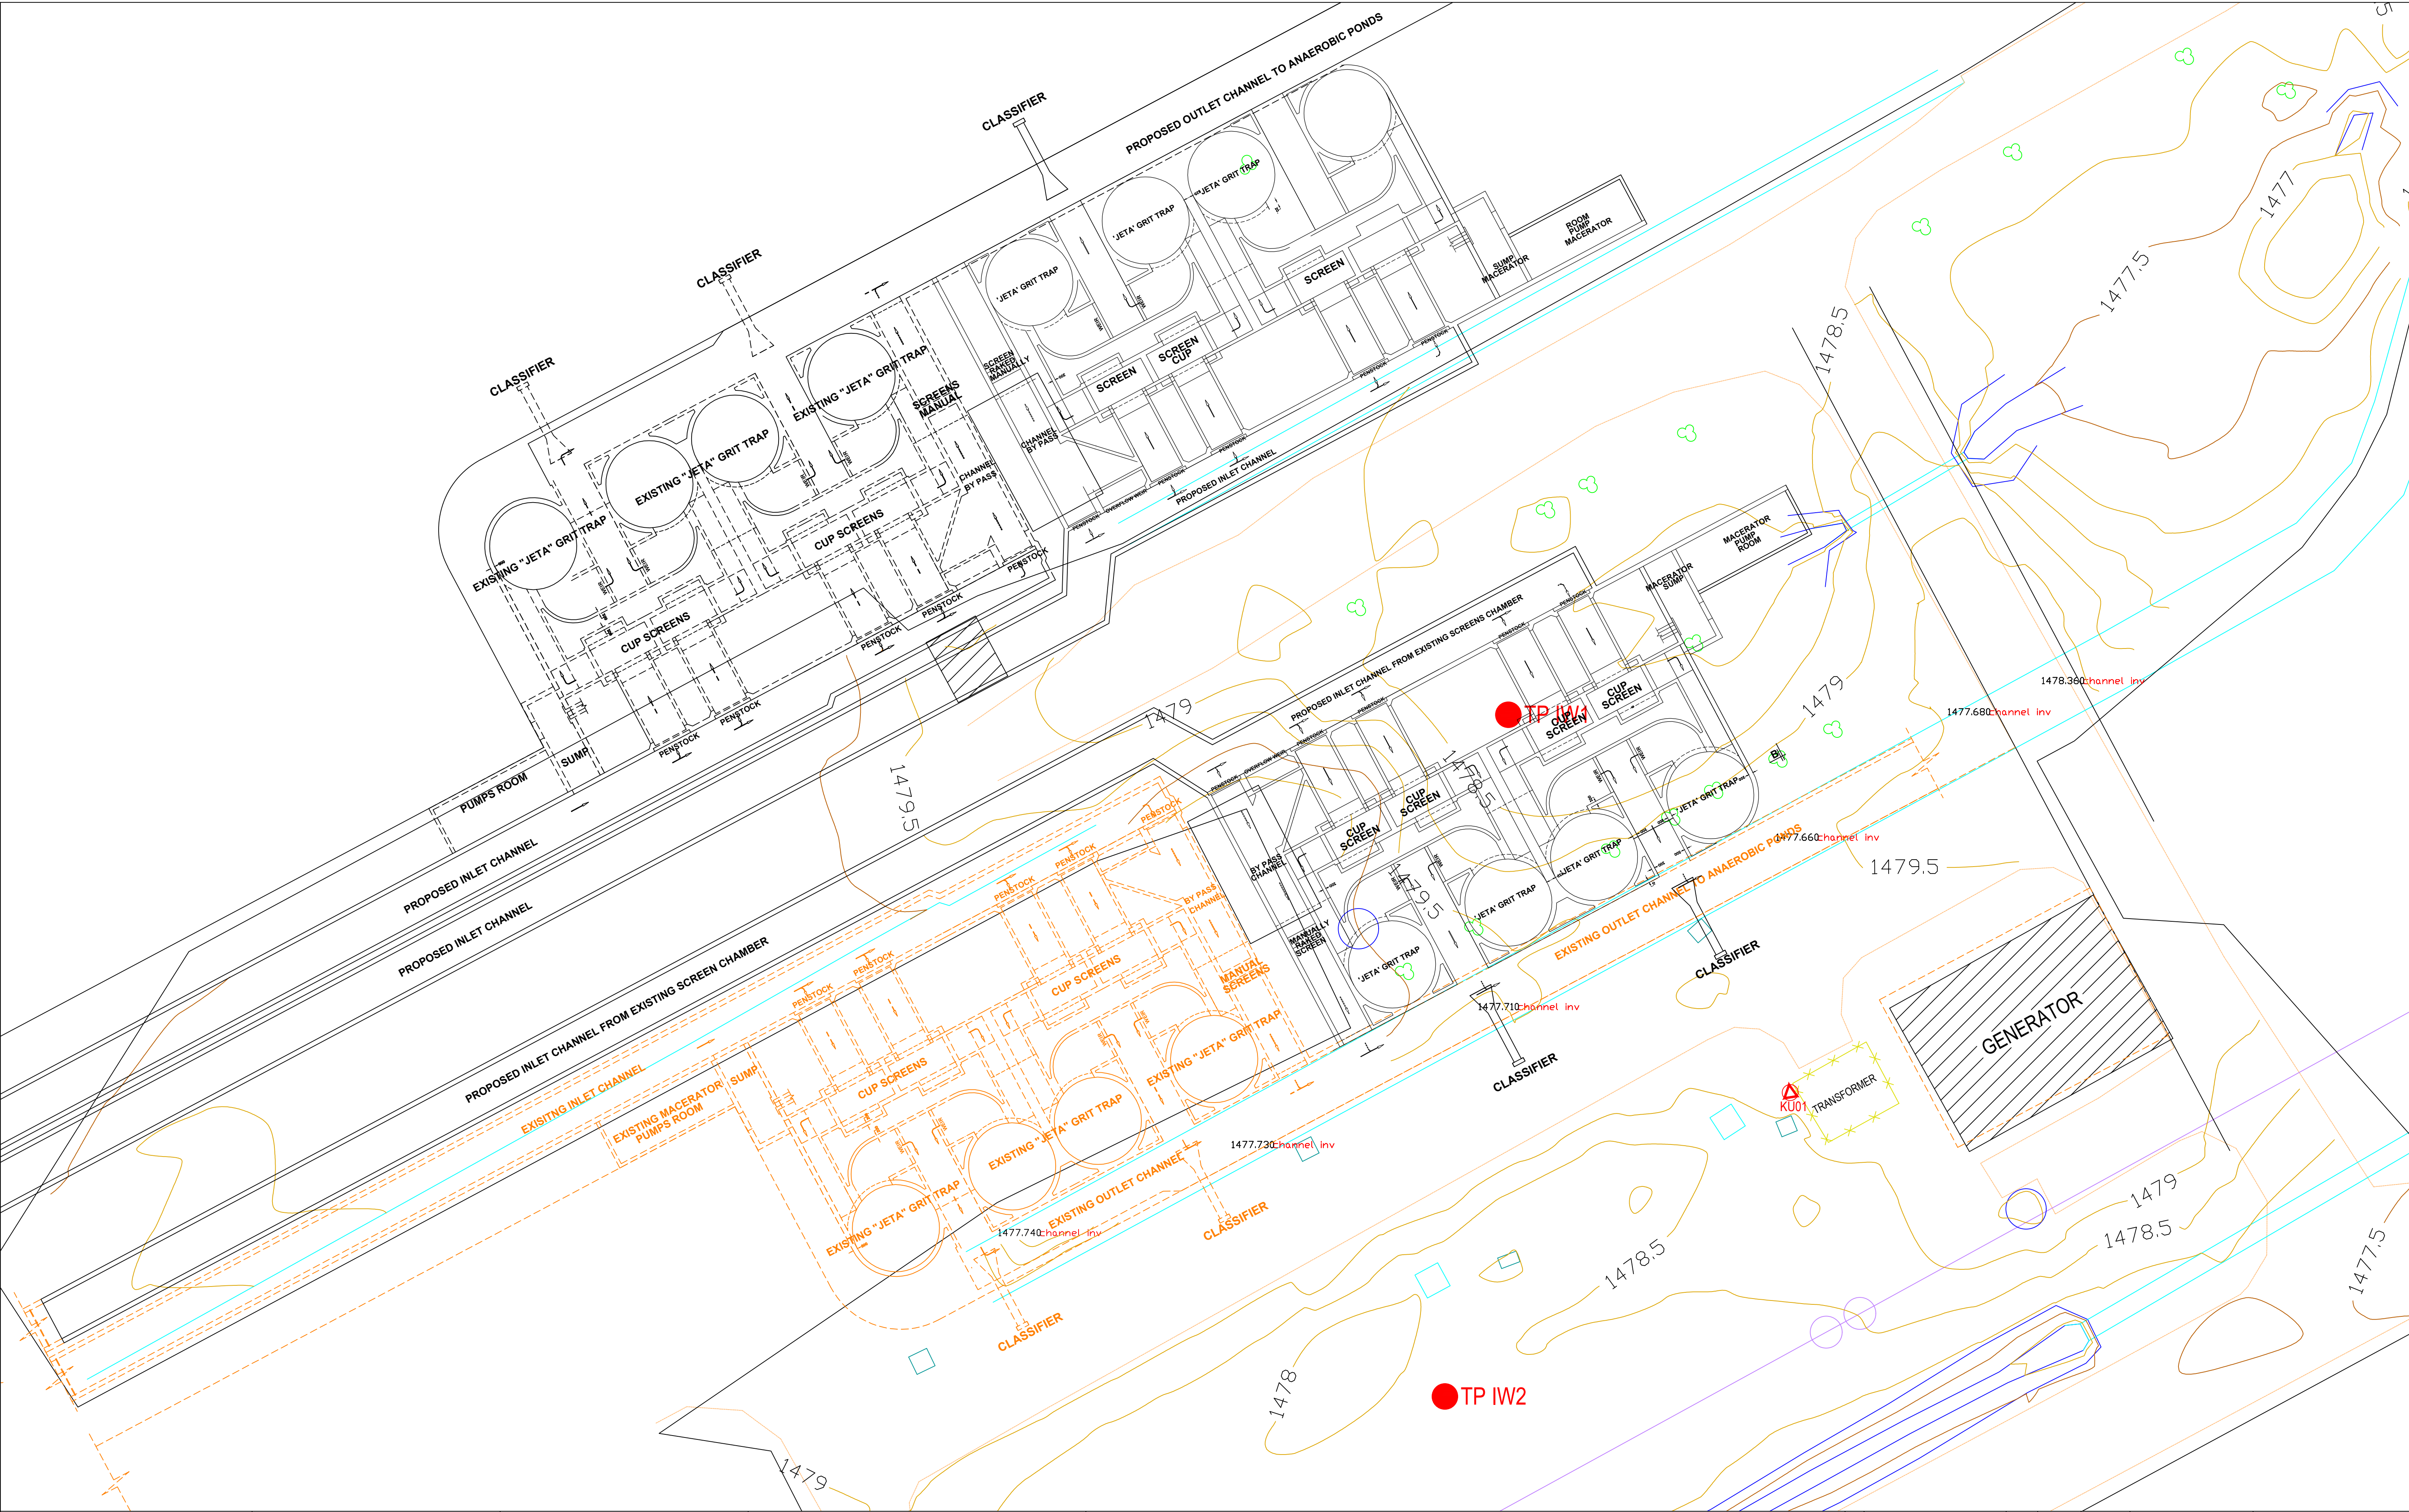

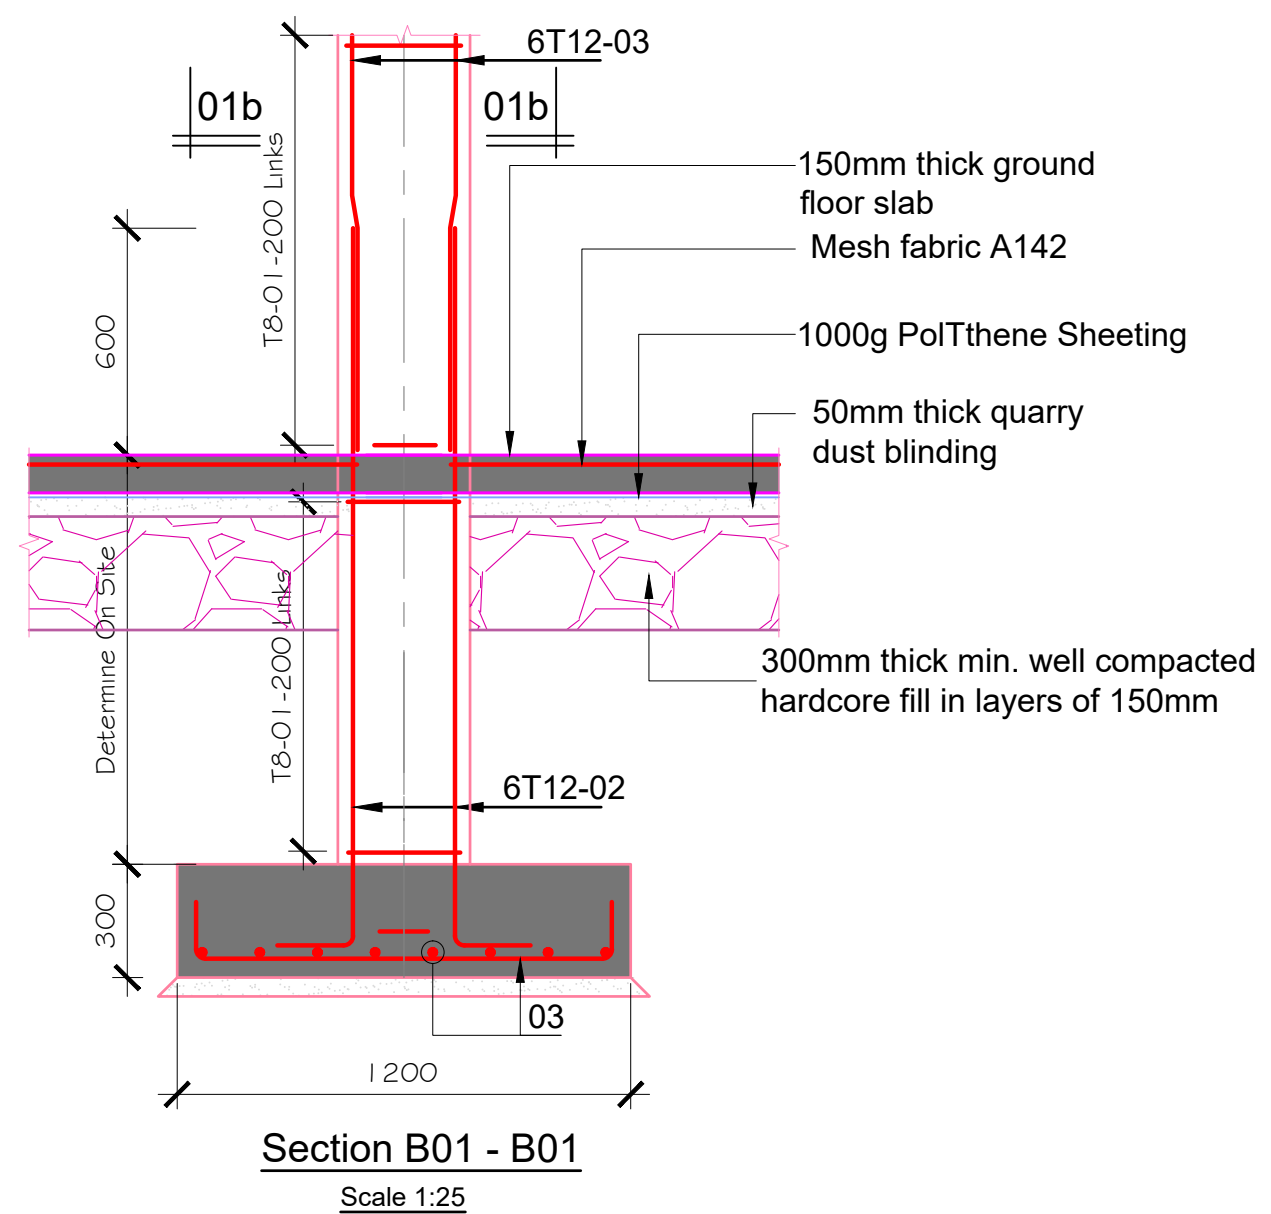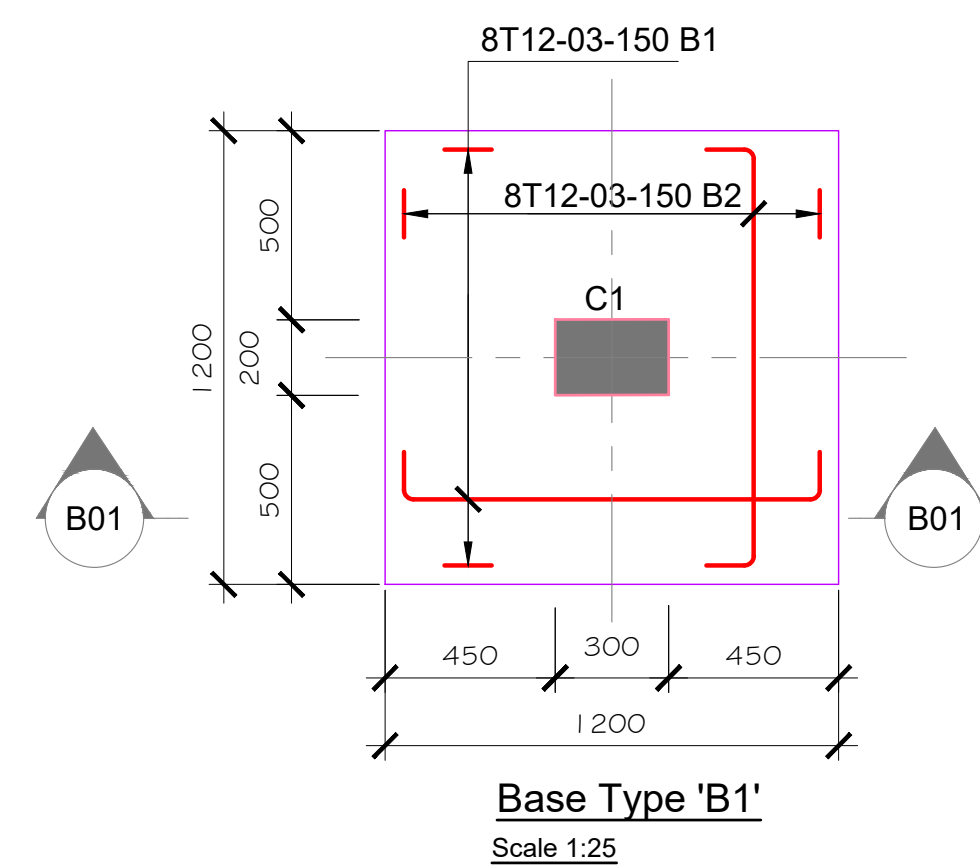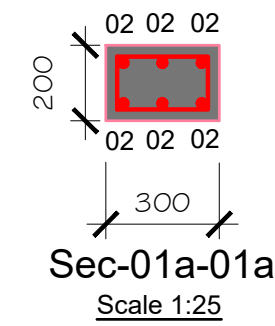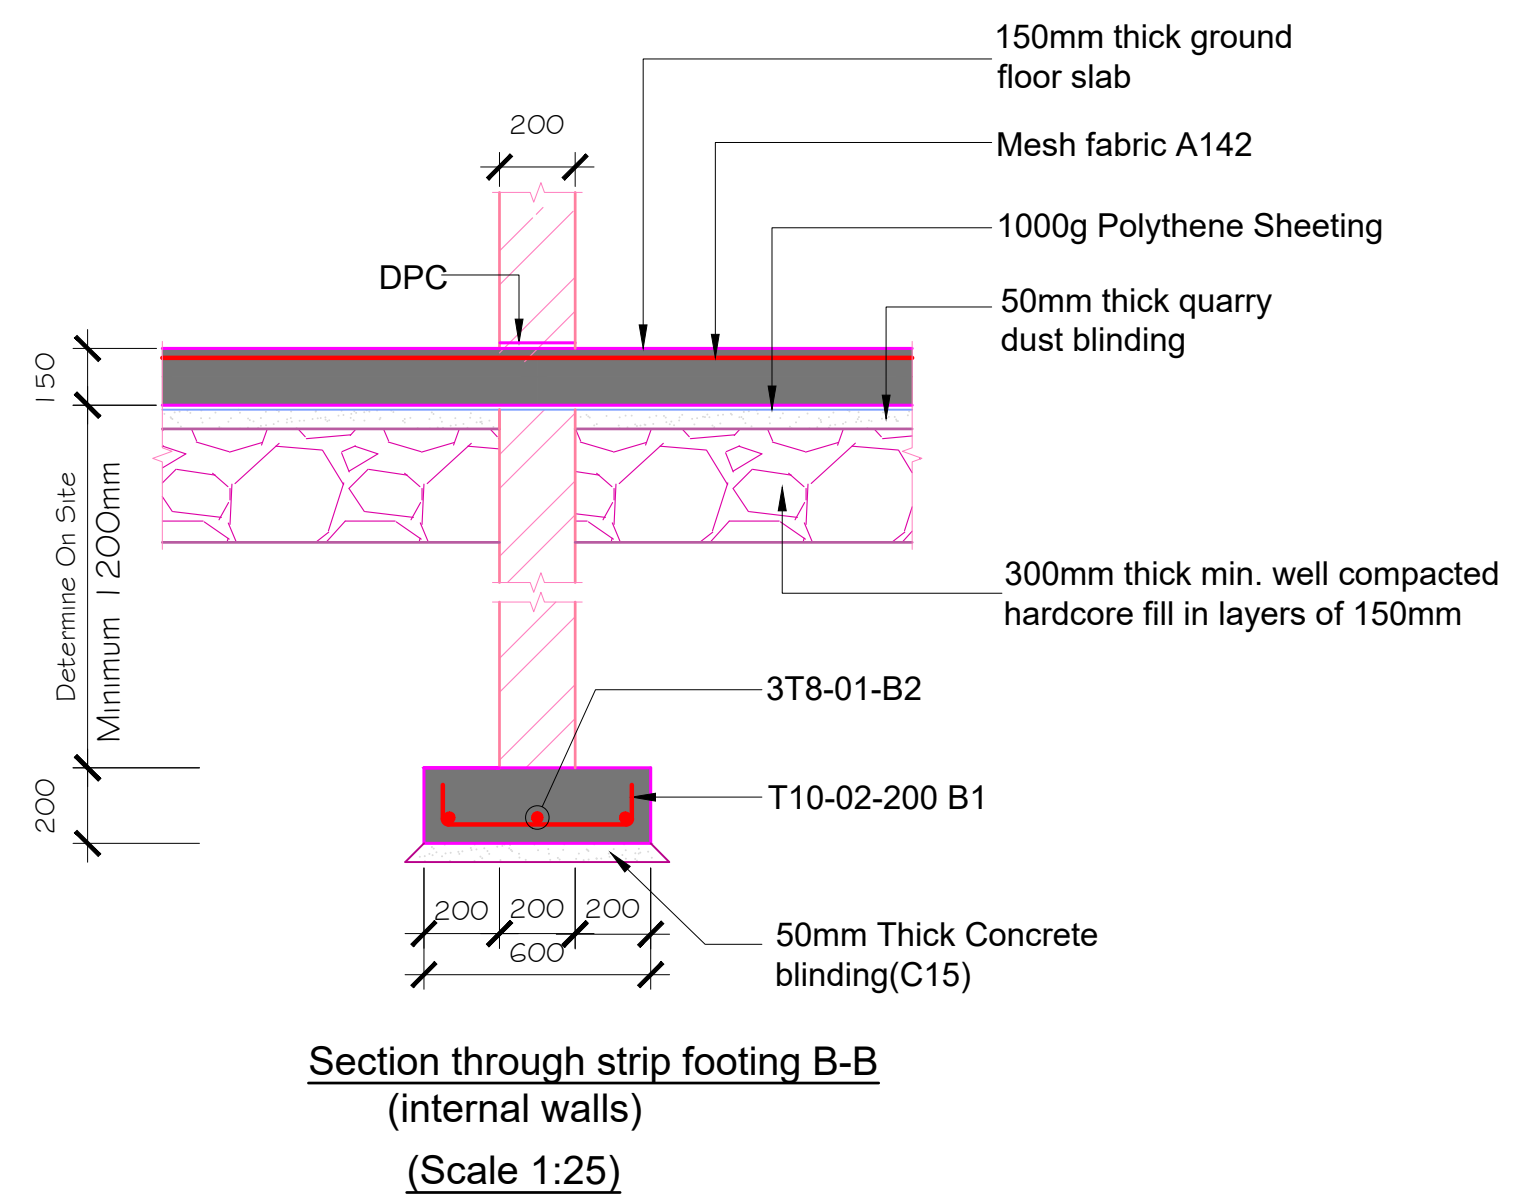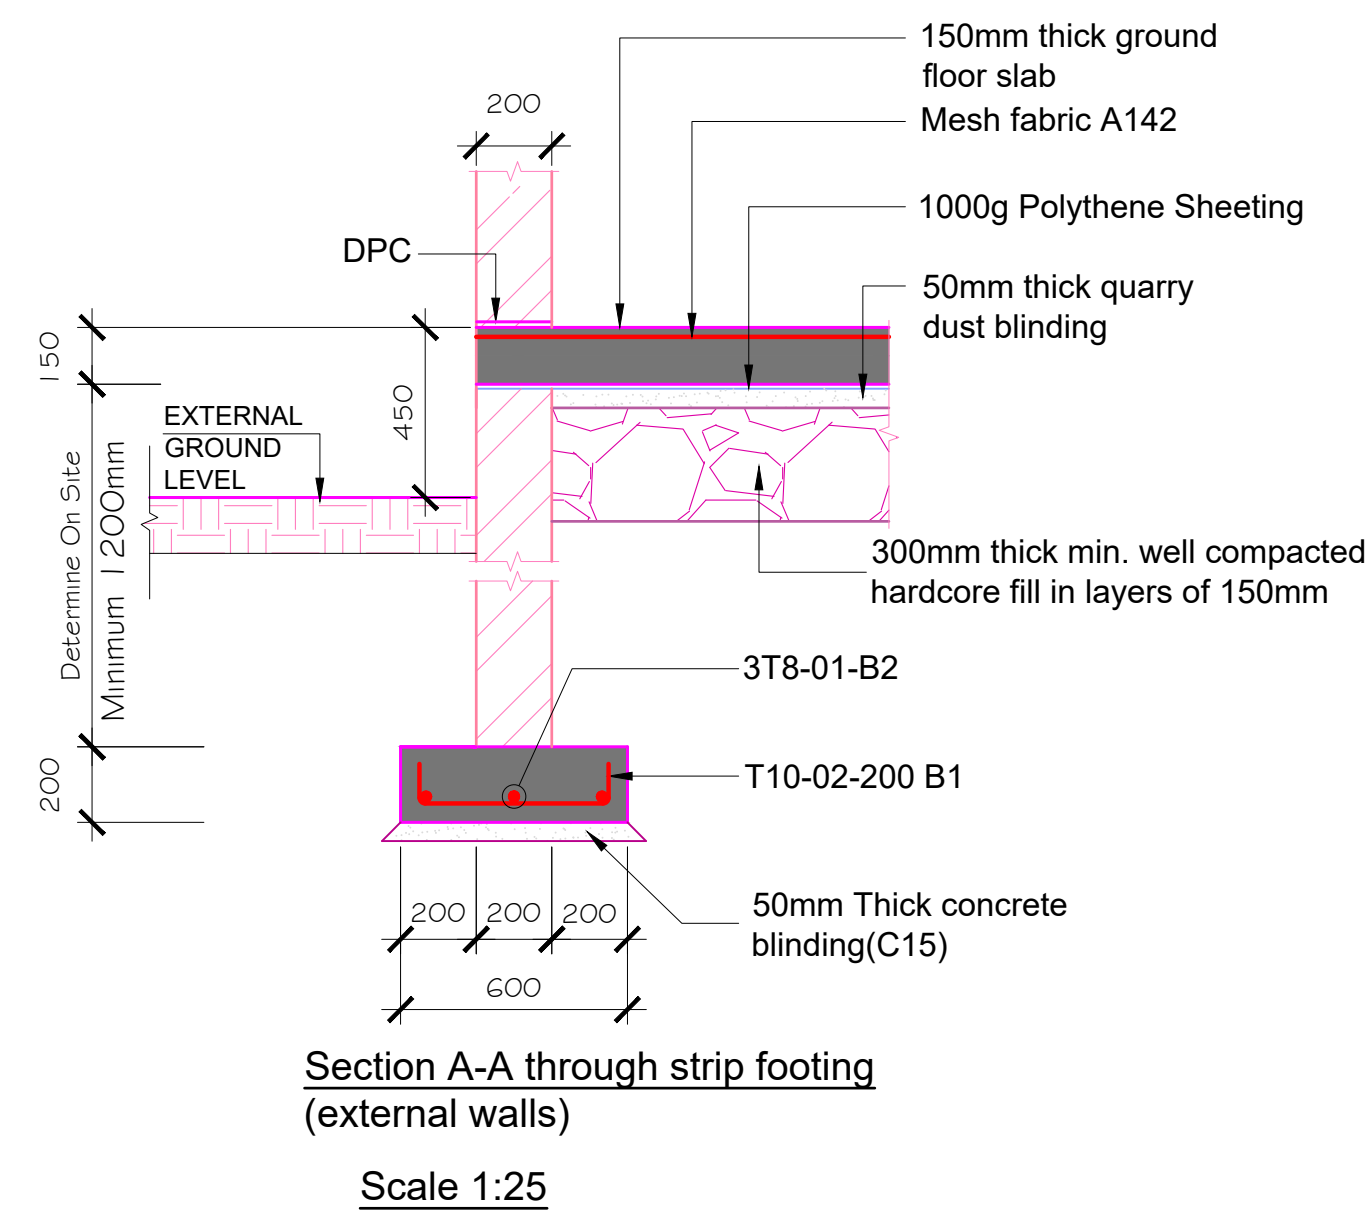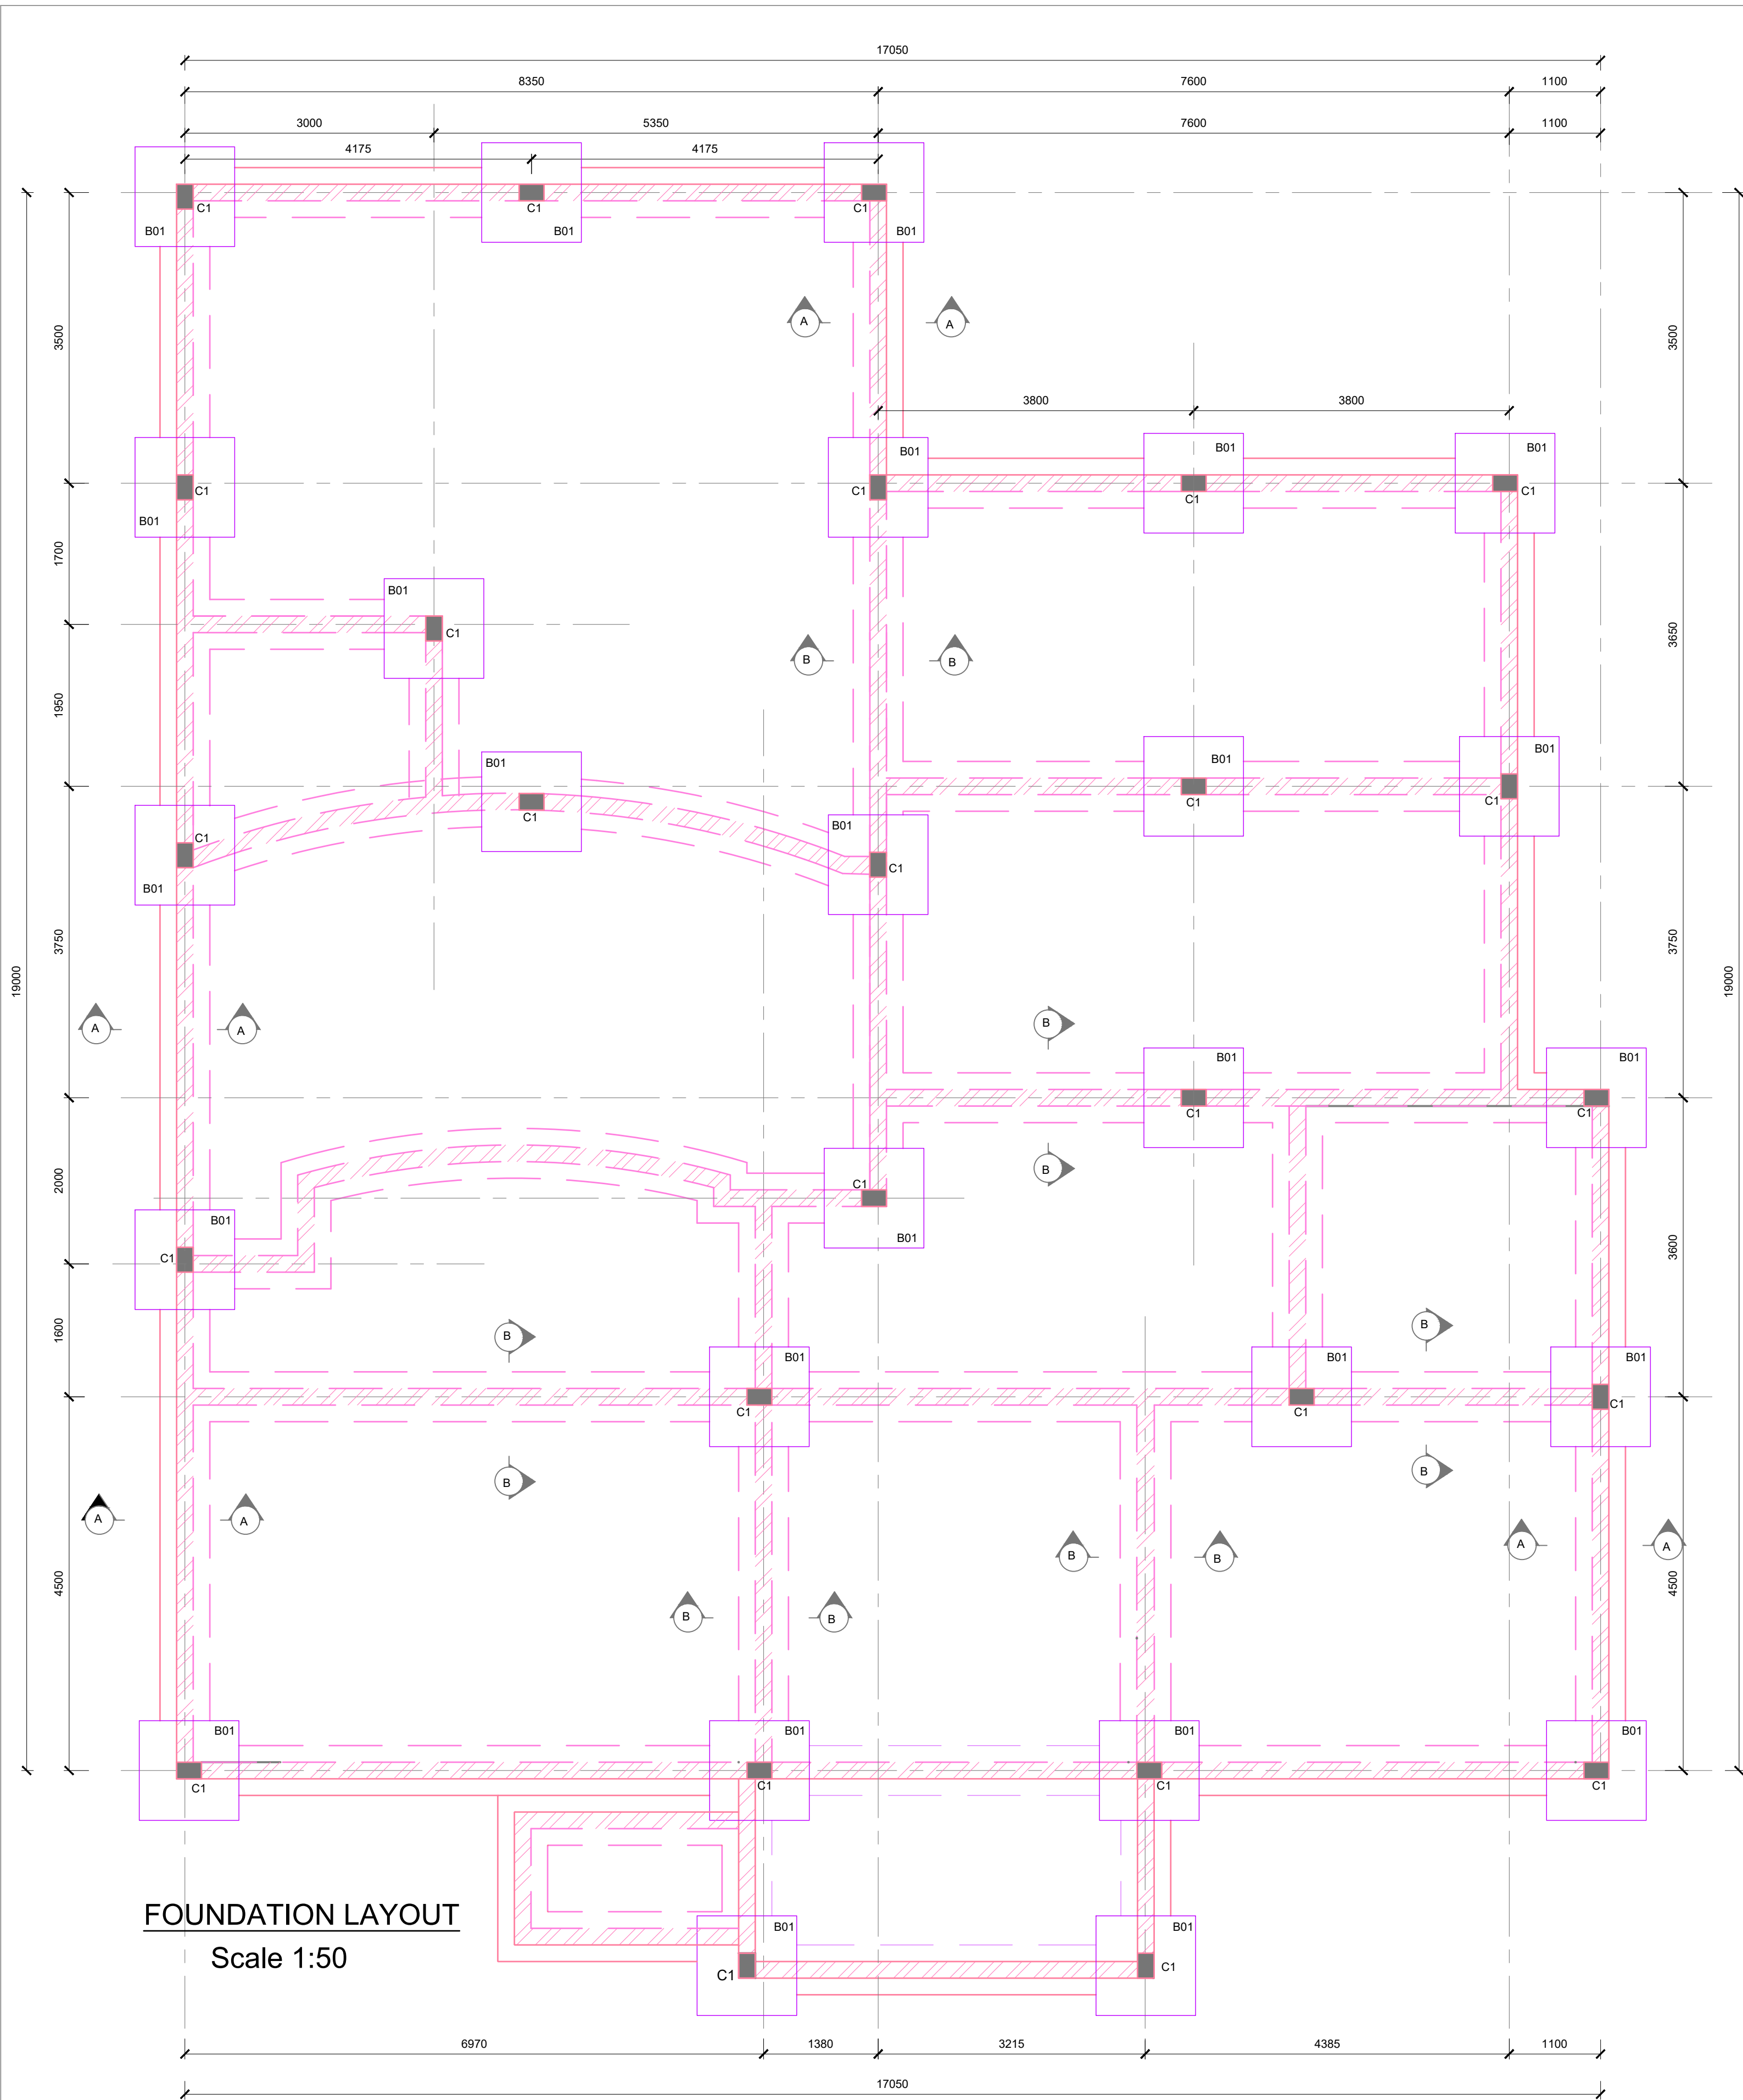


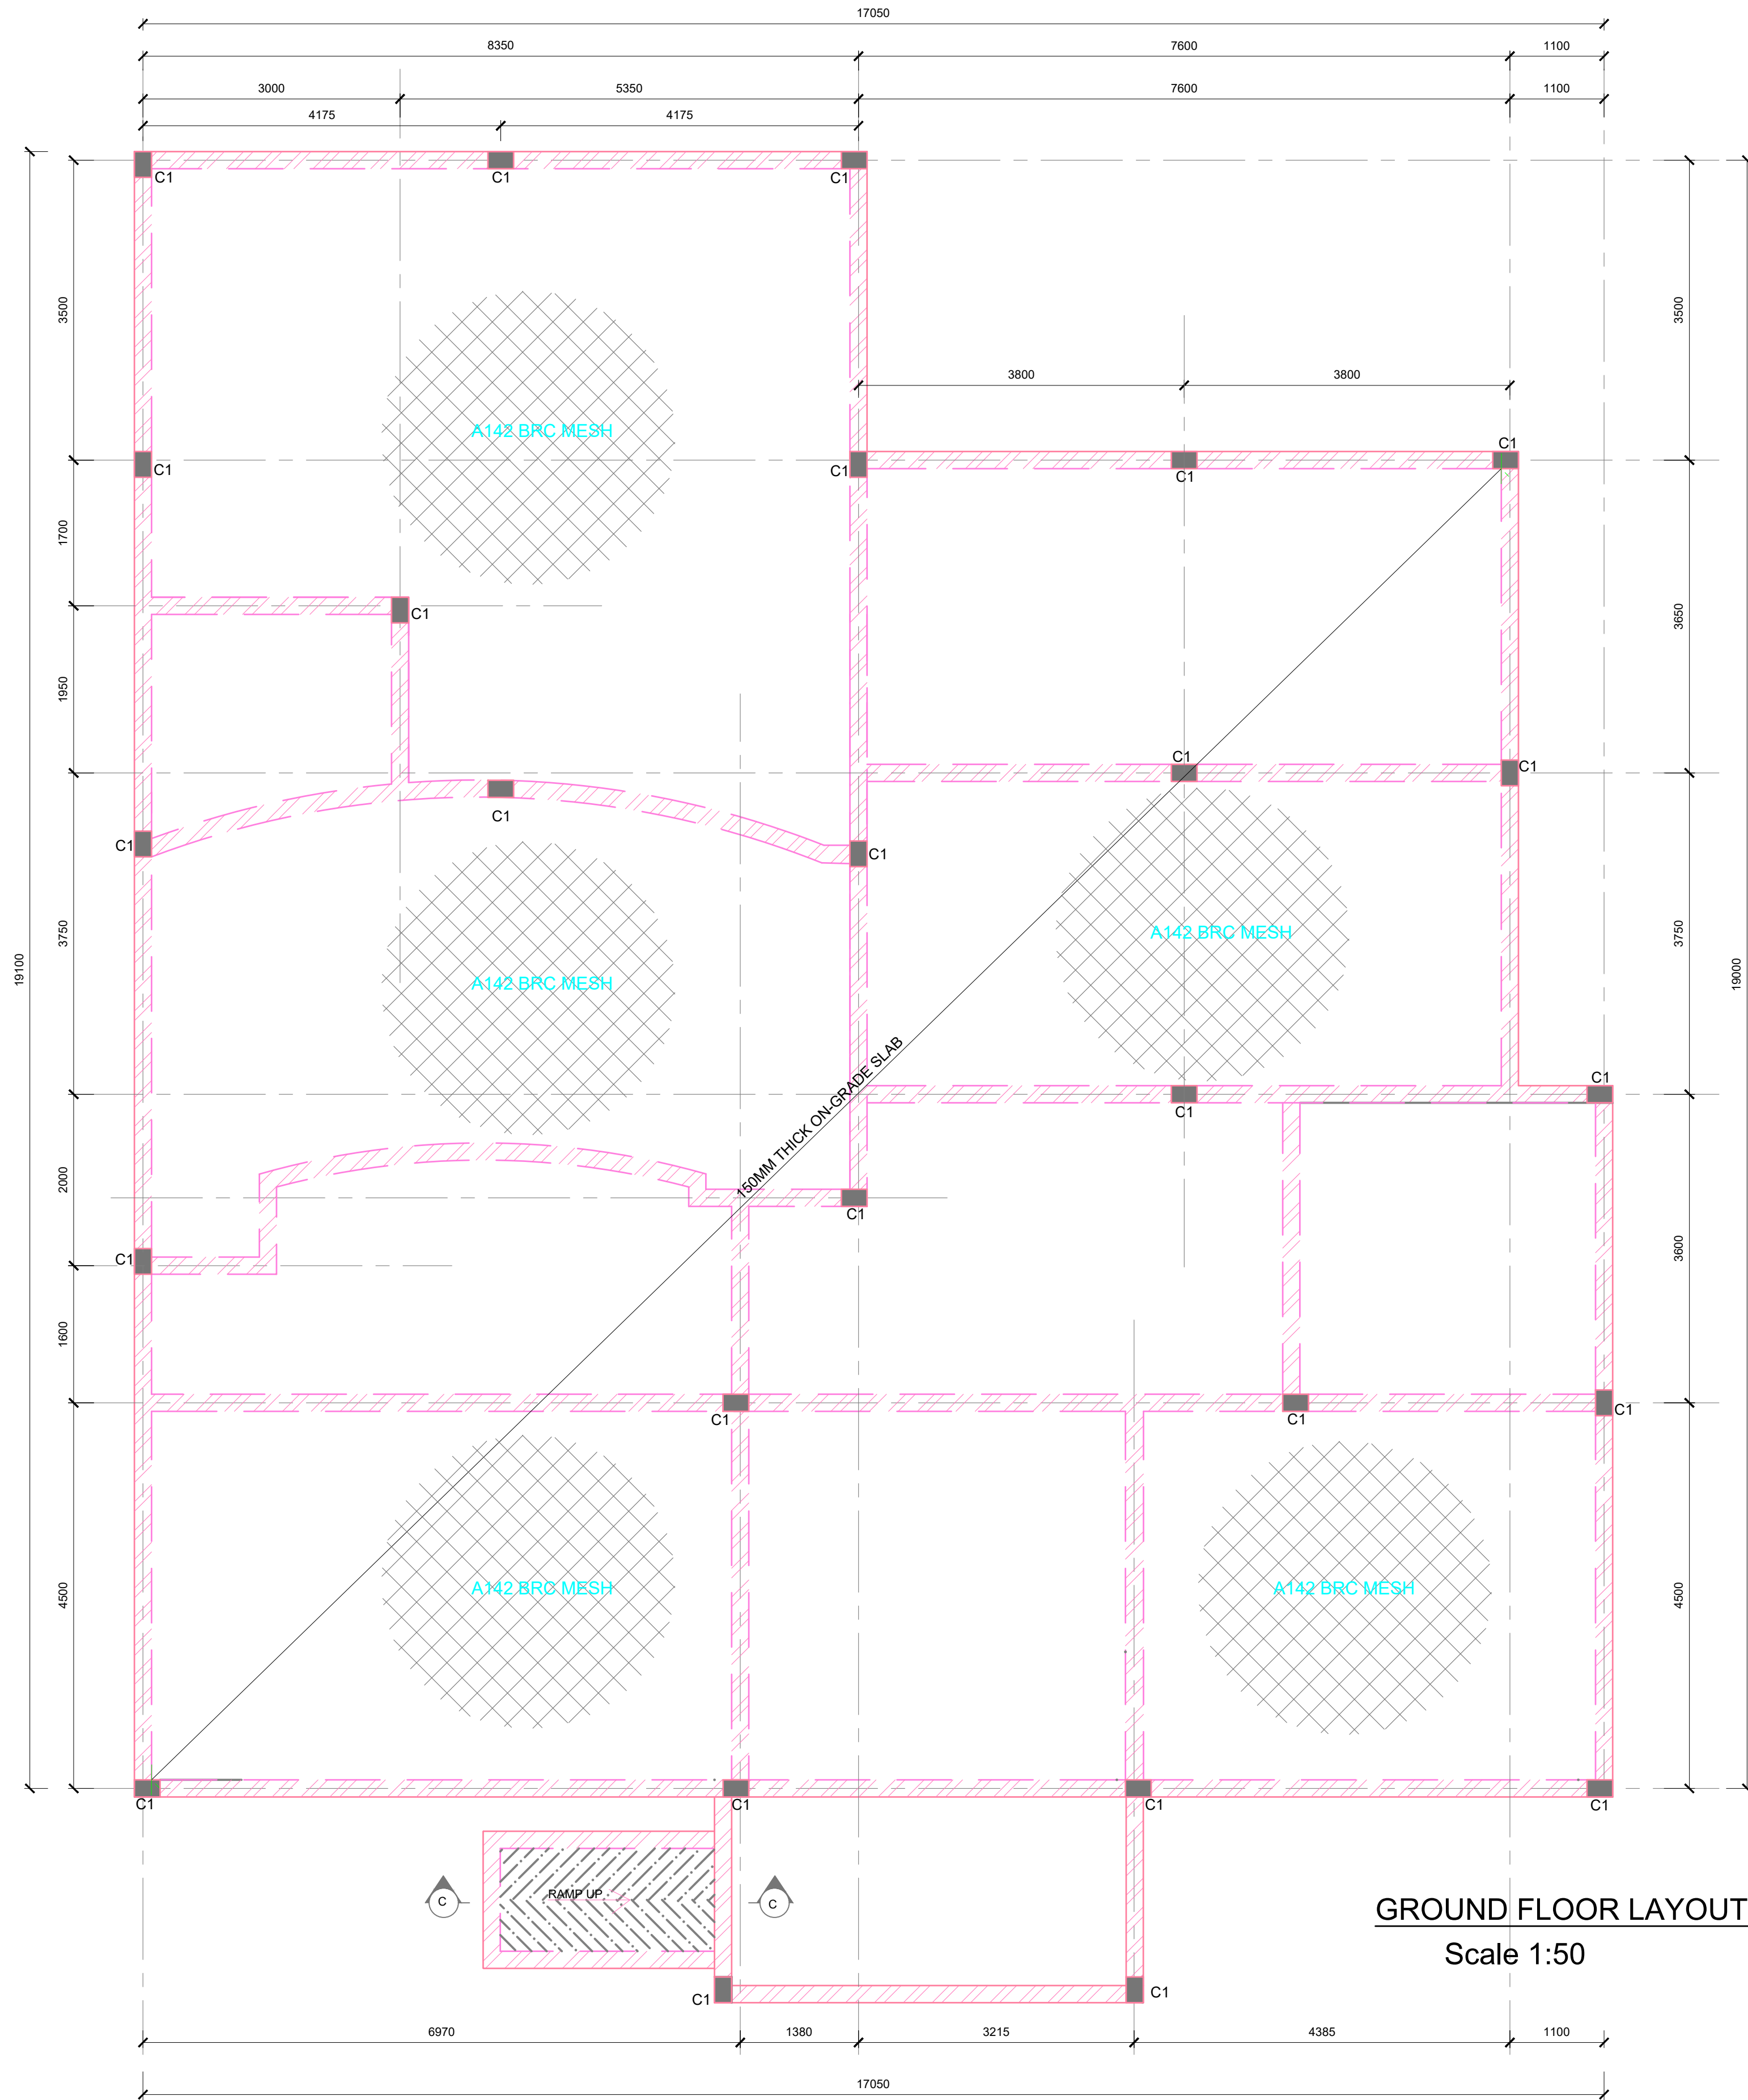

GROUND FLOOR LAYOUT
Scale 1:50

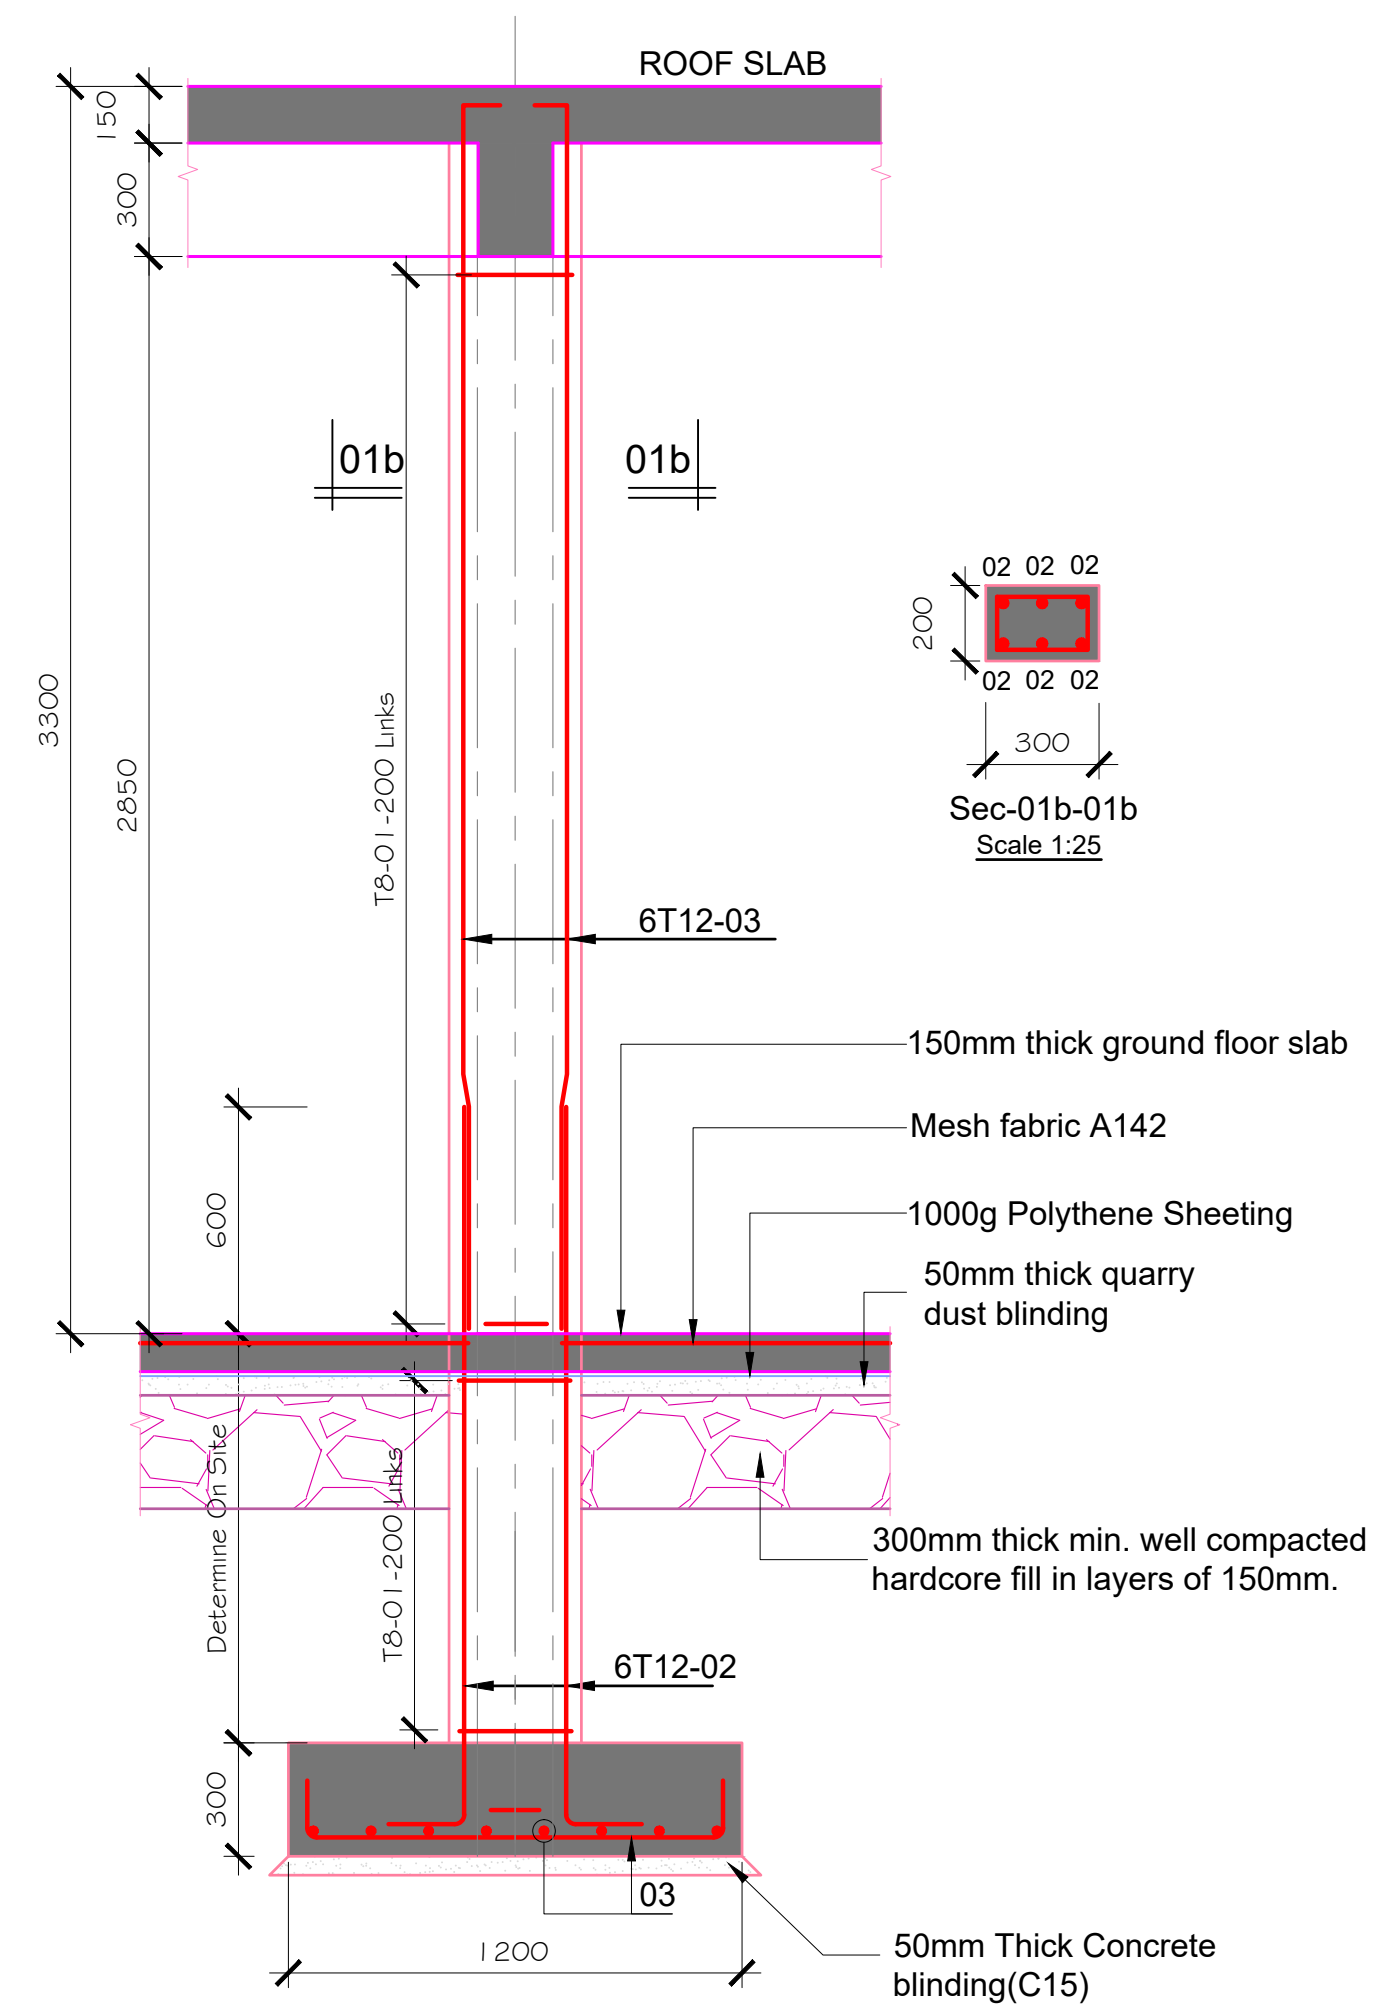

Section B01 - B01
Scale 1:25

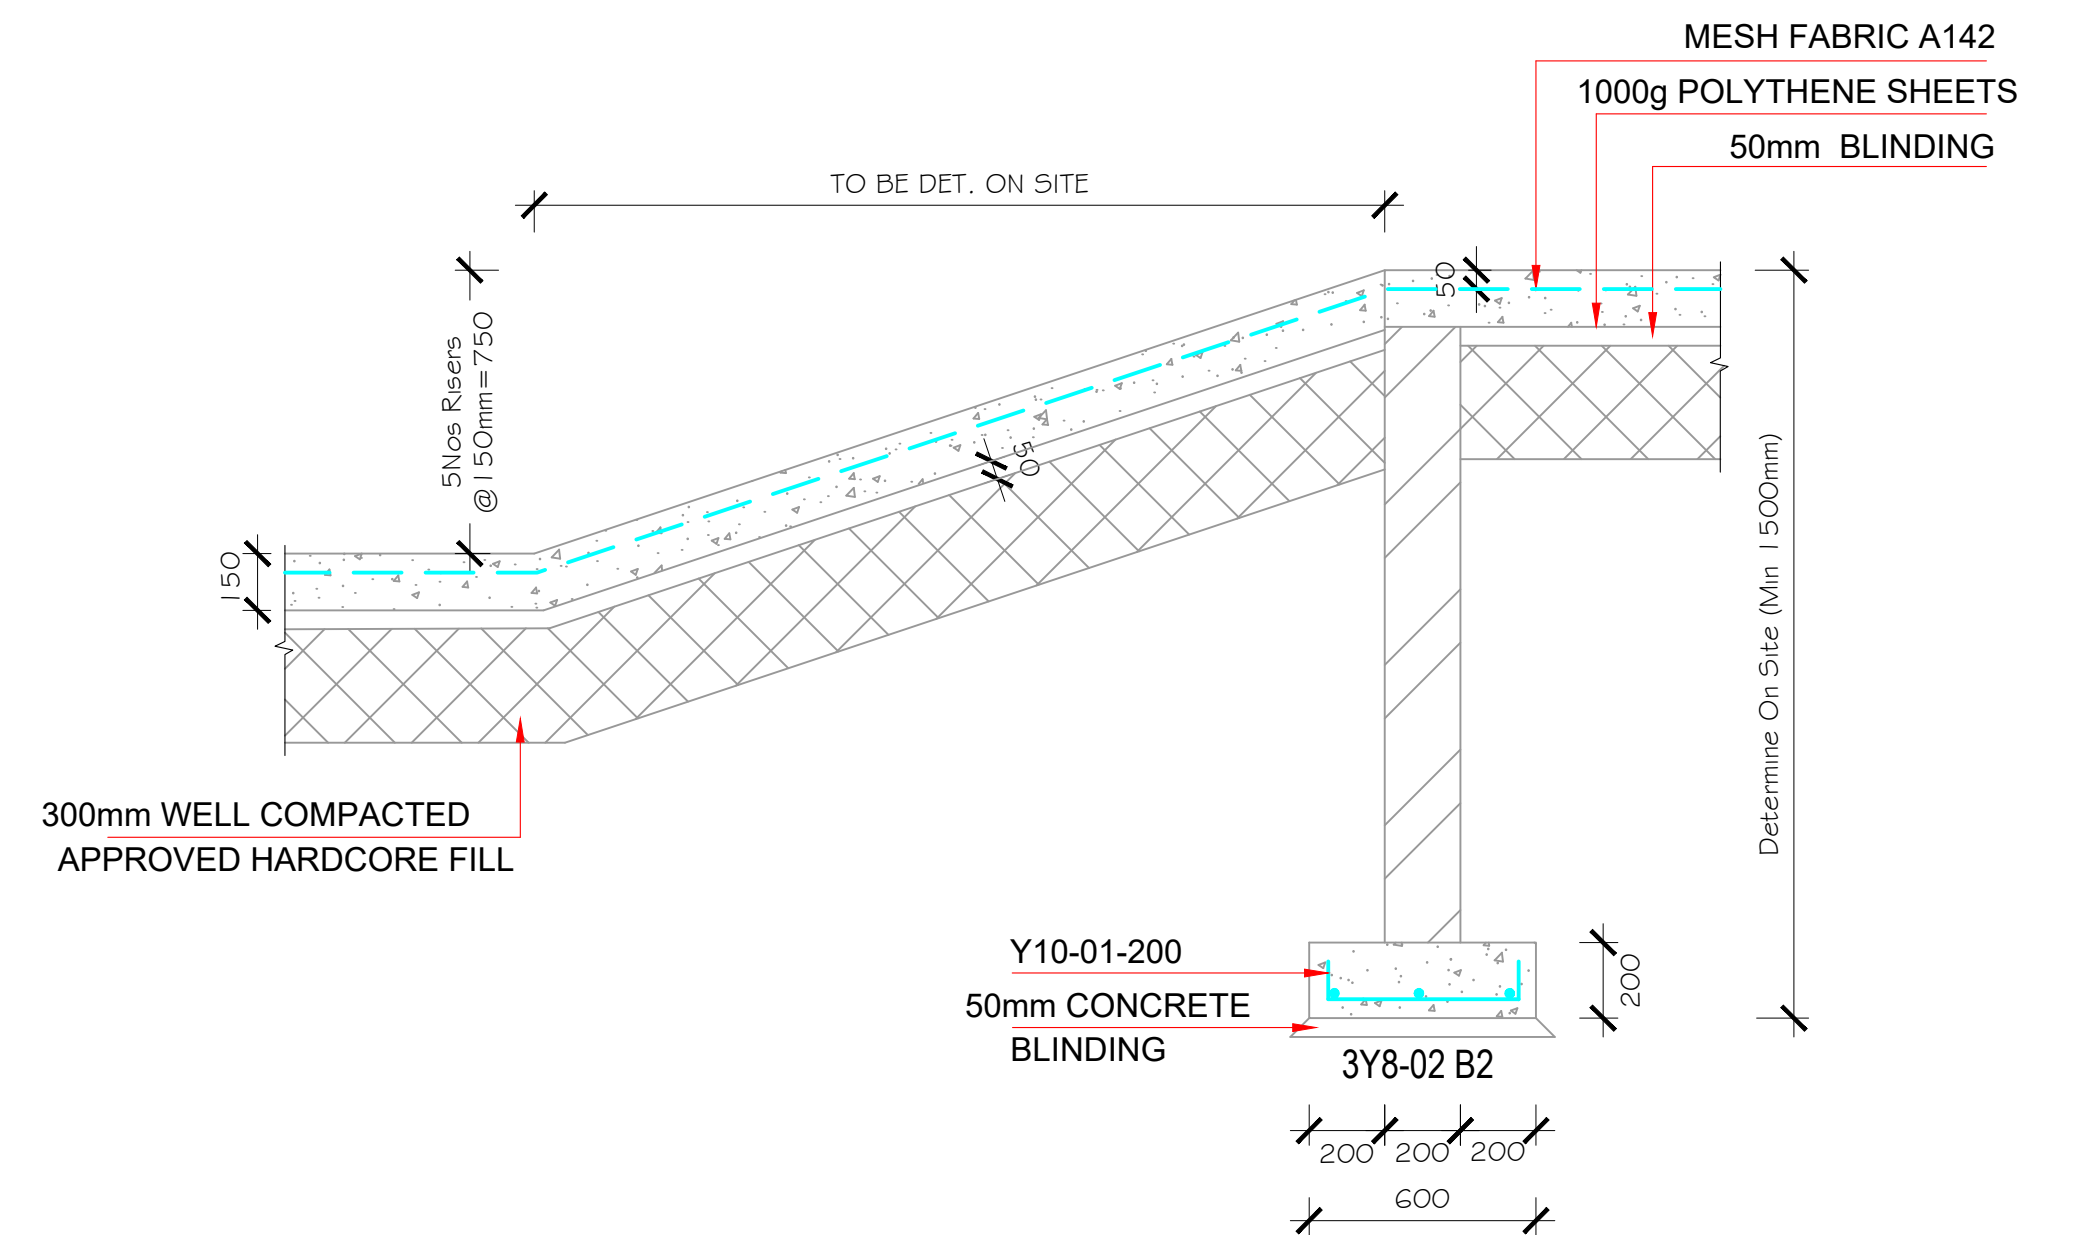

RAMP SECTION C-C
SCALE 1:25

Civil Engineer:

FCU
Frame Consultants Ltd
P.O. BOX 58624-00200, NAIROBI.
TEL: 2213744, 2251505, 0720523850
E-mail: info@frameconsultants.com

Client:

ATHI WATER WORKS
ATHI WATER WORK DEVELOPMENT AGENCY
P.O BOX 45283 - 00100 NAIROBI,
Tel: +254 (0) 274292/3
Email: info@awwda.go.ke

Project

NAIROBI RIVERS BASIN REHABILITATION AND RESTORATION PROGRAMME: SEWERAGE IMPROVEMENT PROJECT PHASE II (NaRSIP II)
REHABILITATION AND EXPANSION OF DANDORA ESTATE SEWERAGE TREATMENT PLANT (DESTP) INLET WORKS

Drawing Title

DANDORA ESTATE SEWAGE TREATMENT PLANT (DESTP)
GROUND FLOOR LAYOUT

NOTES

1. Read this drawing in conjunction with relevant G.A., Services and Architectural drawings. Any discrepancy to be reported to the Engineer.
2. All dimensions are in millimetres unless specified otherwise.
3. All levels are indicated in mm unless specified otherwise.
4. All structural concrete to be Class 25 unless stated otherwise.

5. Minimum cover to all reinforcement to be:

- Stairs, Slabs & Walls = 20mm
- Beams (main bars) = 30mm
- Columns (main bars) = 40mm
- Foundations = 50mm

6. All high tensile (Y) and mild steel (R) bars to be in accordance with BS 4449 and fabric mesh to be made from cold worked steel bars in accordance with BS 4483.


7. Maximum tolerance on concrete cover is +/- 5mm.

8. Minimum laps to all bars to be 550 unless stated otherwise.


9. Assumed Bearing Pressure taken to be 150 KN/m².

10. Nominal aggregate size to be 20mm.


REV	REVISIONS				APPROVED	Designed by		Drawn by	
	BY	CHECKED	DATE	DATE		D.K.	D.K.	D.K.	D.K.
D	CHECKED								
C	CHECKED								
B	CHECKED								
A	CHECKED								
						Job No.	FC/CE108	ACAD File:	CE108_CR_02
						STATUS	DRG No.	FC/CE108/CR/02	REV

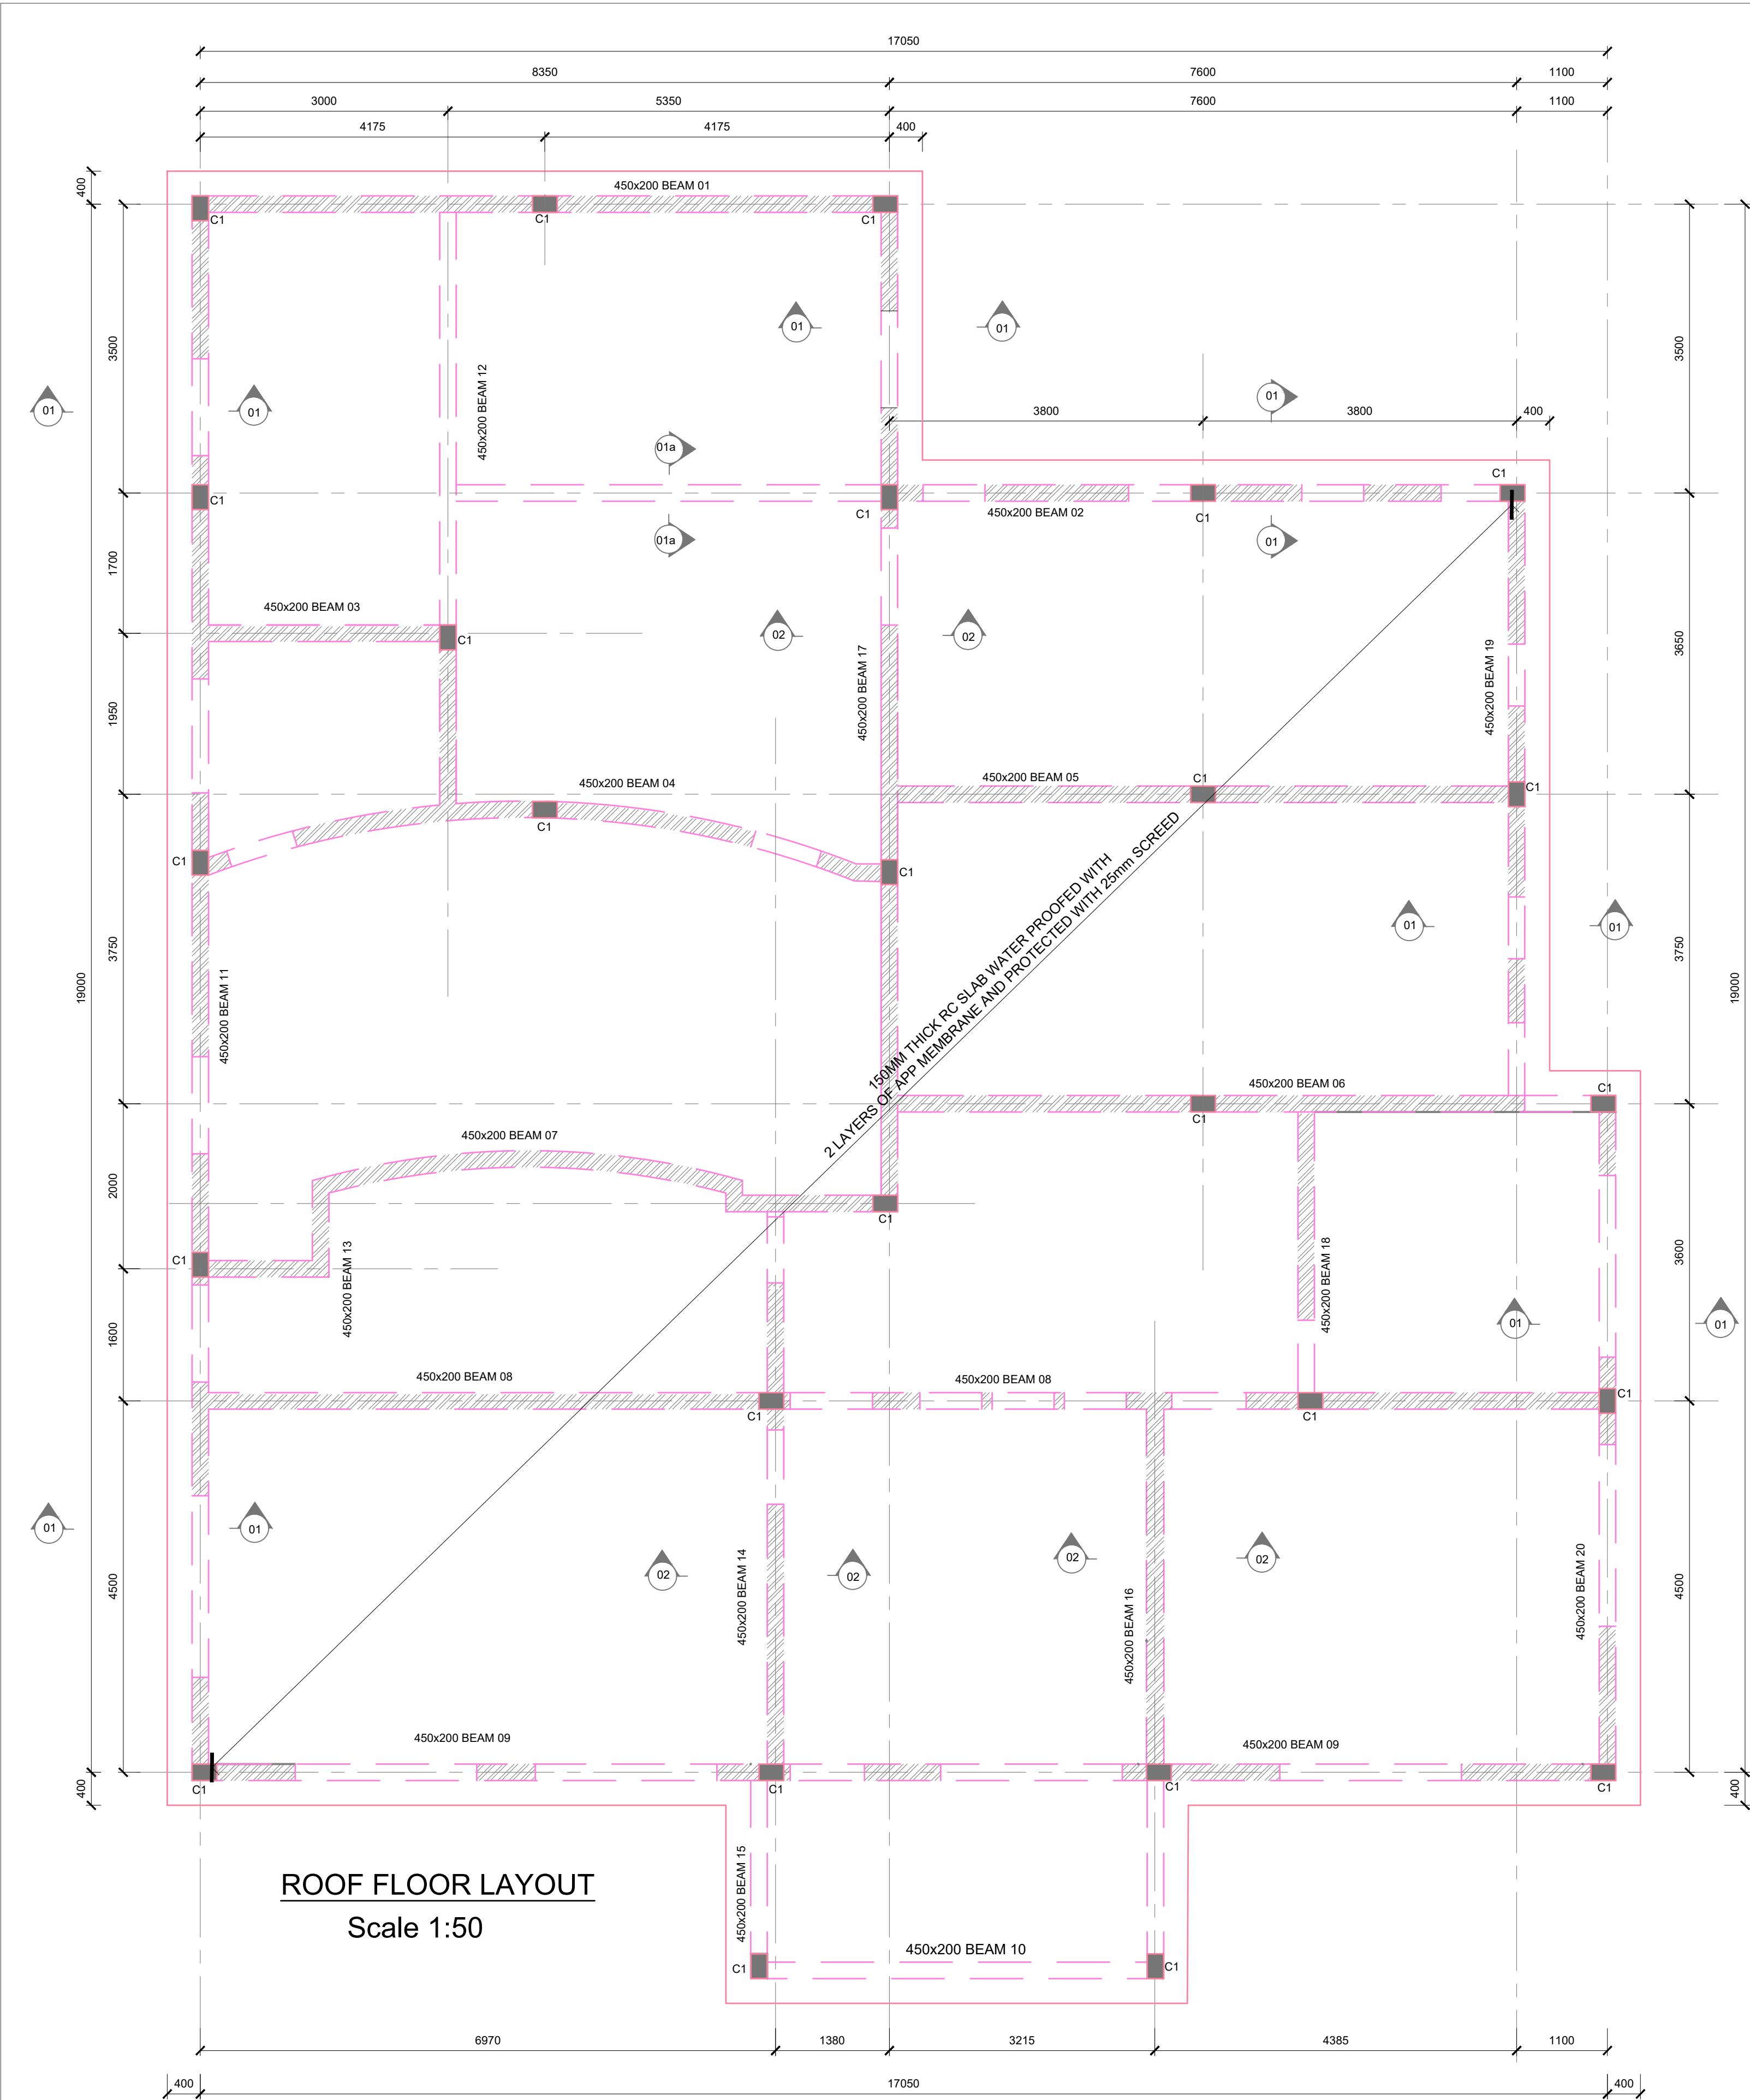


ROOF FLOOR LAYOUT
Scale 1:50

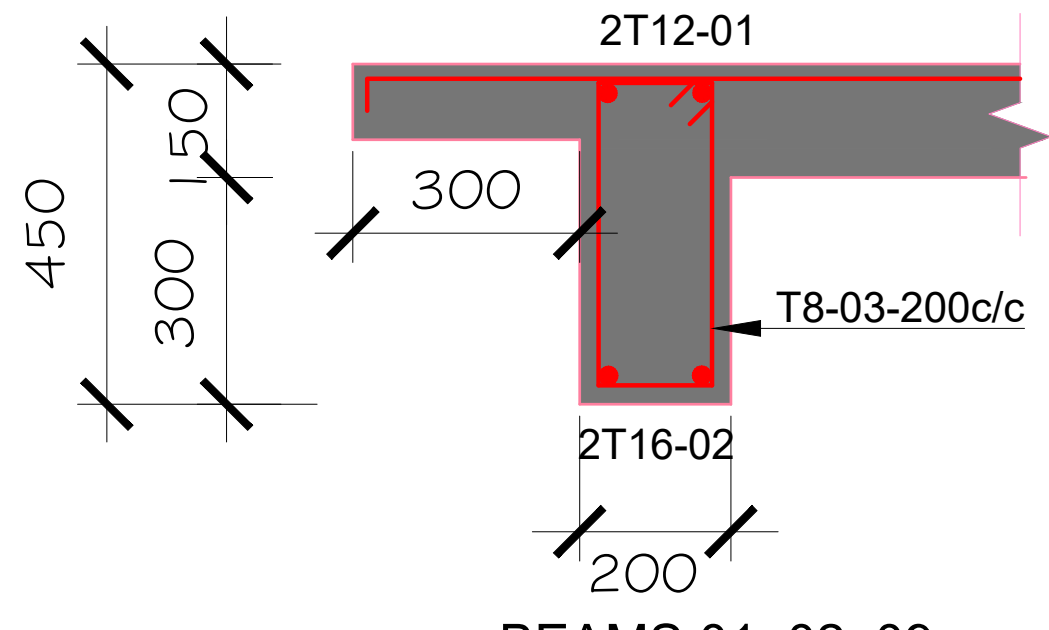


BEAMS 01, 02, 09,
11, 19, 20 SECTION
SCALE 1:25

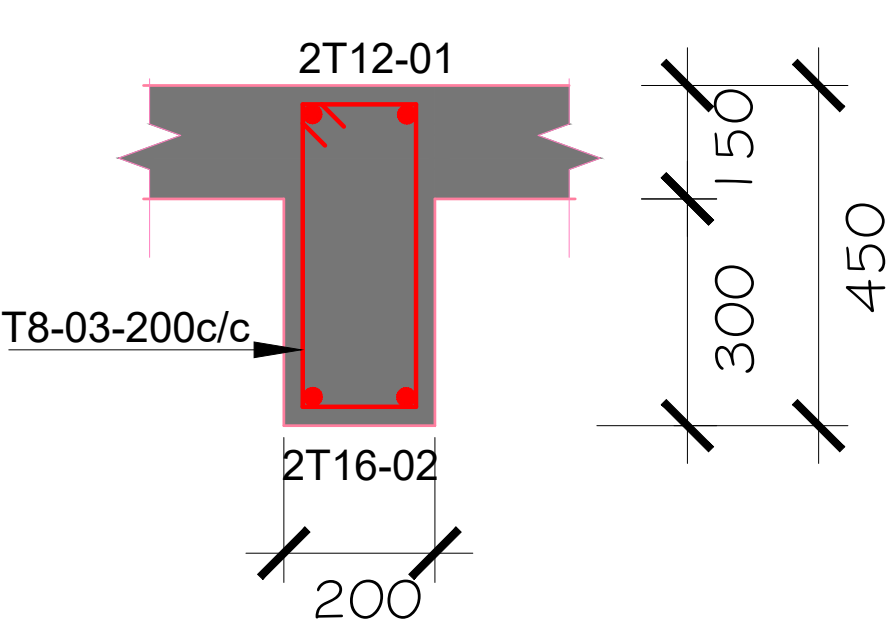


BEAMS 03, 04, 05, 06 07,
08 SECTION
SCALE 1:25

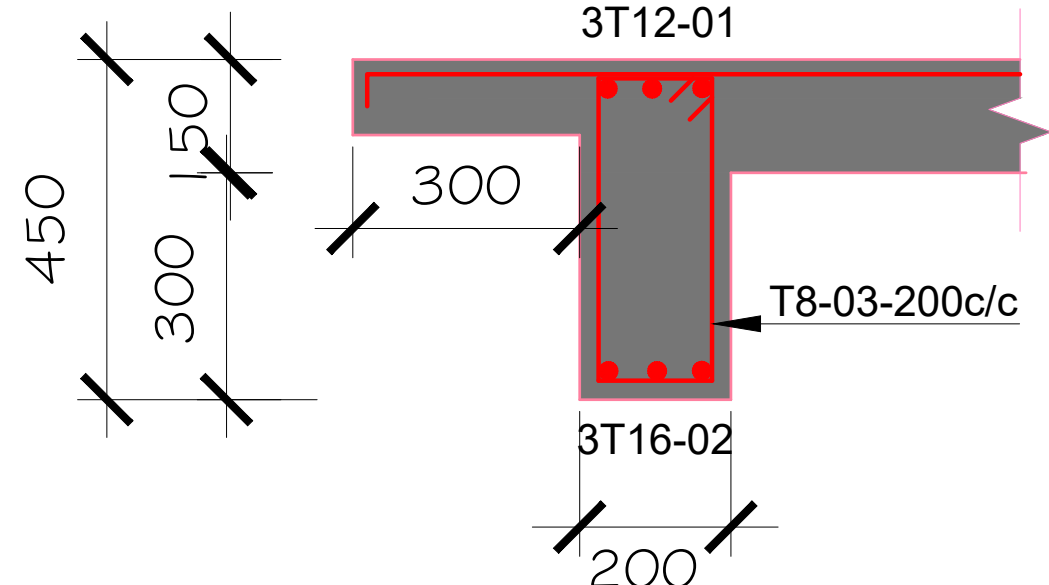


BEAM 10 SECTION
SCALE 1:25

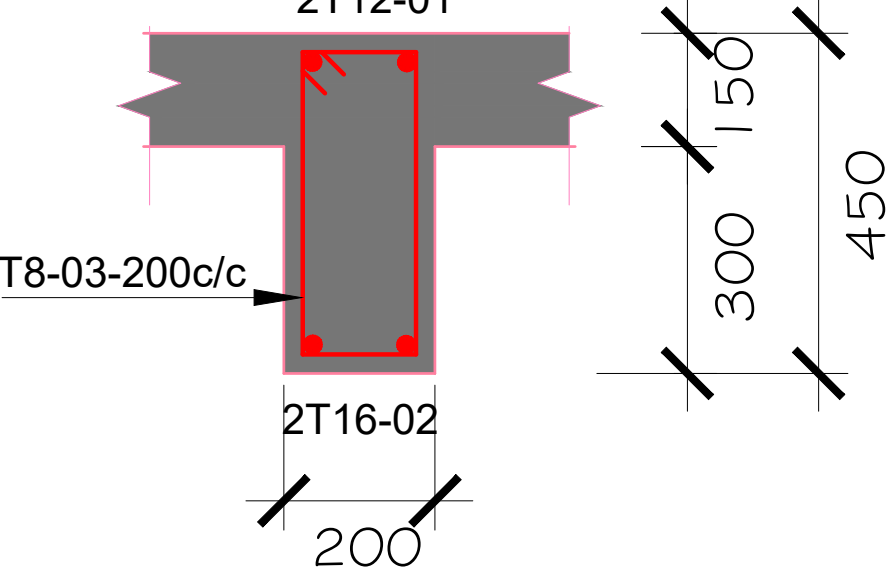


BEAMS 13, 14, 15 16, 17,
18 SECTION
SCALE 1:25

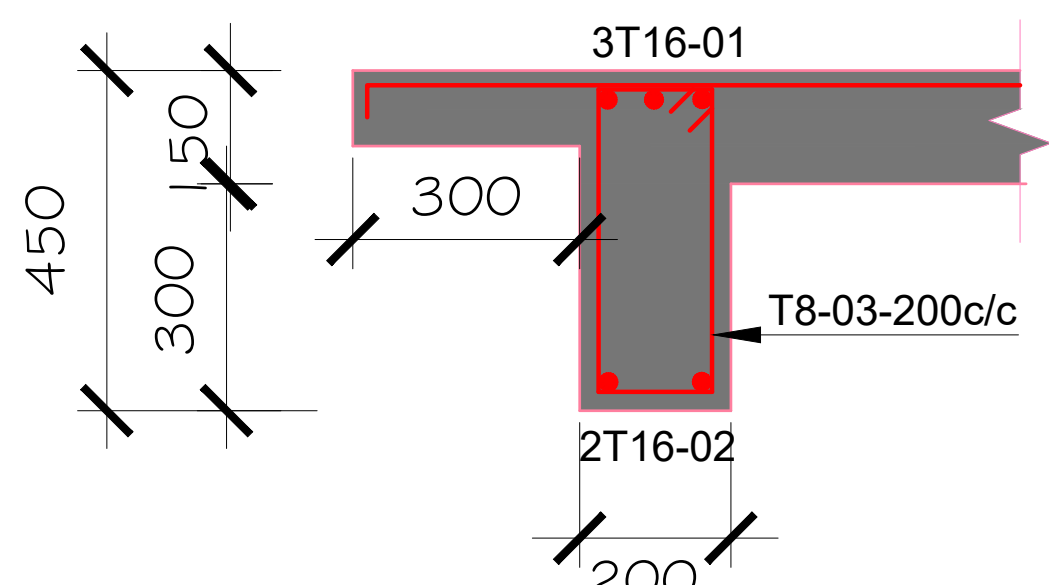


BEAM 02
SECTION 01-01
SCALE 1:25

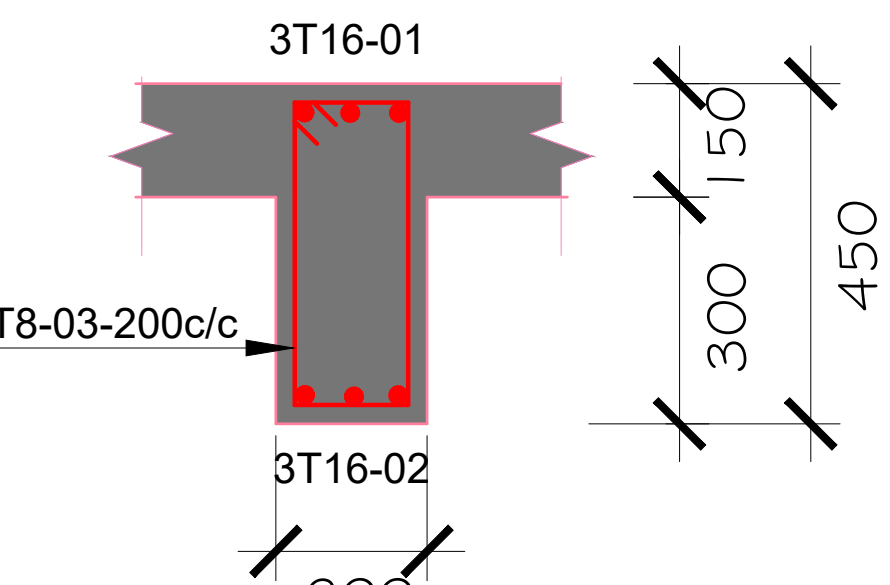

BEAM 02
SECTION 01a-01a
SCALE 1:25

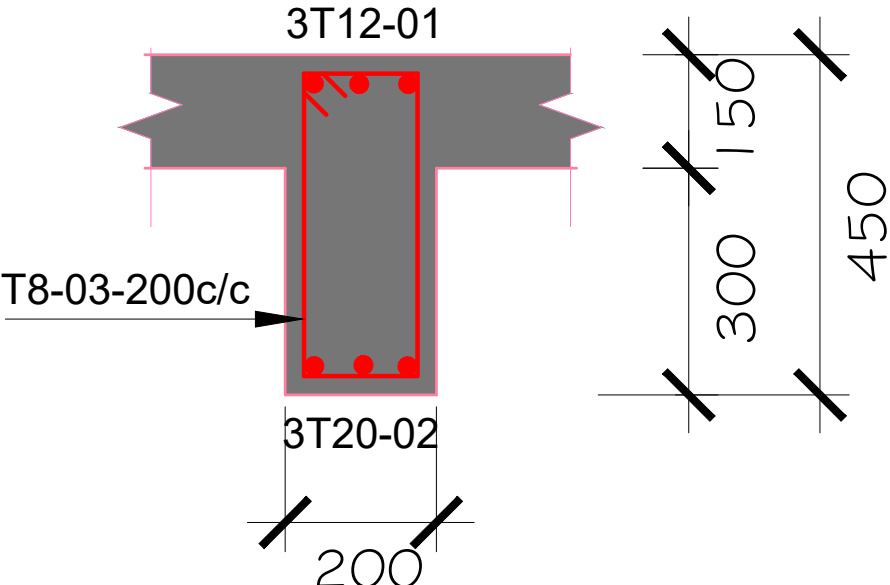

BEAMS 12 SECTION
SCALE 1:25

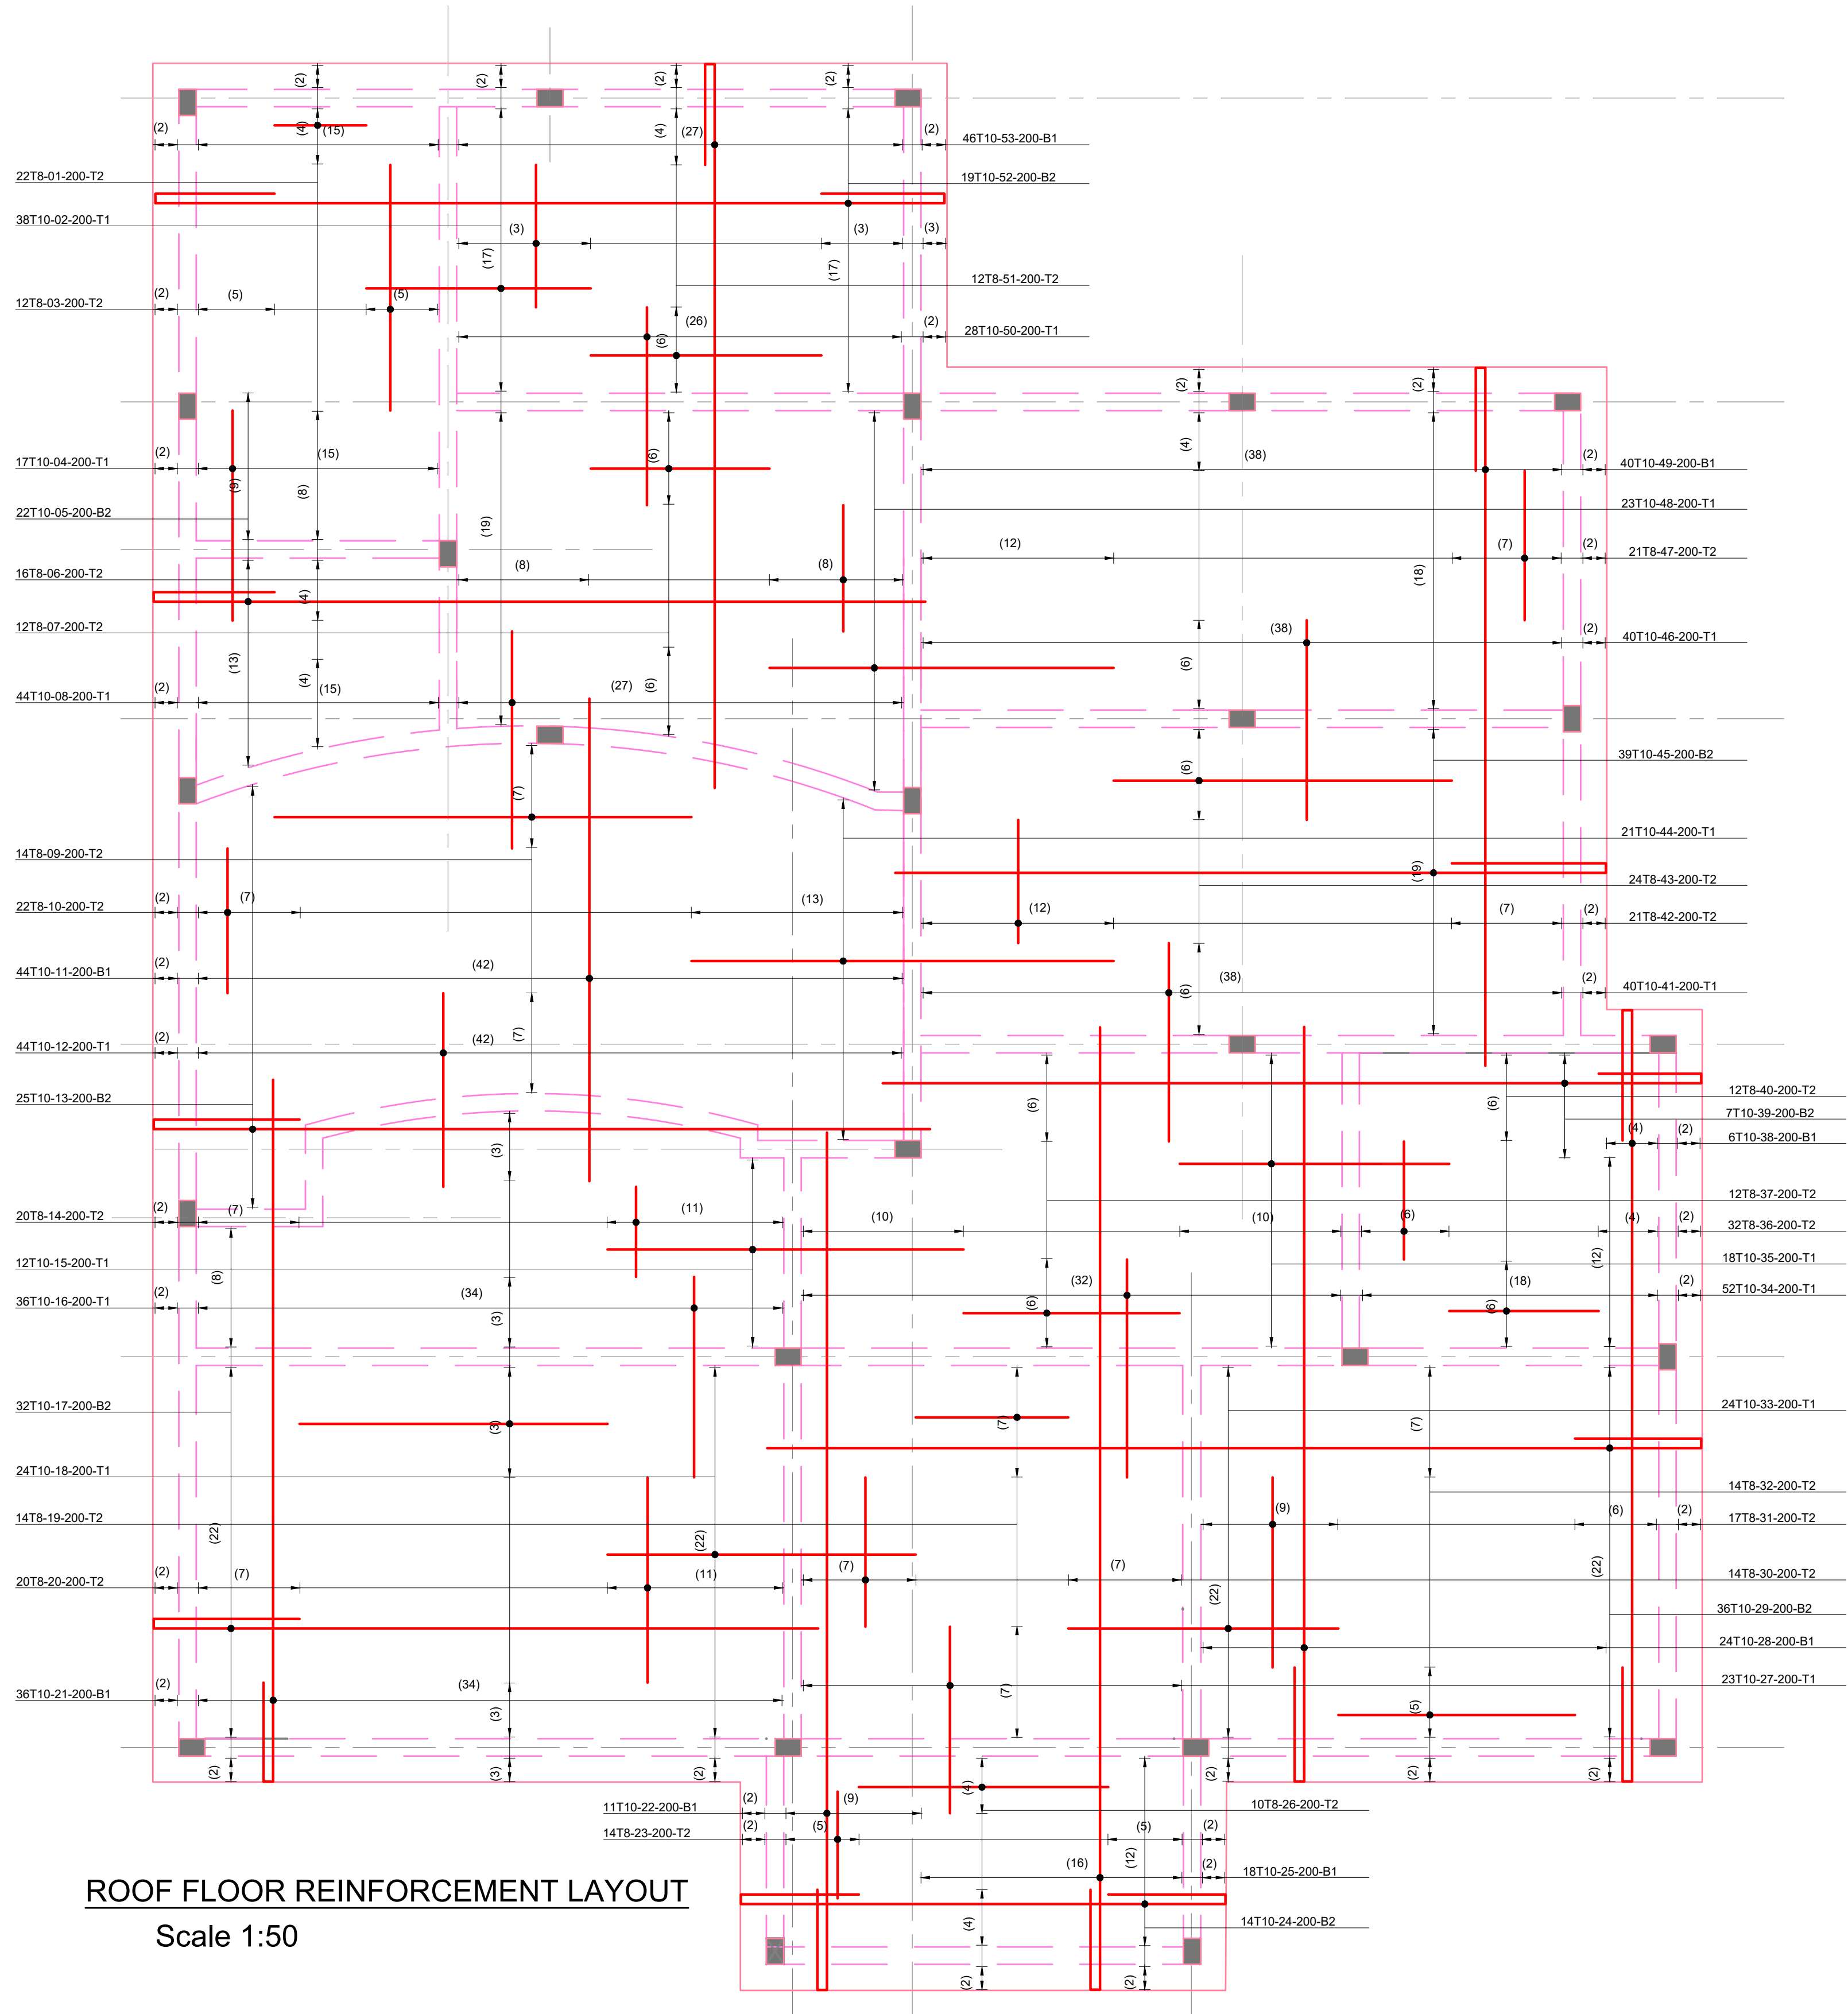

ROOF FLOOR REINFORCEMENT LAYOUT
Scale 1:50

Civil Engineer:

FCU
Frame Consultants Ltd
P.O. BOX 58624-00200, NAIROBI.
TEL: 2213744, 2251505, 0720523850
E-mail: info@frameconsultants.com

Client:

ATHI WATER WORKS
ATHI WATER WORK DEVELOPMENT AGENCY
P.O BOX 45283 - 00100 NAIROBI,
Tel: +254 (0) 274292/3
Email: info@awwda.go.ke

Project

NAIROBI RIVERS BASIN REHABILITATION AND RESTORATION PROGRAMME: SEWERAGE IMPROVEMENT PROJECT PHASE II (NaRSIP II)
REHABILITATION AND EXPANSION OF DANDORA ESTATE SEWAGE TREATMENT PLANT (DESTP) INLET WORKS

Drawing Title

DANDORA ESTATE SEWAGE TREATMENT PLANT (DESTP)
ROOF FLOOR LAYOUT

NOTES

1. Read this drawing in conjunction with relevant G.A., Services and Architectural drawings. Any discrepancy to be reported to the Engineer.
2. All dimensions are in millimetres unless specified otherwise.
3. All levels are indicated in mm unless specified otherwise.
4. All structural concrete to be Class 25 unless stated otherwise.

5. Minimum cover to all reinforcement to be:

- Stairs, Slabs & Walls = 20mm
- Beams (main bars) = 30mm
- Columns (main bars) = 40mm
- Foundations = 50mm

6. All high tensile (Y) and mild steel (R) bars to be in accordance with BS 4449 and fabric mesh to be made from cold worked steel bars in accordance with BS 4483.

7. Maximum tolerance on concrete cover is +/- 5mm.


8. Minimum laps to all bars to be 550 unless stated otherwise.

9. Assumed Bearing Pressure taken to be 150 KN/m².


10. Nominal aggregate size to be 20mm.

REV	REVISIONS				SIGN	DATE	APPROVED	Designed by		Drawn by	
	BY	CHECKED	BY	CHECKED				D.K.	D.K.		
D								Checked by	FMK	Approved by	FMK
C								Scales	1:50	Date:	OCTOBER 2021
B								Job No.	FC/CE108	ACAD File:	CE108_CR_04
A								STATUS	DRG No.	FC/CE108/CR/04	REV


SITE ANCILLARY WORKS

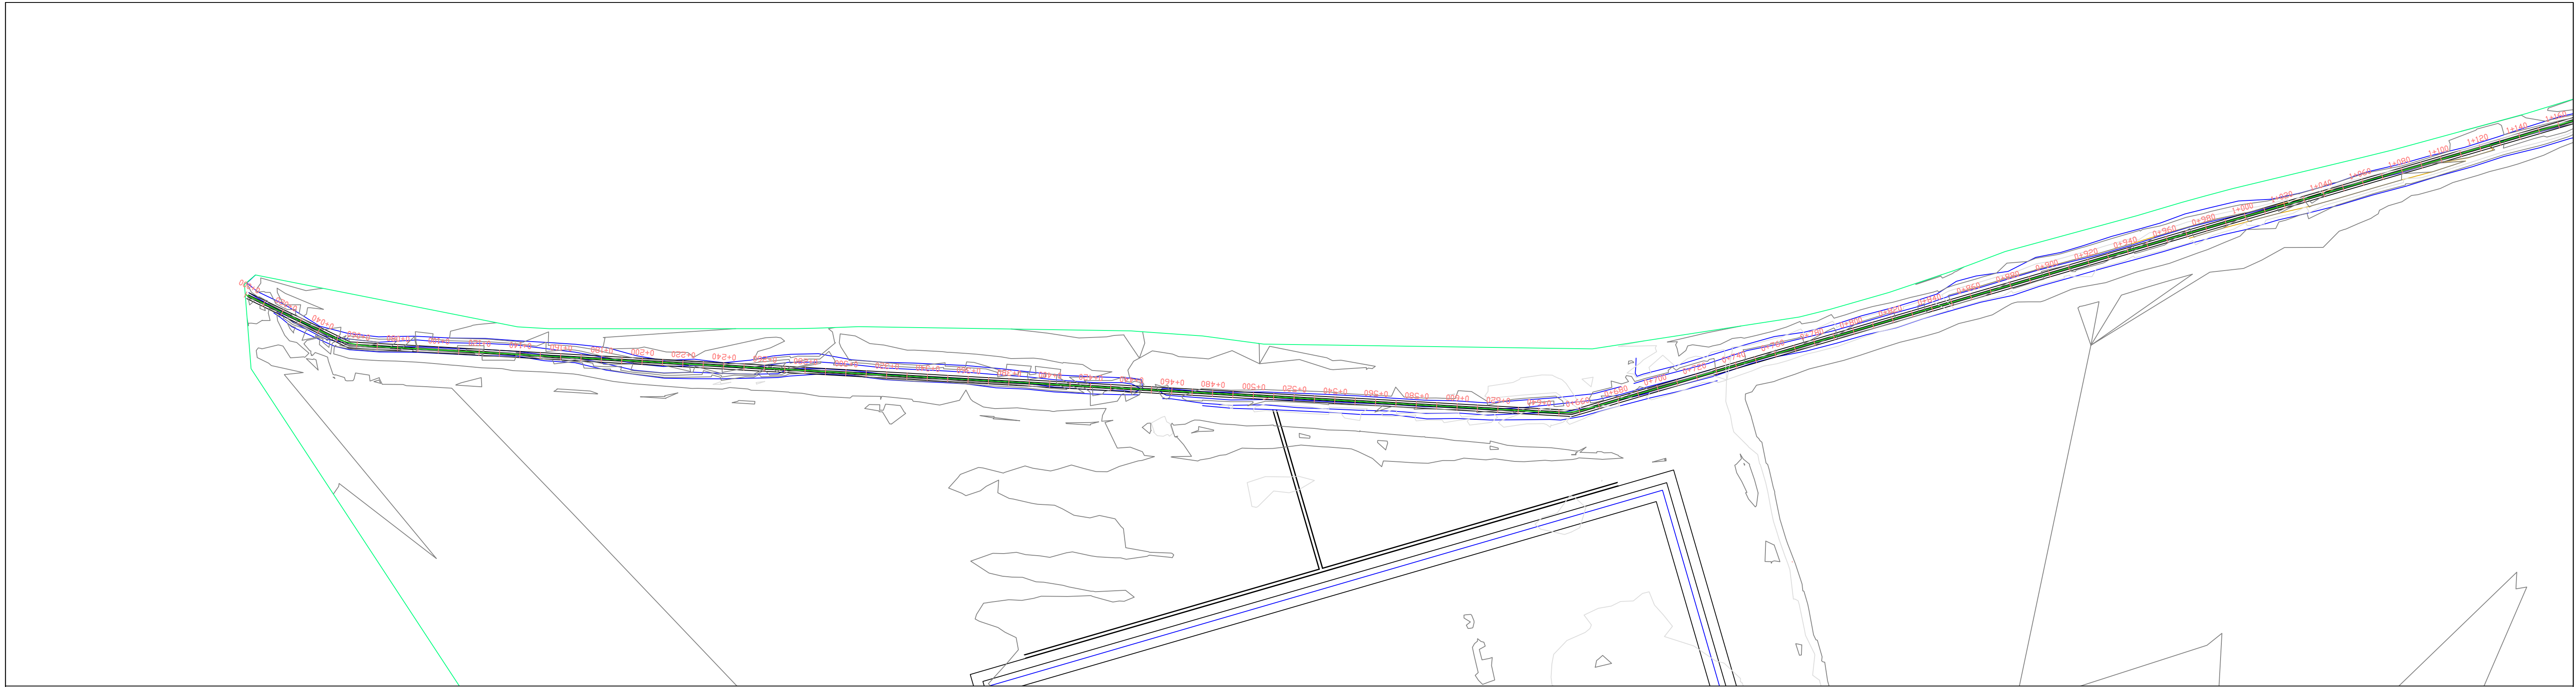


STORMWATER DRAINAGE

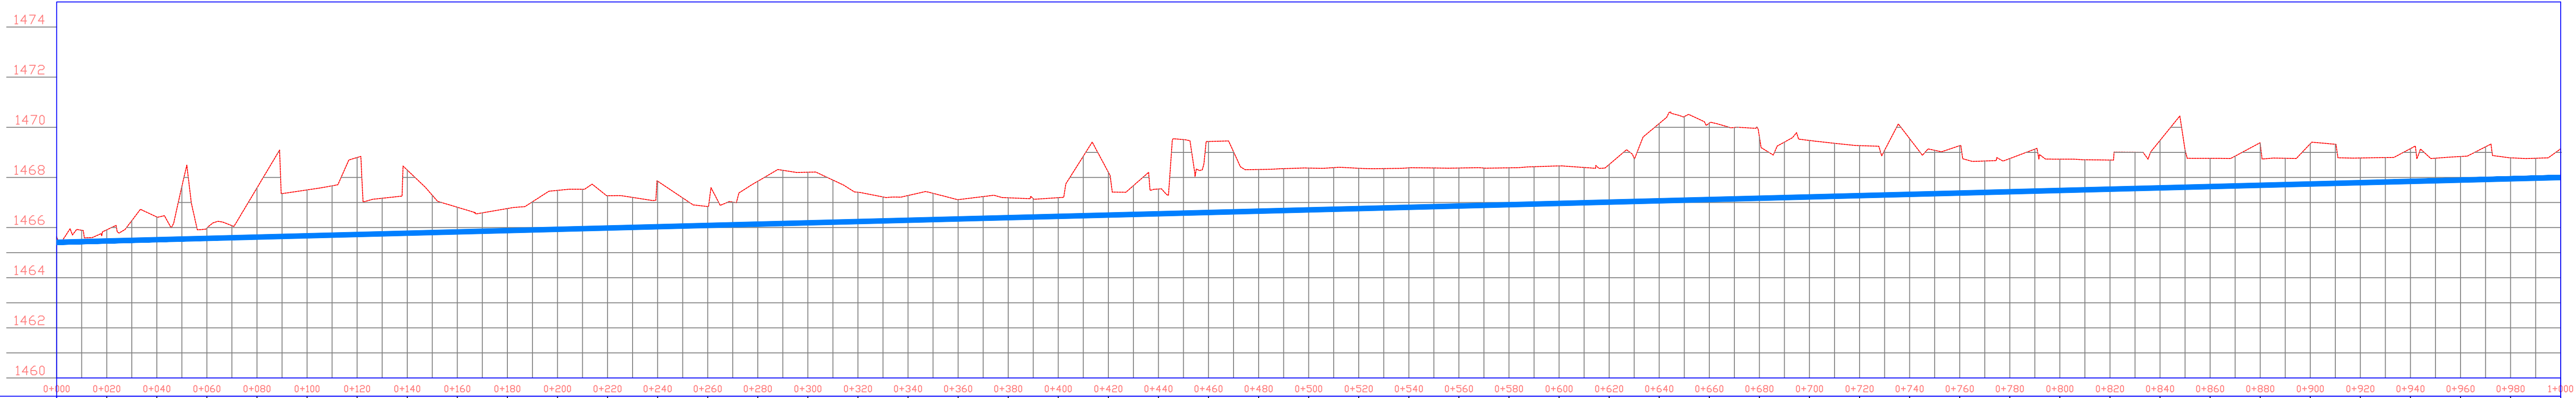


EXISTING GROUND LEVEL, m	1465.635	1465.911	1466.423	1465.973	1467.583	1467.502	1468.795	1468.296	1466.811	1466.759	1467.484	1467.270	1467.852	1466.033	1467.852	1466.638	1467.848	1468.208	1467.409	1467.279	1467.113	1467.188	1467.193	1468.209	1467.538	1466.435	1468.317	1466.374	1468.363	1468.376	1468.459	1468.315	1470.151	1470.168	1469.621	1469.475	1469.269	1467.274	1469.348	1469.267	1468.753	1468.730	1468.693	1469.477	1468.761	1469.353	1469.345	1468.776	1469.149	1468.835	1468.783	1469.142
TRENCH INVERT LEVEL, m	1465.413	1465.465	1465.516	1465.568	1465.620	1465.671	1465.723	1465.775	1465.827	1465.878	1465.930	1465.982	1466.033	1466.085	1466.137	1466.188	1466.240	1466.292	1466.343	1466.395	1466.447	1466.498	1466.550	1466.602	1466.654	1466.705	1466.757	1466.809	1466.860	1466.912	1466.964	1467.015	1467.067	1467.119	1467.170	1467.222	1467.274	1467.326	1467.377	1467.429	1467.481	1467.532	1467.584	1467.636	1467.687	1467.739	1467.791	1467.842	1467.894	1467.946	1467.997	
EXCAVATION DEPTH, m	0.22	0.45	0.91	0.41	1.96	1.83	3.07	2.52	0.98	0.88	1.55	1.29	1.82	0.75	1.71	2.02	1.17	0.99	0.77	0.79	0.75	1.71	0.99	2.83	1.66	1.67	1.61	1.57	1.52	1.47	1.50	1.50	3.08	3.05	2.45	2.25	1.99	2.22	1.89	1.32	1.25	1.16	1.89	1.13	1.67	1.61	0.99	1.31	0.94	0.84	1.14	

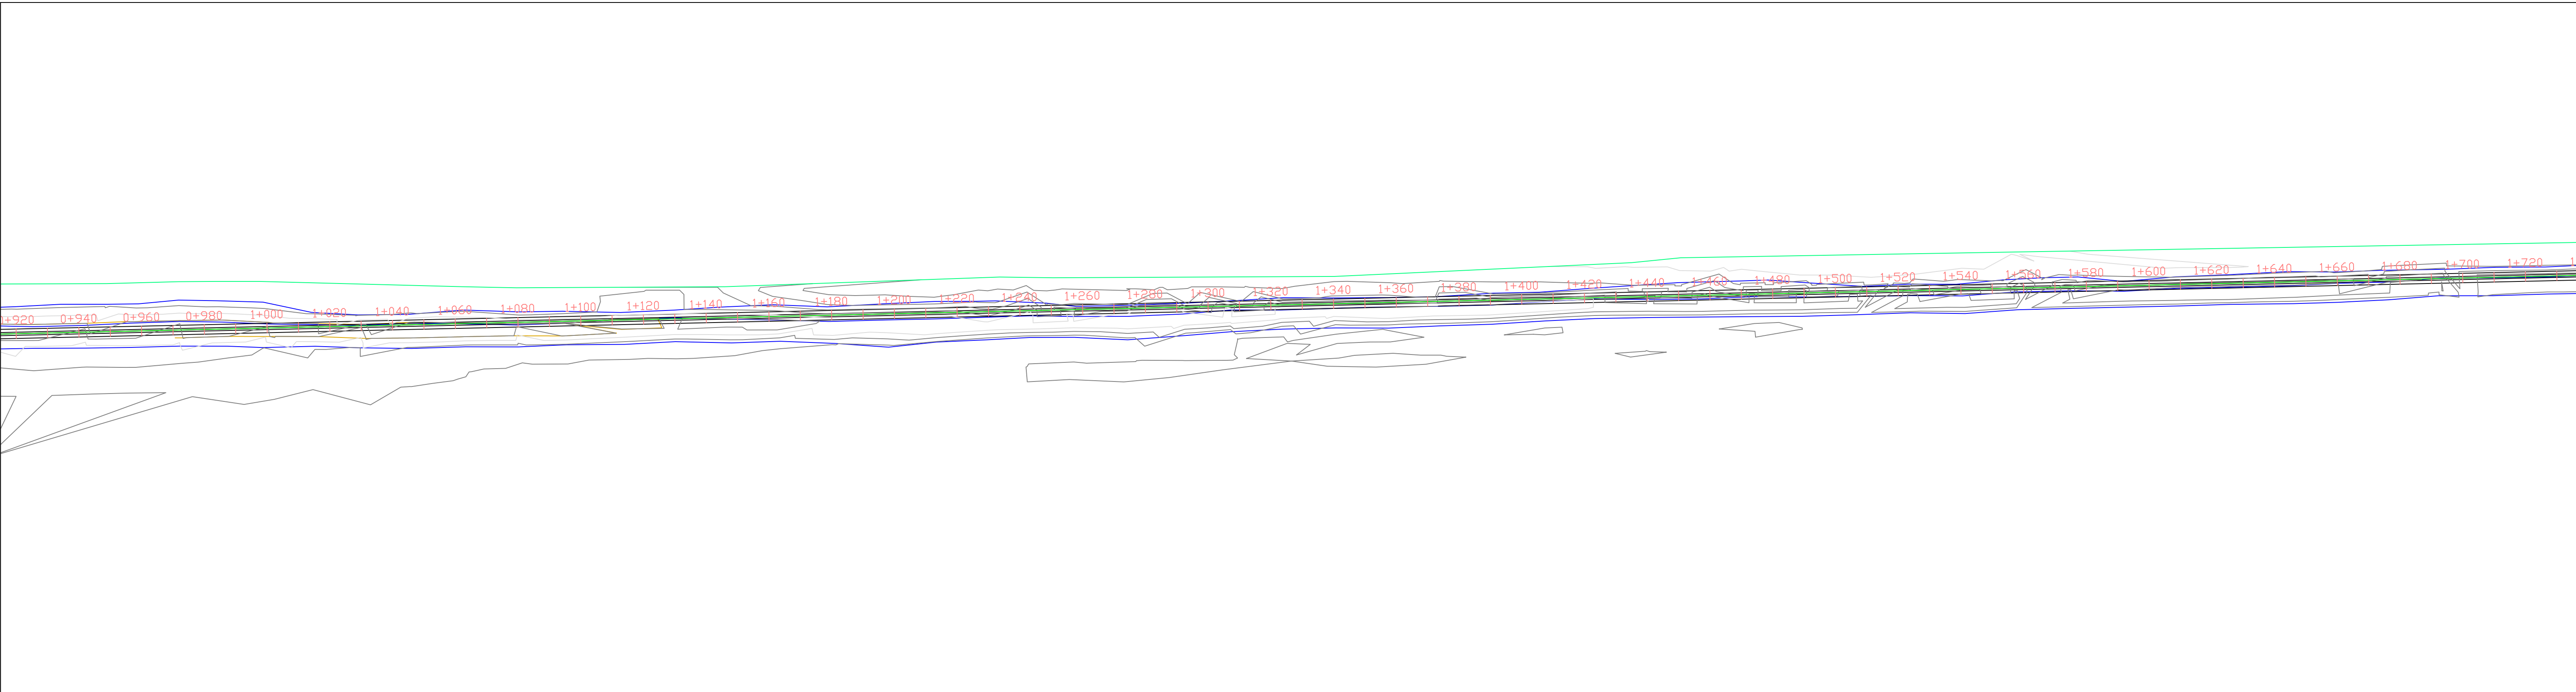


STORMWATER DRAINAGE



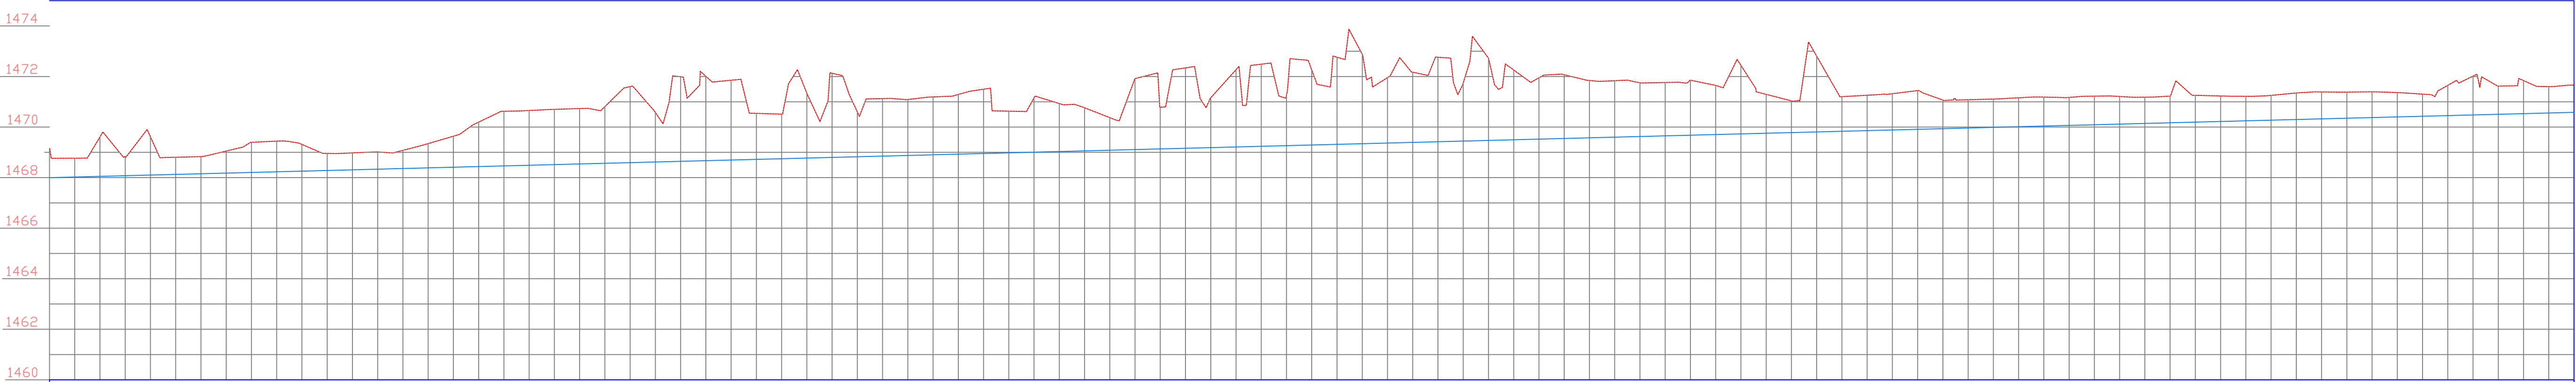


EXISTING GROUND LEVEL, m	1469.142	1469.611	1469.611	1468.832	1469.398	1469.314	1468.979	1469.080	1469.639	1470.625	1470.701	1470.811	1470.577	1472.000	1470.542	1471.340	1470.598	1471.092	1471.291	1470.630	1470.930	1470.373	1470.787	1471.160	1472.489	1472.258	1472.880	1472.171	1471.747	1472.258	1472.070	1471.835	1471.763	1471.649	1471.295	1472.805	1471.259	1471.444	1471.082	1471.159	1471.173	1471.211	1471.224	1470.668	1470.220	1471.231	1471.255	1471.391	1471.395	1471.303	1472.017	1472.017	1470.839	1471.662
TRENCH INVERT LEVEL, m	1467.997	1468.049	1468.101	1468.153	1468.204	1468.256	1468.308	1468.359	1468.411	1468.463	1468.514	1468.566	1468.618	1468.669	1468.721	1468.773	1468.824	1468.876	1468.928	1468.980	1469.031	1469.083	1469.135	1469.186	1469.238	1469.290	1469.341	1469.393	1469.445	1469.496	1469.548	1469.600	1469.652	1469.703	1469.755	1469.807	1469.858	1469.910	1469.962	1470.013	1470.065	1470.117	1470.168	1470.220	1470.272	1470.323	1470.375	1470.427	1470.479	1470.530	1470.582			
EXCAVATION DEPTH, m	1.14	1.56	1.51	0.68	1.19	1.06	0.67	0.72	1.23	2.16	2.19	2.24	1.96	3.34	1.82	2.57	1.77	2.22	2.36	1.65	1.90	1.29	1.65	1.97	3.25	2.97	3.54	2.78	2.30	2.76	2.52	2.23	2.11	1.95	1.54	3.00	1.40	1.53	1.12	1.15	1.11	1.09	1.06	1.01	0.98	1.07	1.02	0.88	1.54	1.31	1.68			





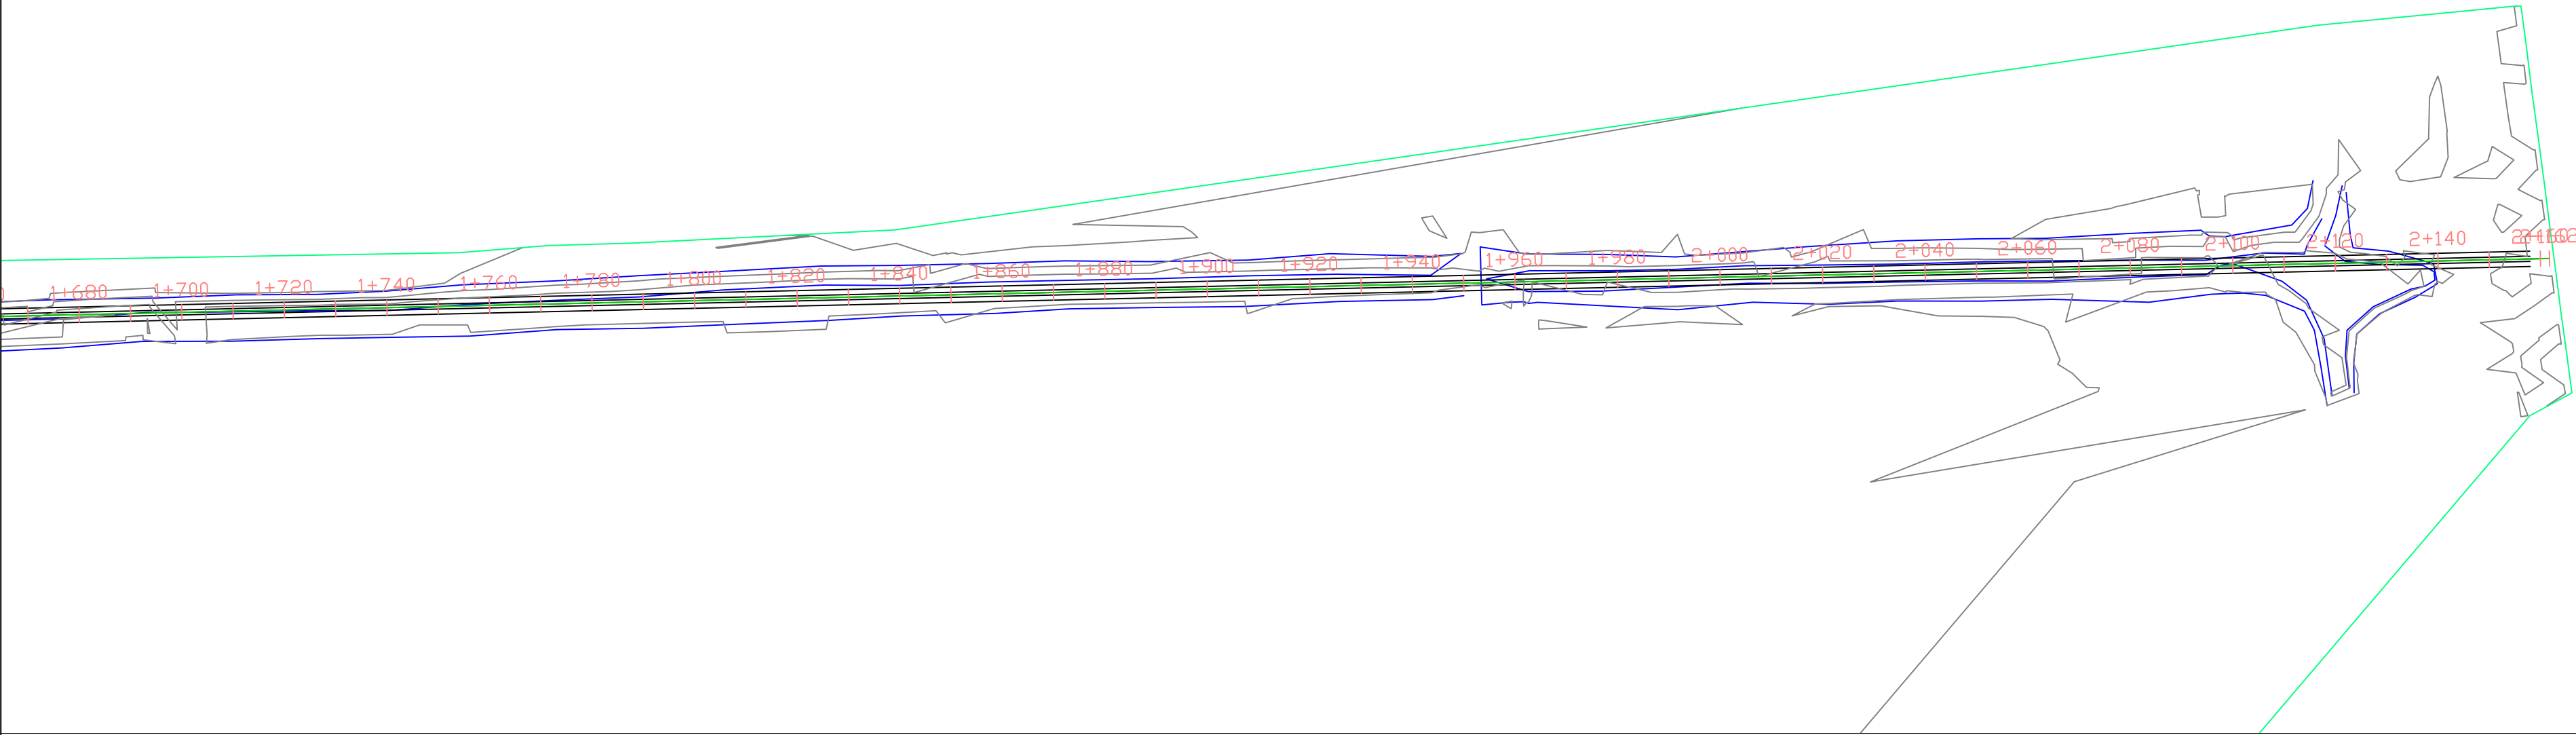



STORM WATER DRAINAGE

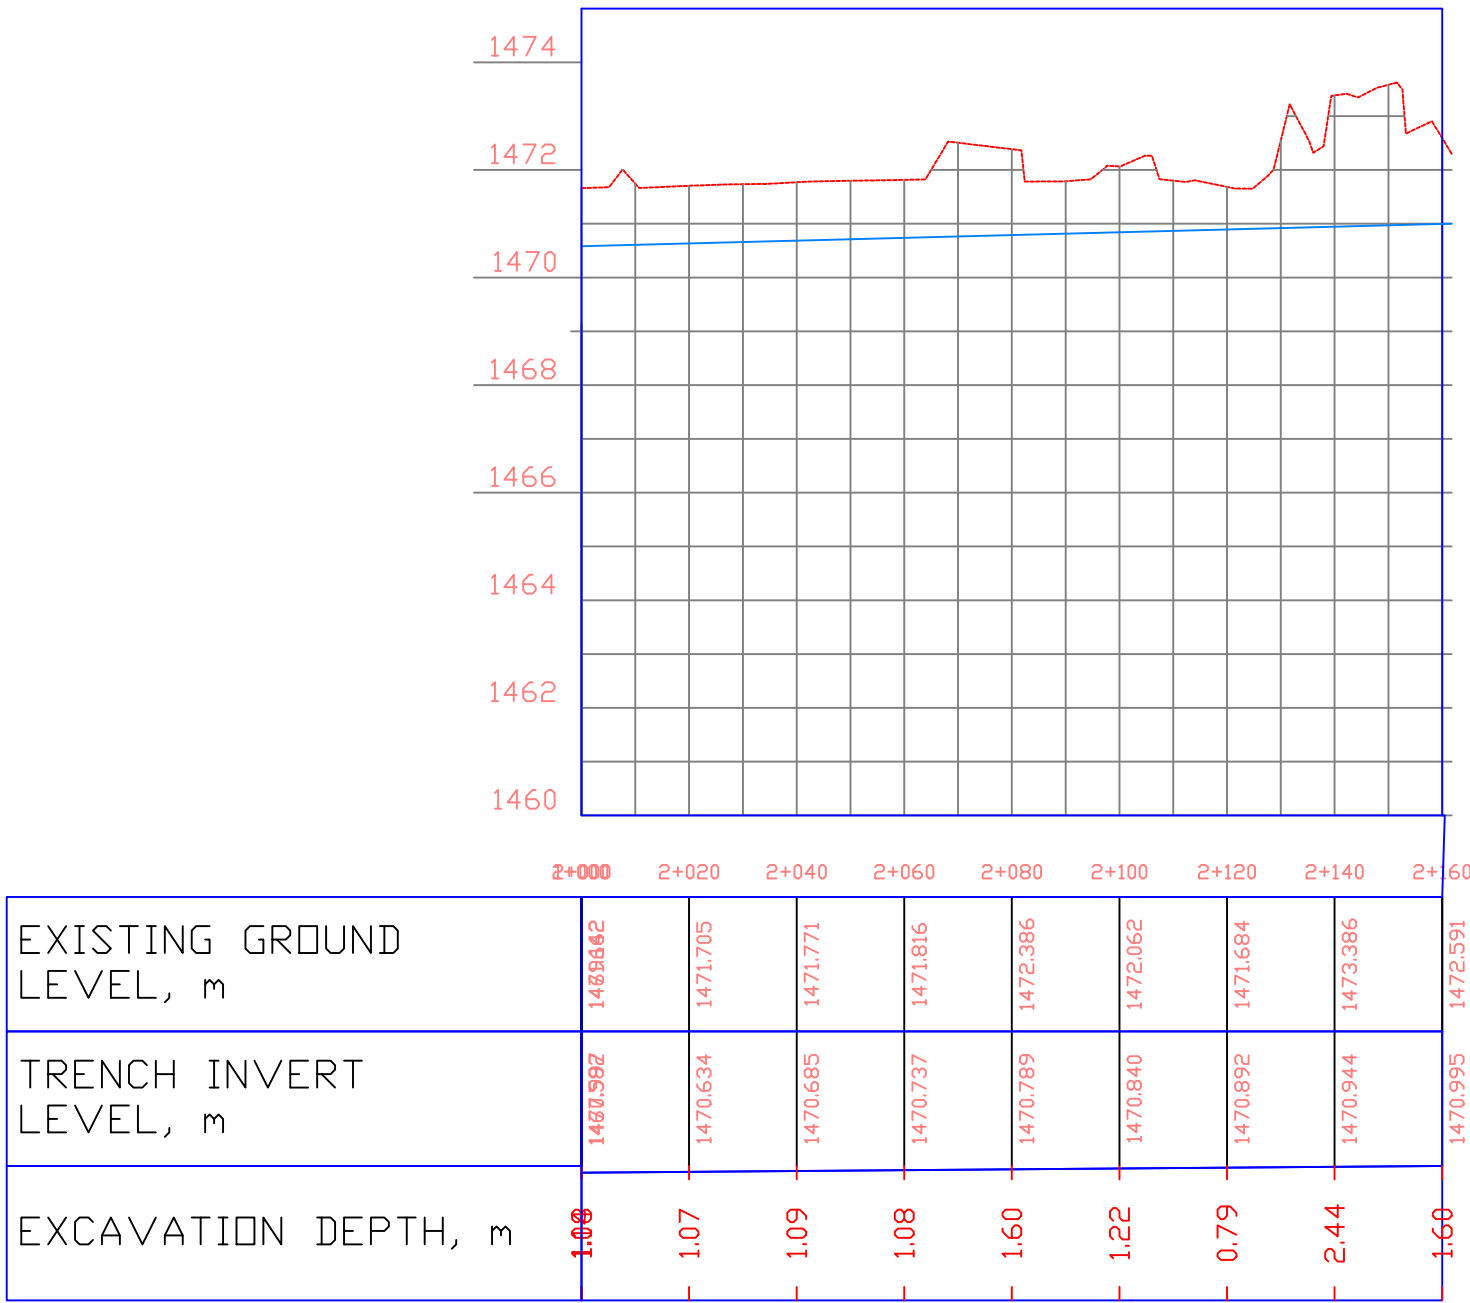

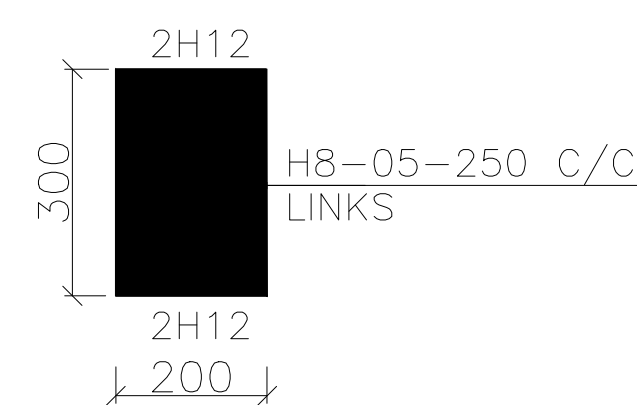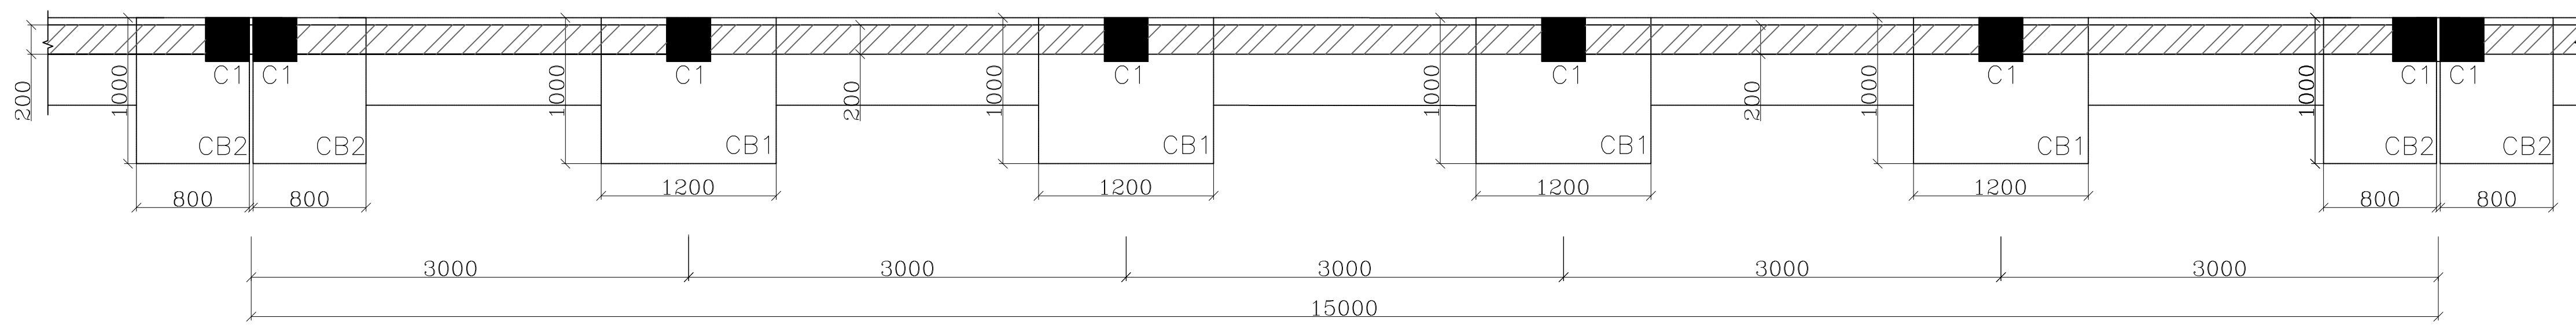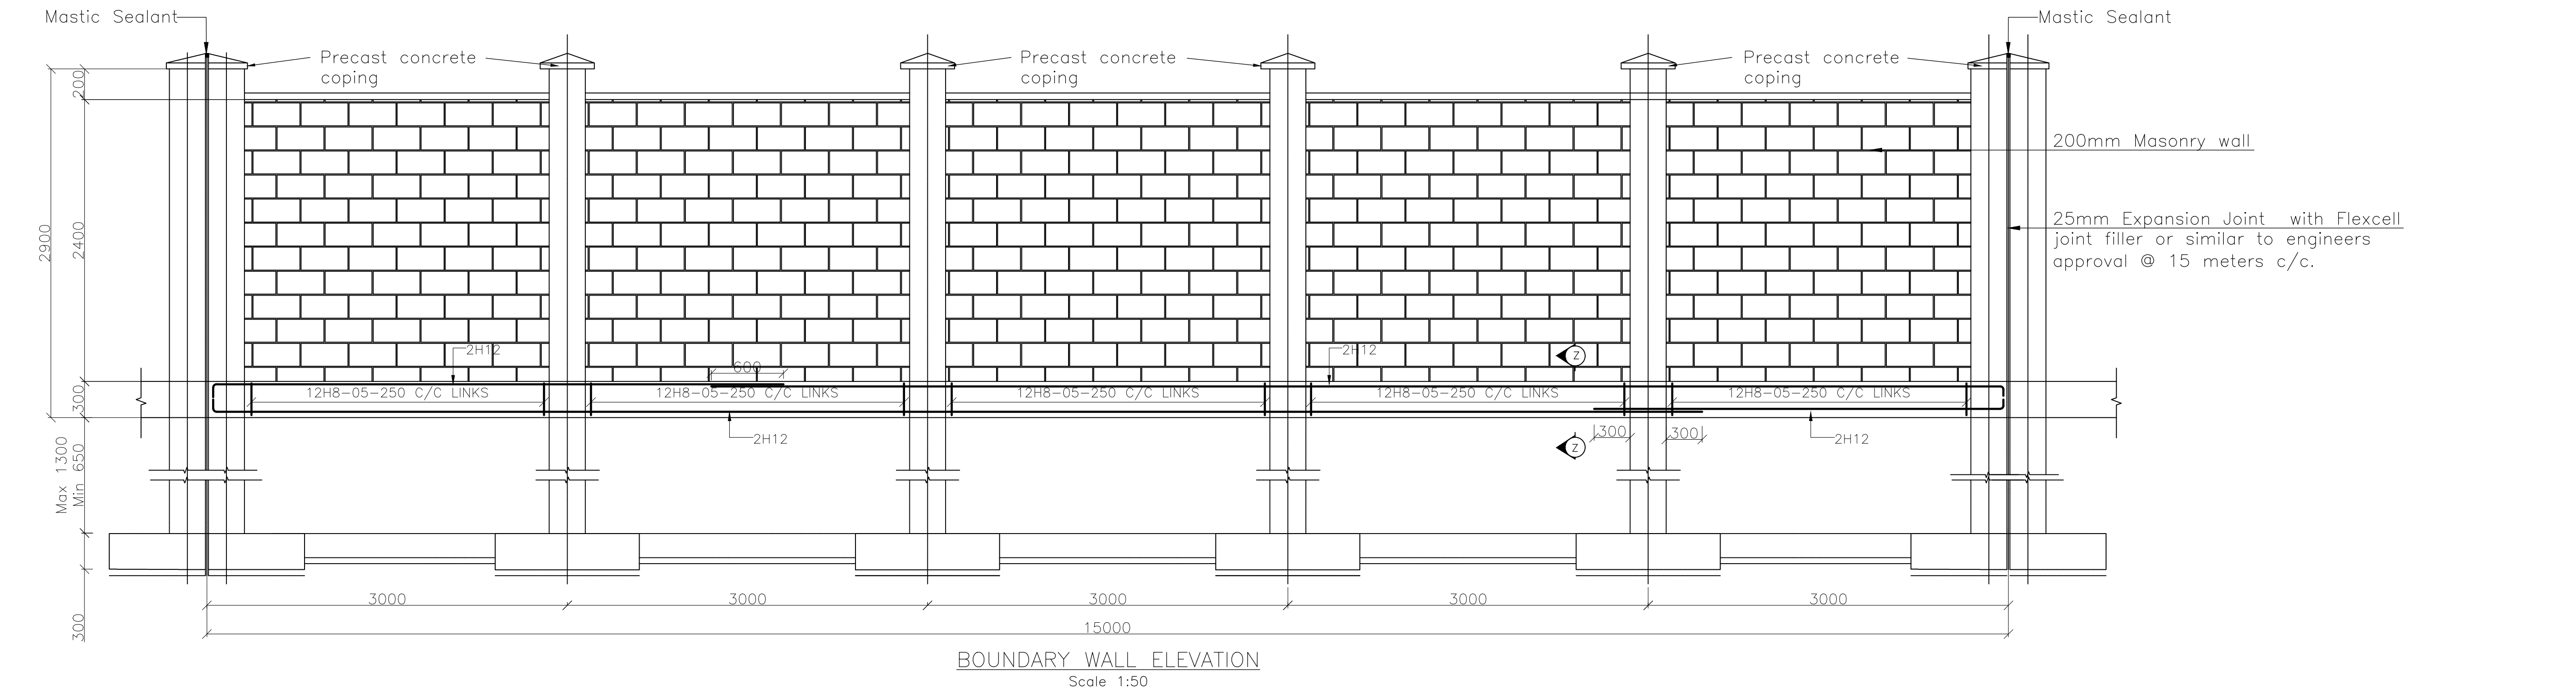


SEC: Z-Z
BOUNDARY WALL GROUND BEAM
(TO BE CAST WHERE HEIGHT OF WALL IS ABOVE 3M)
SCALE 1:15

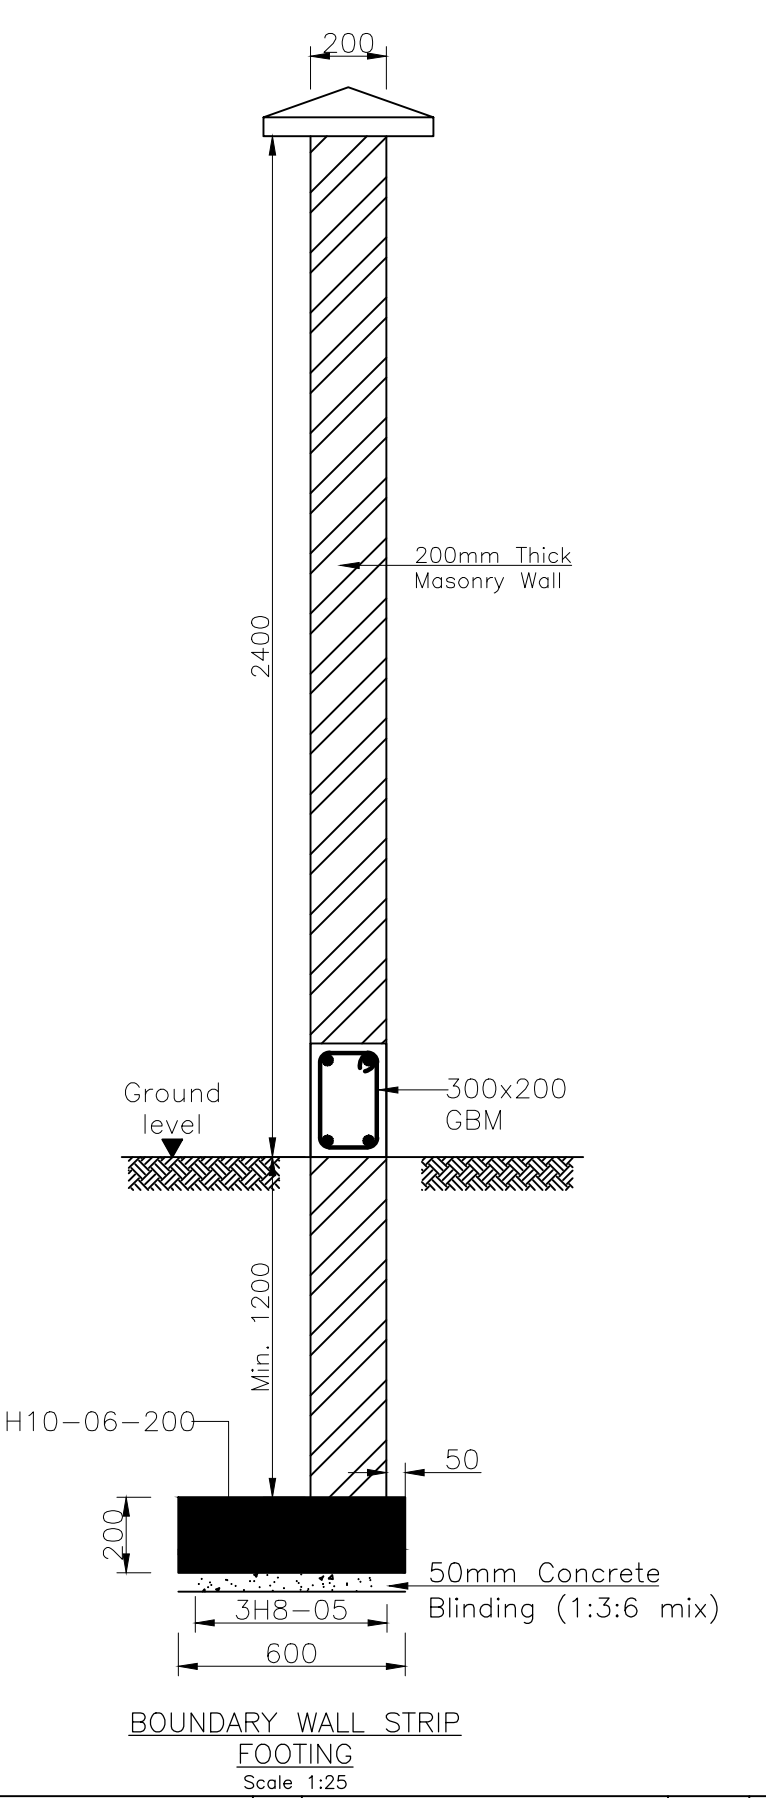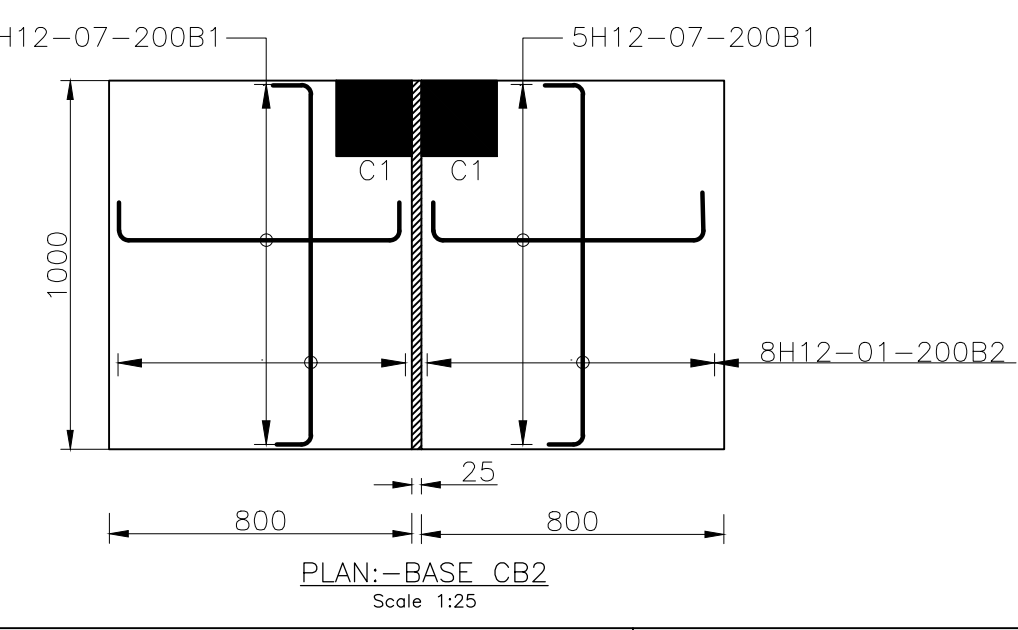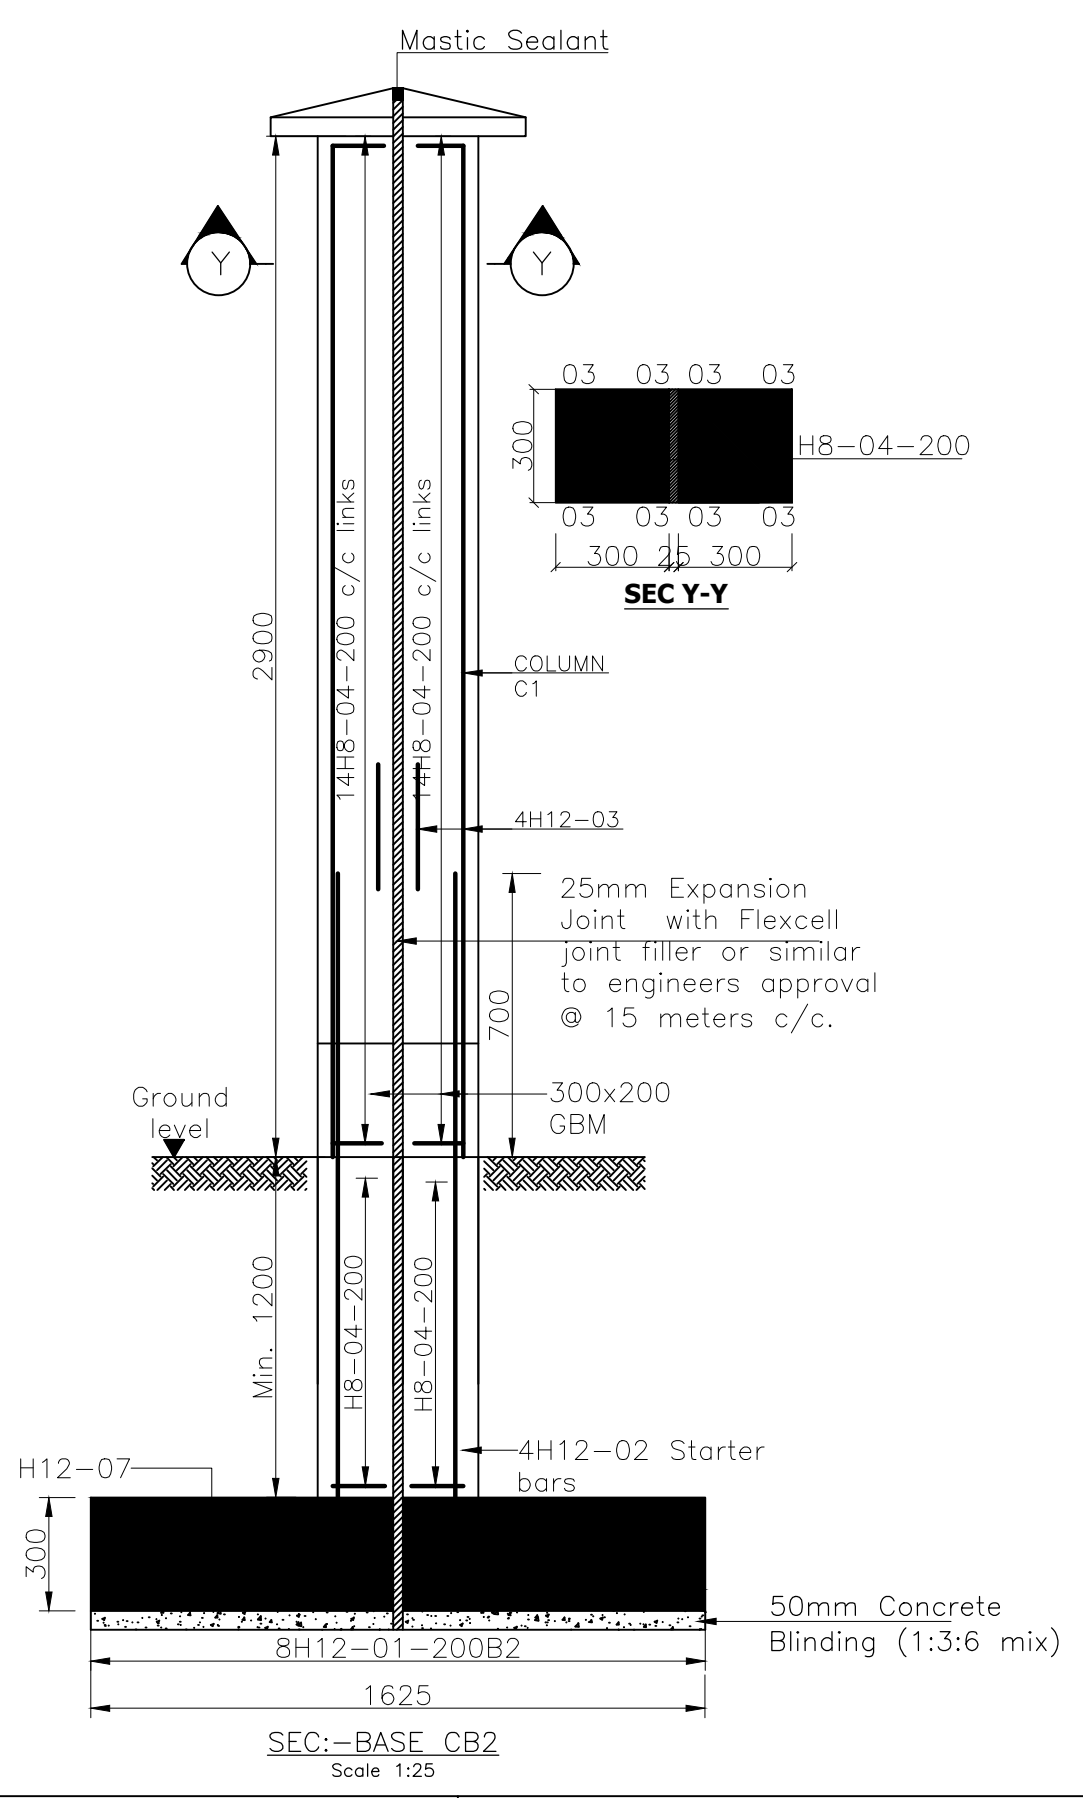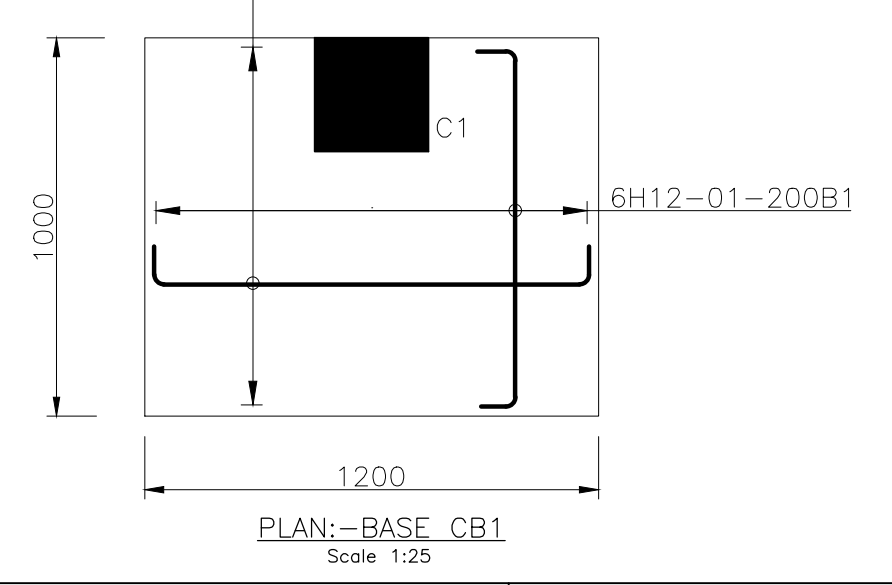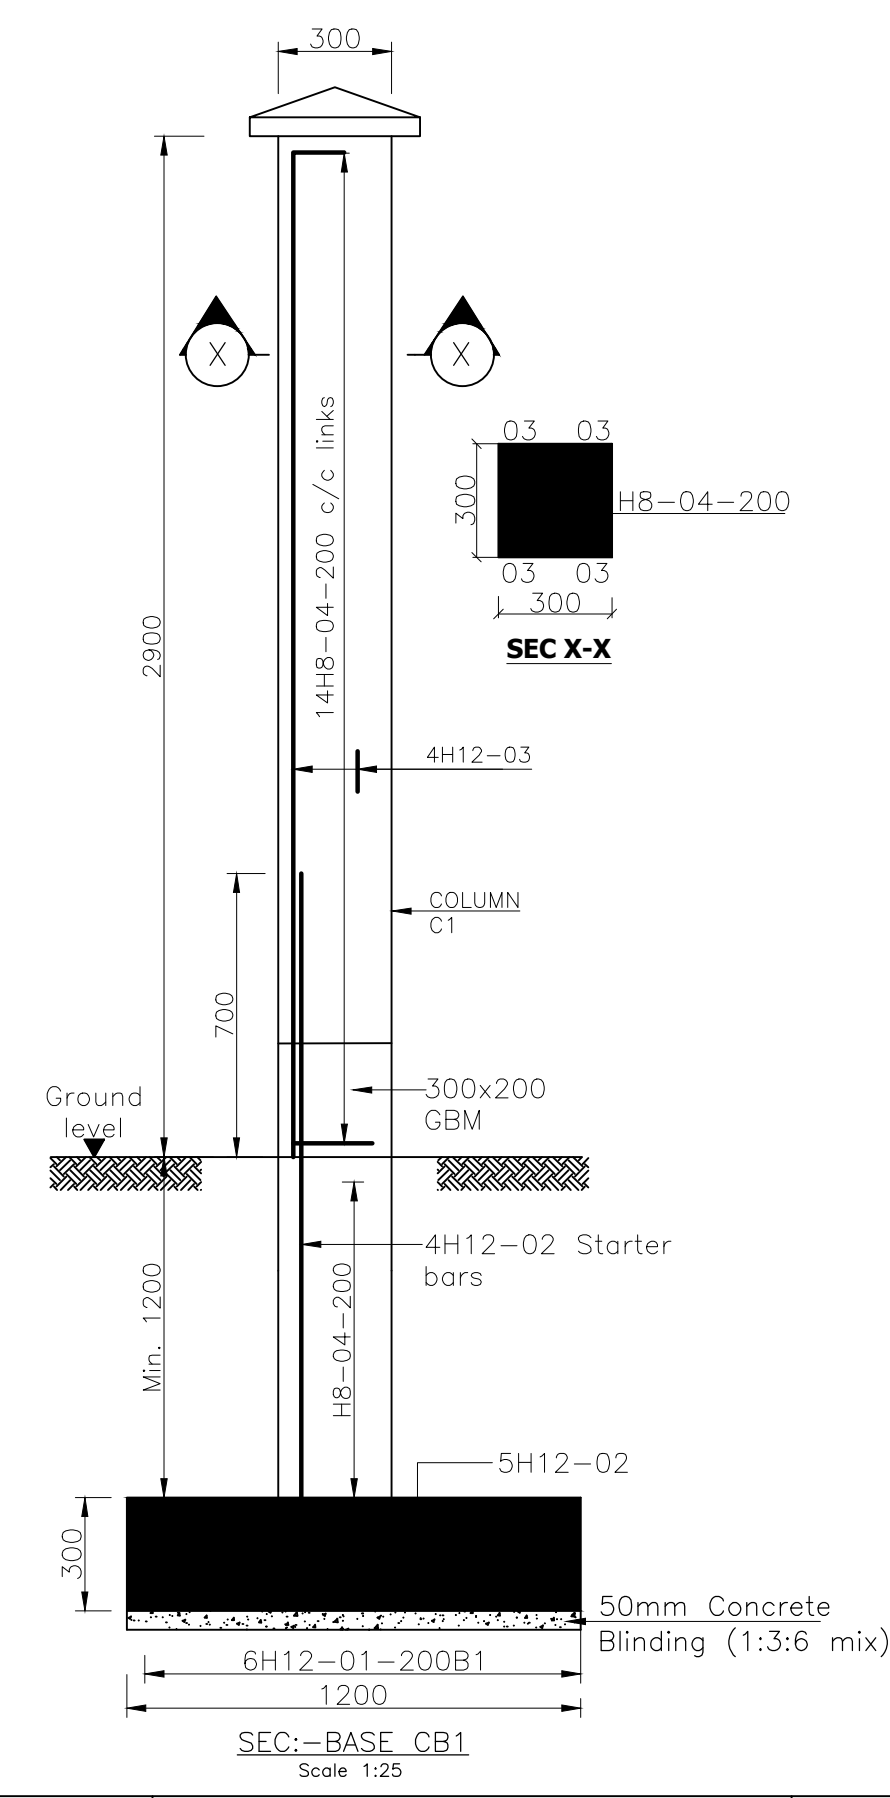


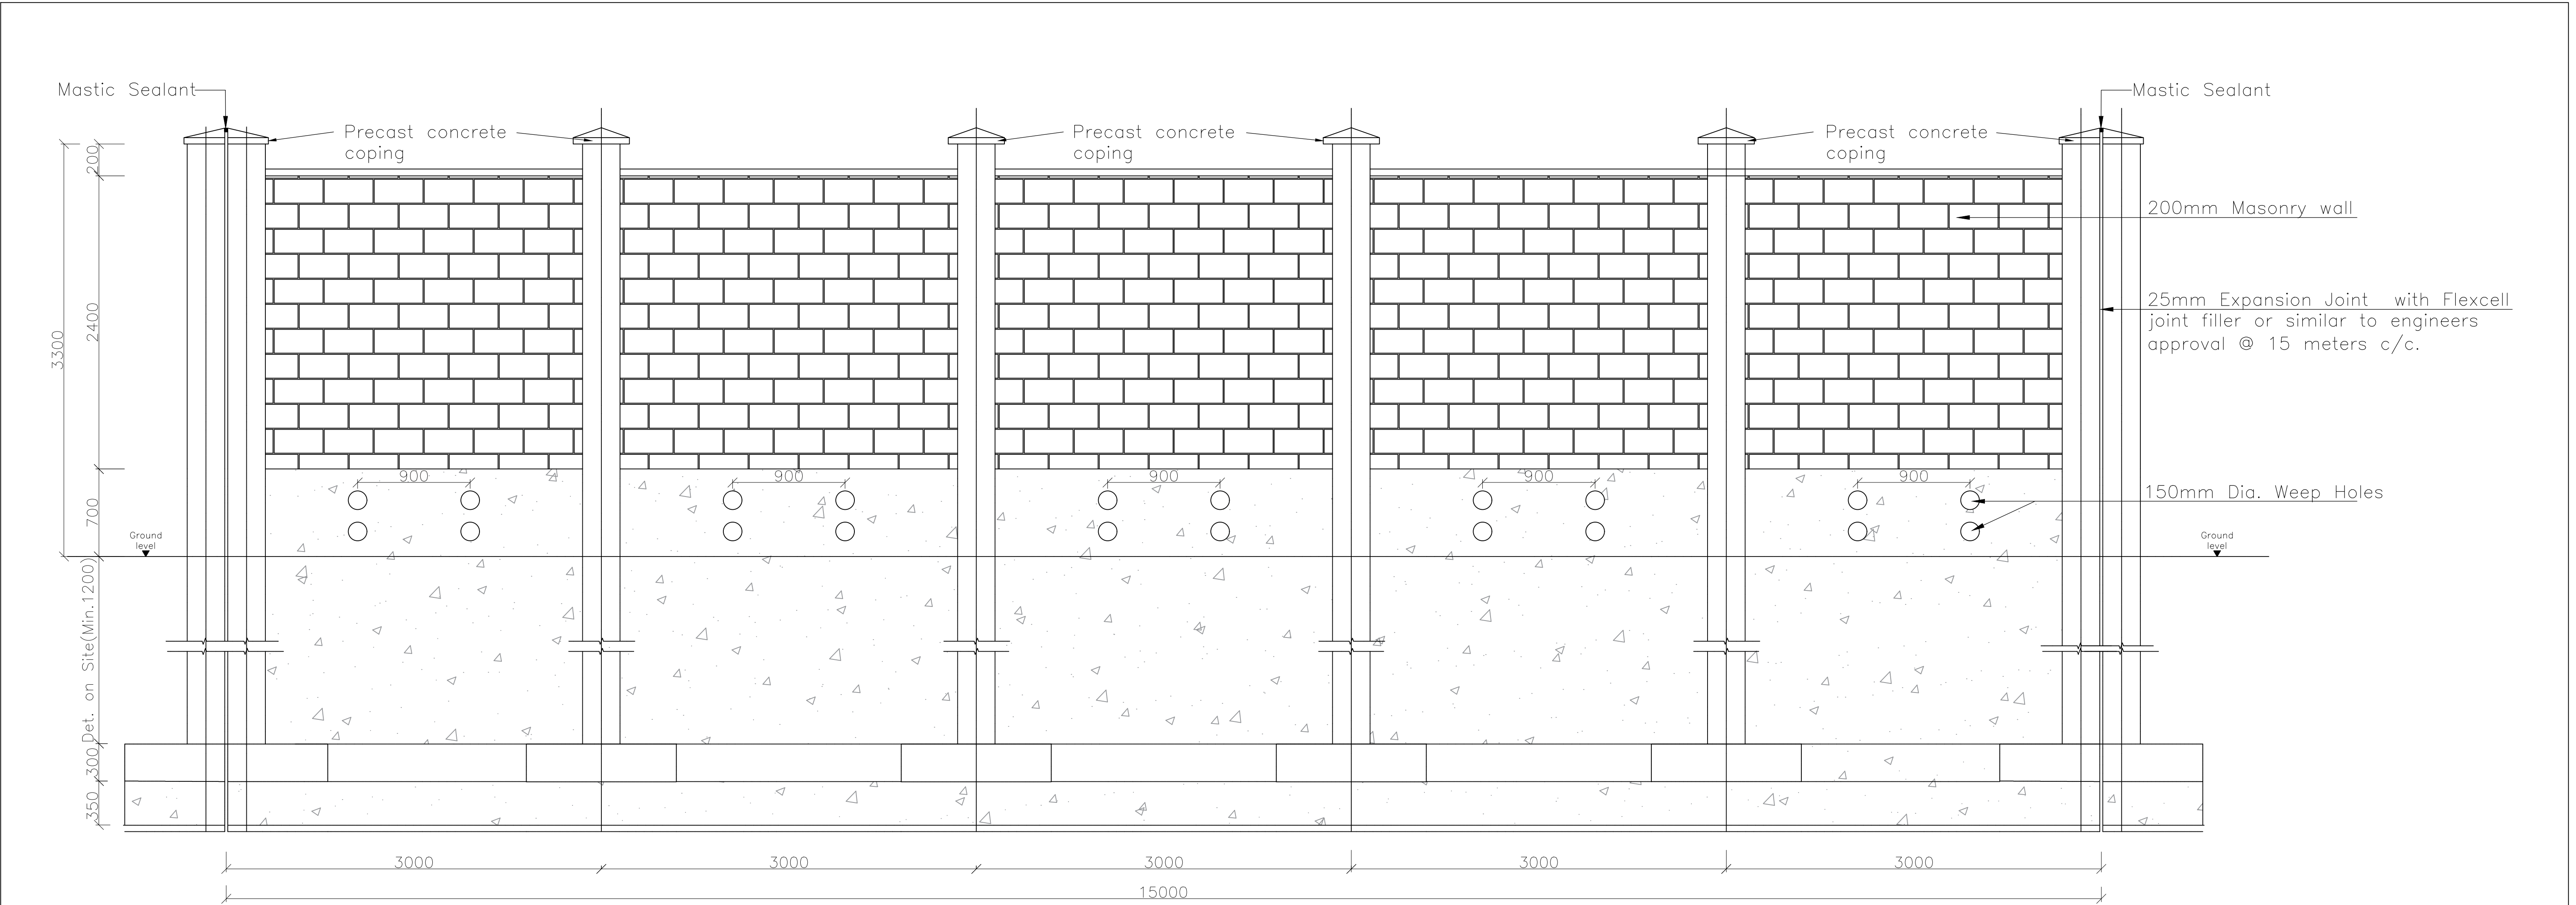


BOUNDARY WALL ELEVATION
Scale 1:50

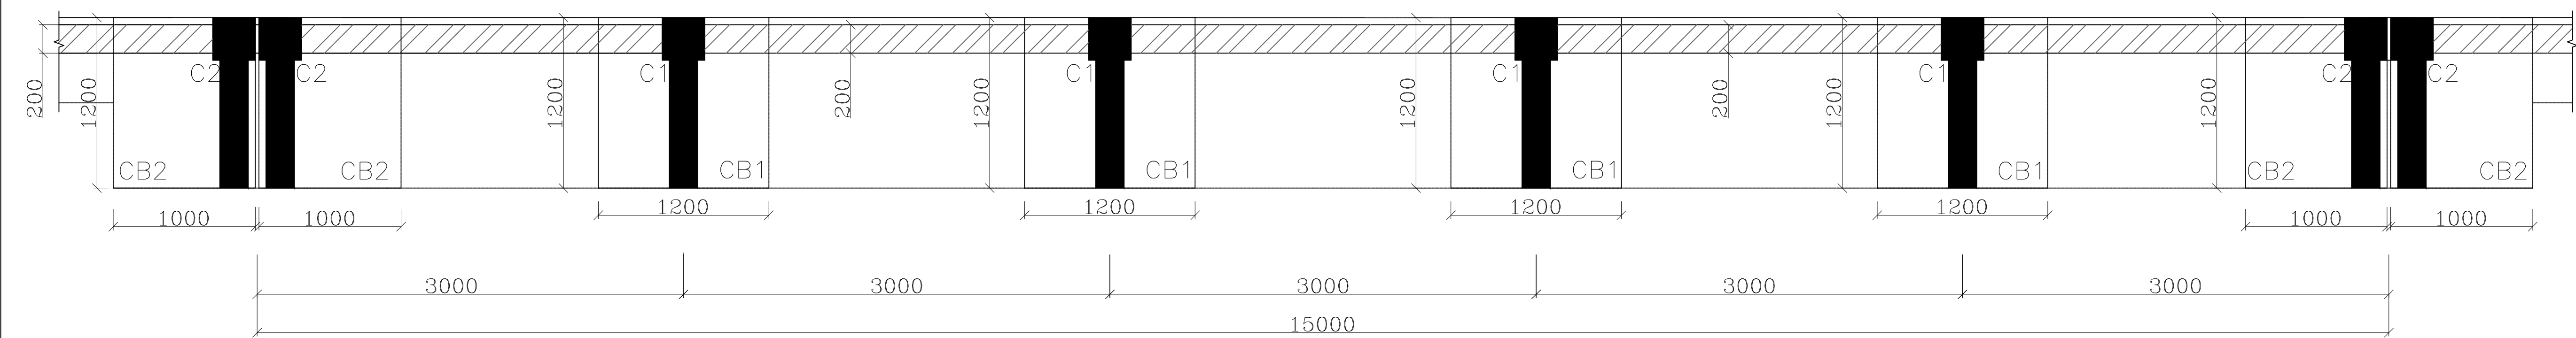


BOUNDARY WALL PLAN
Scale 1:50

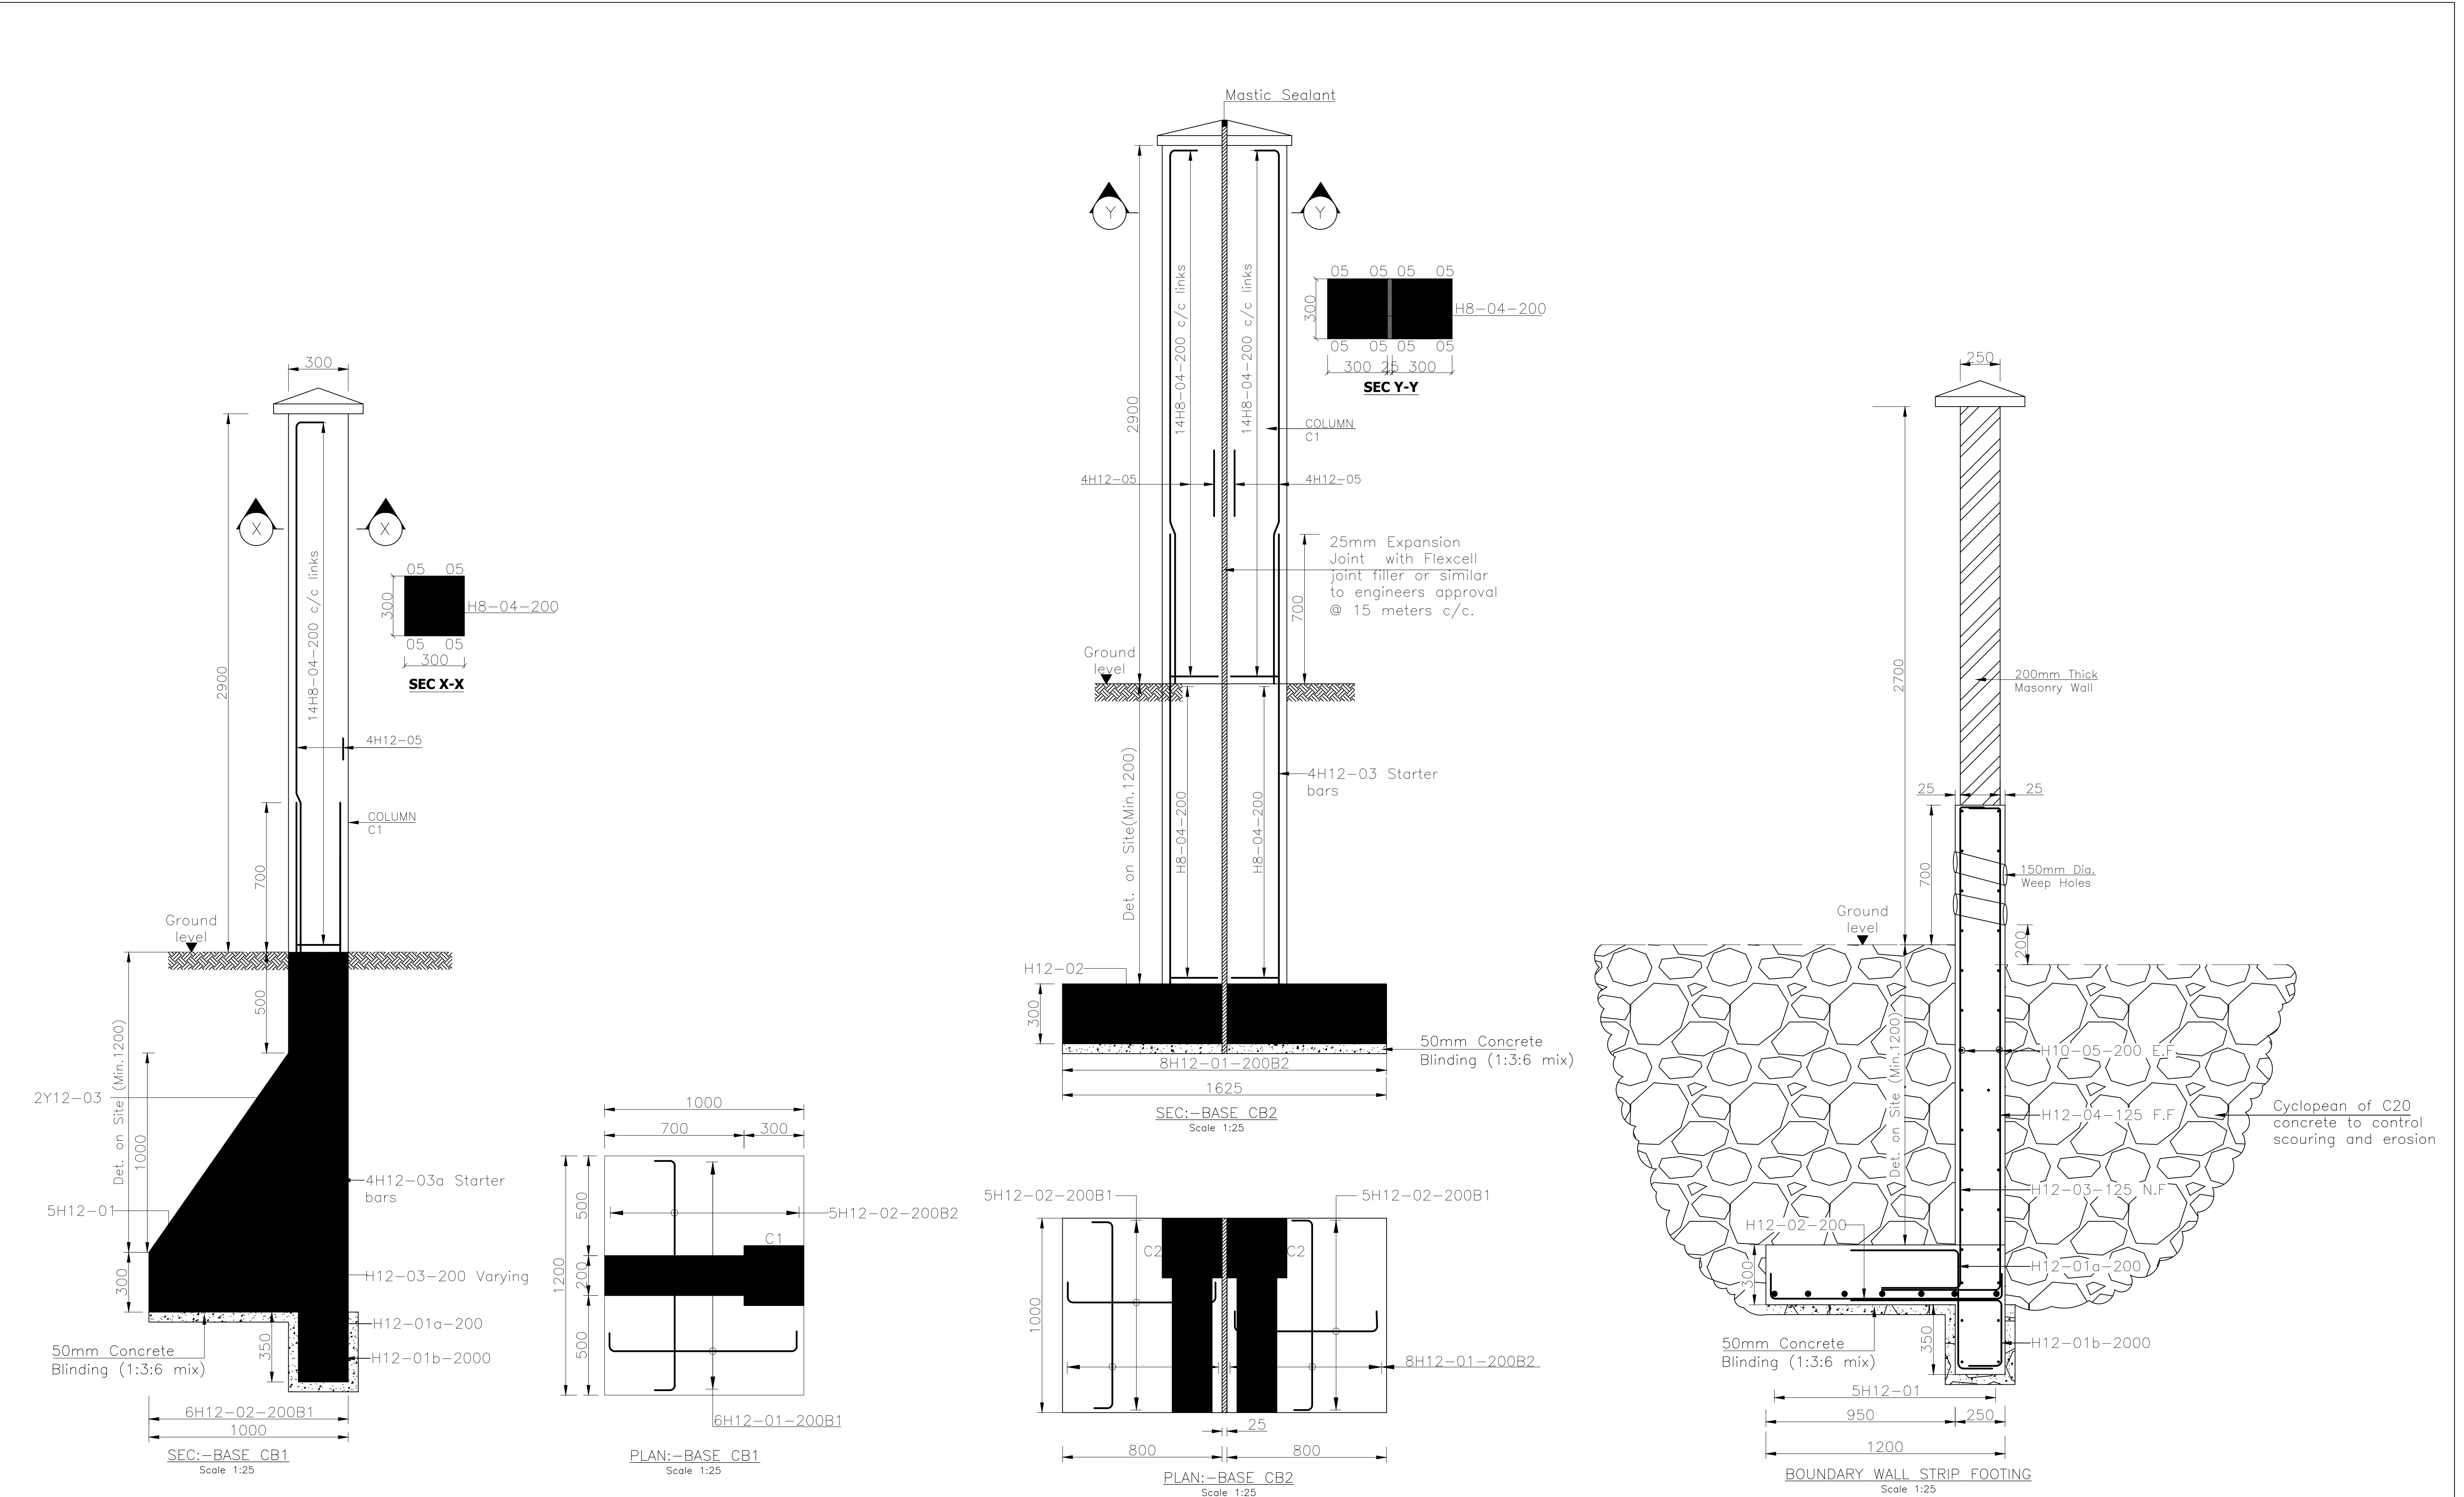


Civil Engineer:			Client:			Project			Drawing Title			NOTES														
 Frame Consultants Ltd P.O. BOX 58624-00200, NAIROBI. TEL: 2213744, 2251505, 0720523850 E-mail:info@frameconsultants.com			 ATHI WATER WORK DEVELOPMENT AGENCY P.O BOX 45283 - 00100 NAIROBI Tel: +254 (0) 274292/3 Email: info@athiwatwa.go.ke			NAIROBI RIVERS BASIN REHABILITATION AND RESTORATION PROGRAMME: SEWERAGE IMPROVEMENT PROJECT PHASE II (NaRSIP II) REHABILITATION AND EXPANSION OF DANDORA ESTATE SEWERAGE TREATMENT PLANT (DESTP) INLET WORKS			DANDORA ESTATE SEWAGE TREATMENT PLANT (DESTP) MASONRY BOUNDARY WALL NEAR NAIROBI RIVER/AREA PRONE TO FLOODING) - PLAN, SECTIONS AND DETAILS			NOTES 1. Read this drawing in conjunction with relevant G.A., Services and Architectural drawings. Any discrepancy to be reported to the Engineer. 2. All dimensions are in millimeters unless specified otherwise. 3. All levels are indicated in mm unless specified otherwise. 4. All structural concrete to be Class 20 unless stated otherwise.			5. Minimum cover to all reinforcement to be: Stairs, Slabs & Walls = 20mm Beams (main bars) = 30mm Columns (main bars) = 40mm Foundations = 50mm 6. All high tensile (Y) and mild steel (R) bars to be in accordance with BS 4449 and fabric mesh to be made from cold worked steel bars in accordance with BS 4483.			7. Maximum tolerance on concrete cover is +/- 5mm. 8. Minimum laps to all bars to be 550 unless stated otherwise. 9. Assumed Bearing Pressure taken to be 150 KN/m². 10. Nominal aggregate size to be 20mm 11. Hoop Iron to be used to tie the Masonry wall to columns after every two alternate courses. 12. Masonry wall to be 200mm with minimum compressive strength 7.0kN/m²								
REV			R E V I S I O N S			SIGN			DATE			APPROVED			Designed by D.K			Drawn by D.K								
D			BY			CHECKED									Checked by FMK			Approved by								
C			BY			CHECKED									Scales 1:50			Date: OCTOBER 2021								
B			BY			CHECKED									Job No. FC/CE108			ACAD File: CE108_TY_06B								
A			BY			CHECKED									P STATUS			DRG No. FC/CE108/TY/06B								
																		REV								

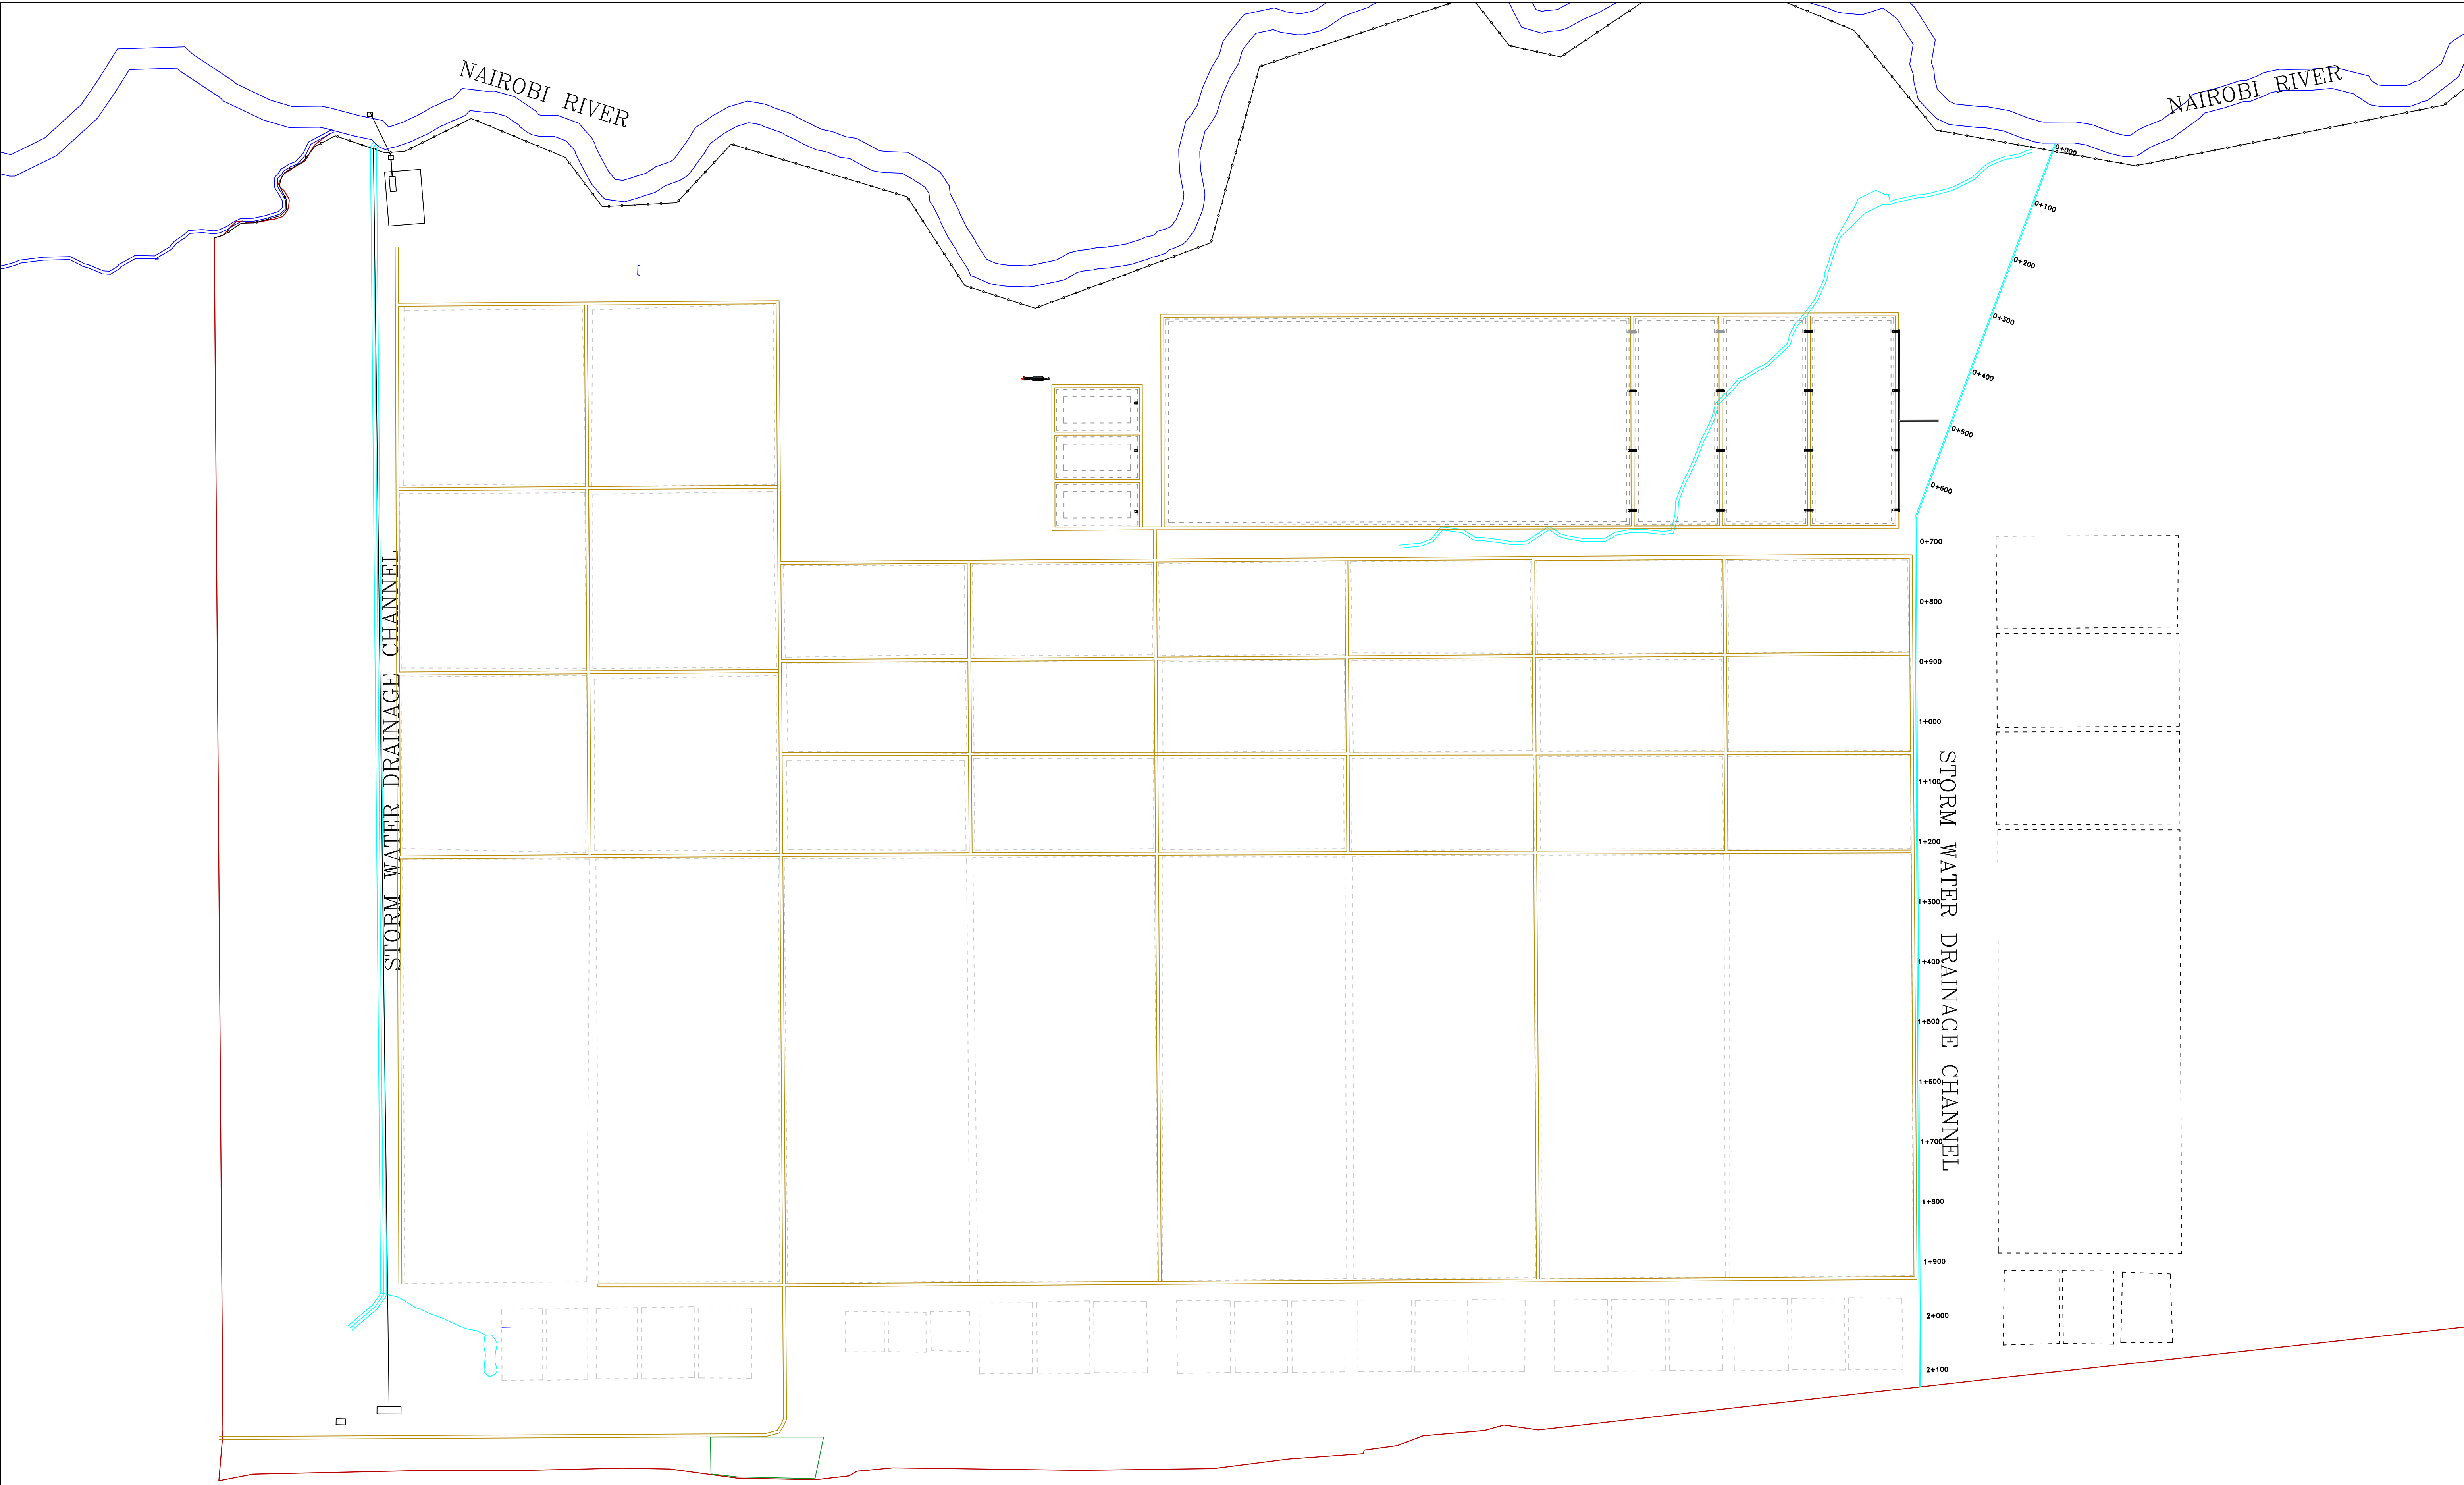

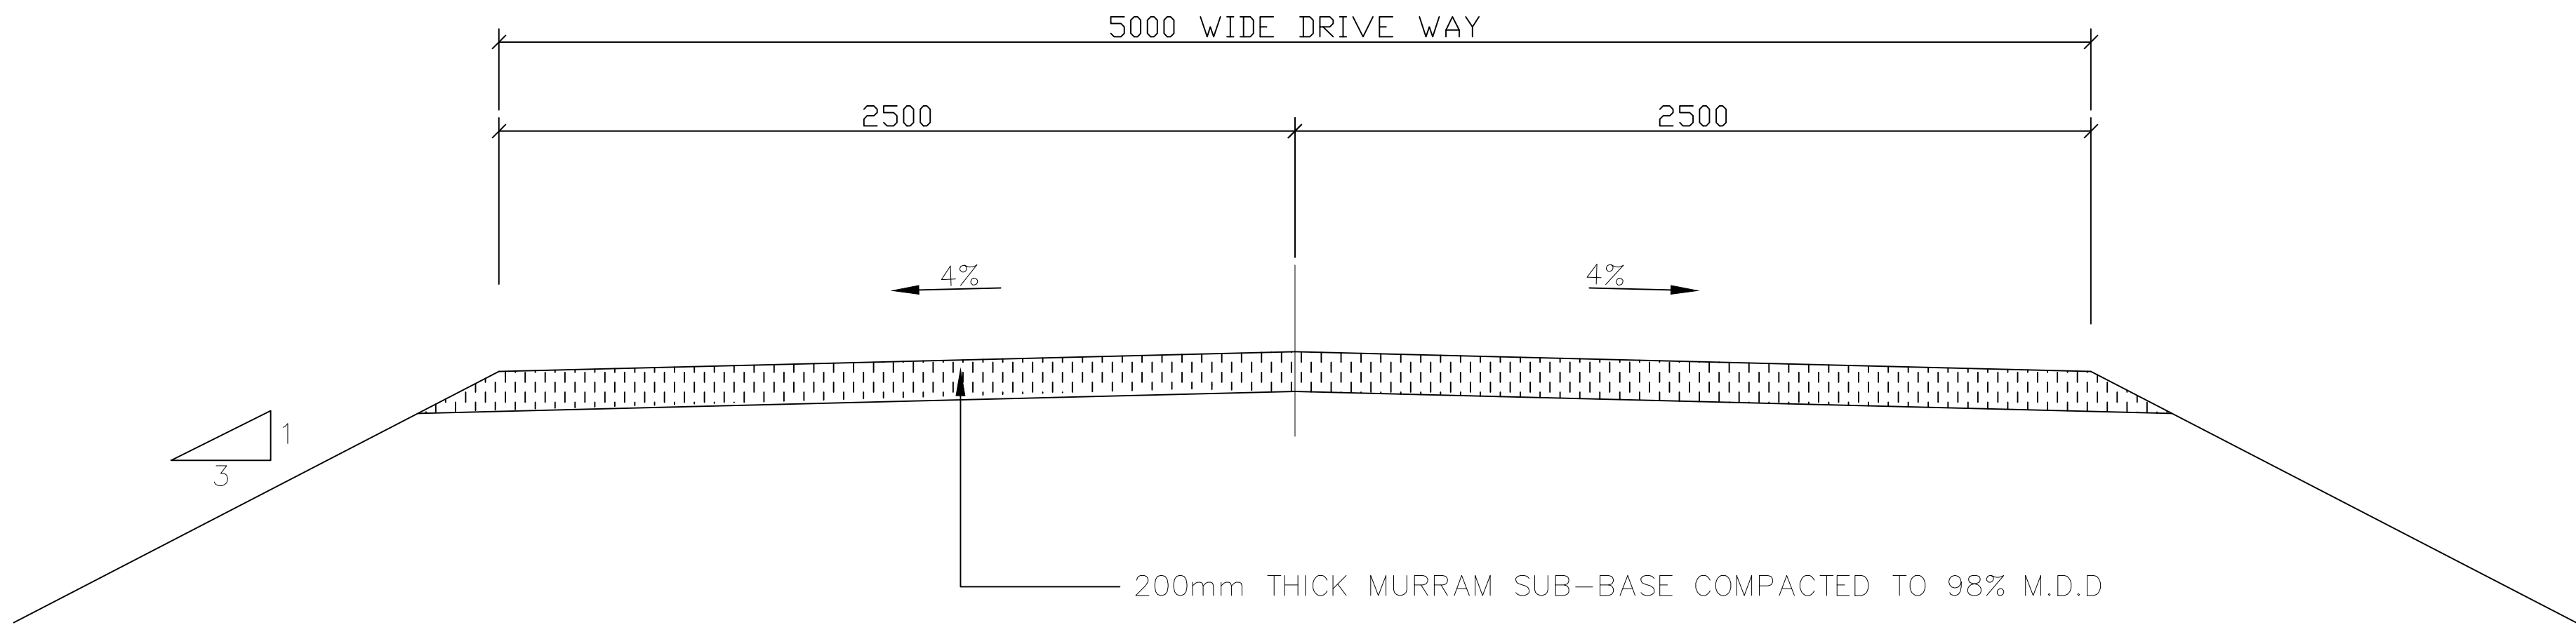

TYPICAL ACCESS ROAD CROSS-SECTION ON PONDS EMBANKMENT
(COMPACTED TO 98% M.D.D)
SCALE 1:25

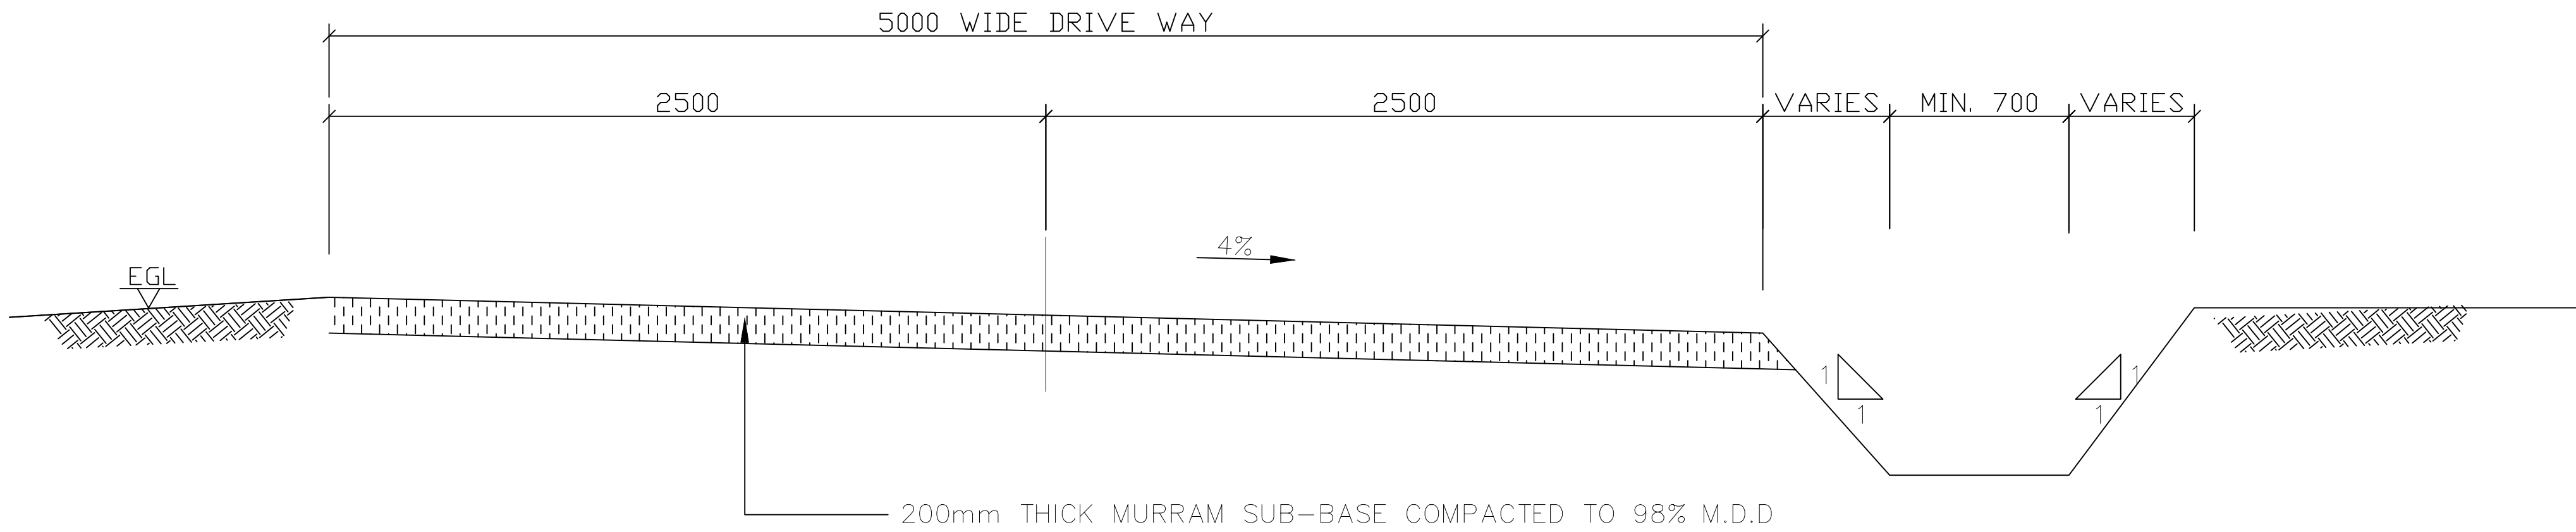

TYPICAL ACCESS ROAD CROSS-SECTION ON NORMAL GROUND
(COMPACTED TO 98% M.D.D)
SCALE 1:25

Civil Engineer:

FC
Frame Consultants Ltd
P.O. BOX 58624-00200, NAIROBI.
TEL: 2213744, 2251505, 0720523850
E-mail: info@frameconsultants.com

Client:

ATHI WATER WORKS
ATHI WATER WORK DEVELOPMENT AGENCY
P.O BOX 45283 - 00100 NAIROBI,
Tel: +254 (0) 274292/3
Email: info@awwda.go.ke

Project

NAIROBI RIVERS BASIN REHABILITATION AND
RESTORATION PROGRAMME: SEWERAGE
IMPROVEMENT PROJECT PHASE II (NaRSIP II)

REHABILITATION AND EXPANSION OF DANDORA
ESTATE SEWERAGE TREATMENT PLANT (DESTP) INLET
WORKS

Drawing Title

DANDORA ESTATE SEWAGE TREATMENT PLANT
(DESTP)

ACCESS ROADS - TYPICAL CROSS-SECTION


NOTES

- DRAWING TO SCALE ON A1 PAPER SIZE
- DRAWING TO BE READ INCONJUNCTION WITH OTHER RELEVANT DRAWINGS
- ALL DIMENSIONS AND LEVELS TO CHECKED ON SITE BEFORE COMMENCING ANY WORK. ANY DISCREPANCY TO BE REPORTED TO THE ENGINEER
- ONLY FIGURED DIMENSIONS TO BE TAKEN FROM THIS DRAWING

REV.	R E V I S I O N S				APPROVED	Designed by		Drawn by	
	BY	SIGN	DATE			D.K		D.K	
D	CHECKED					Checked by	FMK	Approved by	
C	CHECKED					Scales		Date:	
B	CHECKED					Job No.		ACAD File:	
A	CHECKED					P STATUS		DRG No.	
						FC/CE108		FC/CE108_TY_09	

ELECTROMECHANICAL WORKS

FIELD	DR.	DRAWING—TITLE	FIELD	DR.	DRAWING—TITLE
EM	FC/CE108/EM/01	LIST OF DRAWINGS			
M	FC/CE108/EM/02	INTERMEDIATE SCREENING DESIGN LAYOUT	M	E01/40—18	PROPOSED CONTROL ROOM ROOF TOP PLAN PLUMBING LAYOUT
M	FC/CE108/EM/03	CUP SCREEN DESIGN LAYOUT	M	E01/40—19	PROPOSED CONTROL ROOM AC LAYUOT
E	E01/40—1	INLET WORKS MAIN LV BOARD	M	E01/40—20	PROPOSED CONTROL FIRE FIGHTING LAYOUT
E	E01/40—2	INLET WORKS RAKES AND COMPACTORS SCHEMATICS	E	E01/40—21	INLET WORKS—PROPOSED CONTROL ROOM LIGHTING LAYOUT
E	E01/40—3	ROTOR STRAINER ELECTRICAL SCHEMATICS	E	E01/40—22	INLET WORKS—PROPOSED CONTROL ROOM ELECTRICAL POWER LAYOUT
E	E01/40—4	CUP SCREEN ELECTRICAL SCHEMATICS			
E	E01/40—5	FEEDER PUMPS ELECTRICAL SCHEMATICS			
E	E01/40—6	JET SPRAY PUMPS ELECTRICAL SCHEMATICS			
E	E01/40—7	FLASH PUMPS ELECTRICAL SCHEMATICS			
E	E01/40—8	AIR BLOWERS ELECTRICAL SCHEMATICS			
E	E01/40—9	JETA DRIVES ELECTRICAL SCHEMATICS			
E	E01/40—10	GRIT REMOVAL ELECTRICAL SCHEMATICS			
E	E01/40—11	SCREW CLASSIFIERS ELECTRICAL SCHEMATICS			
E	E01/40—12	PENSTOCK ACTUATORS ELECTRICAL SCHEMATICS			
E	E01/40—13	KIU TREATMENT PLANT MAIN LB BOARD ELECTRICAL SCHEMATICS			
M	E01/40—14	DESTP INLET WORKS PROPOSED FIRE FIGHTING LAYOUT			
M	DESTPE01/15	KILN INCINERATOR			
M	DESTPE01/16	PROPOSED CONTROL ROOM PLUMBING LAYOUT			
M	DESTPE01/17	PROPOSED CONTROL ROOM DRAINAGE LAYOUT			

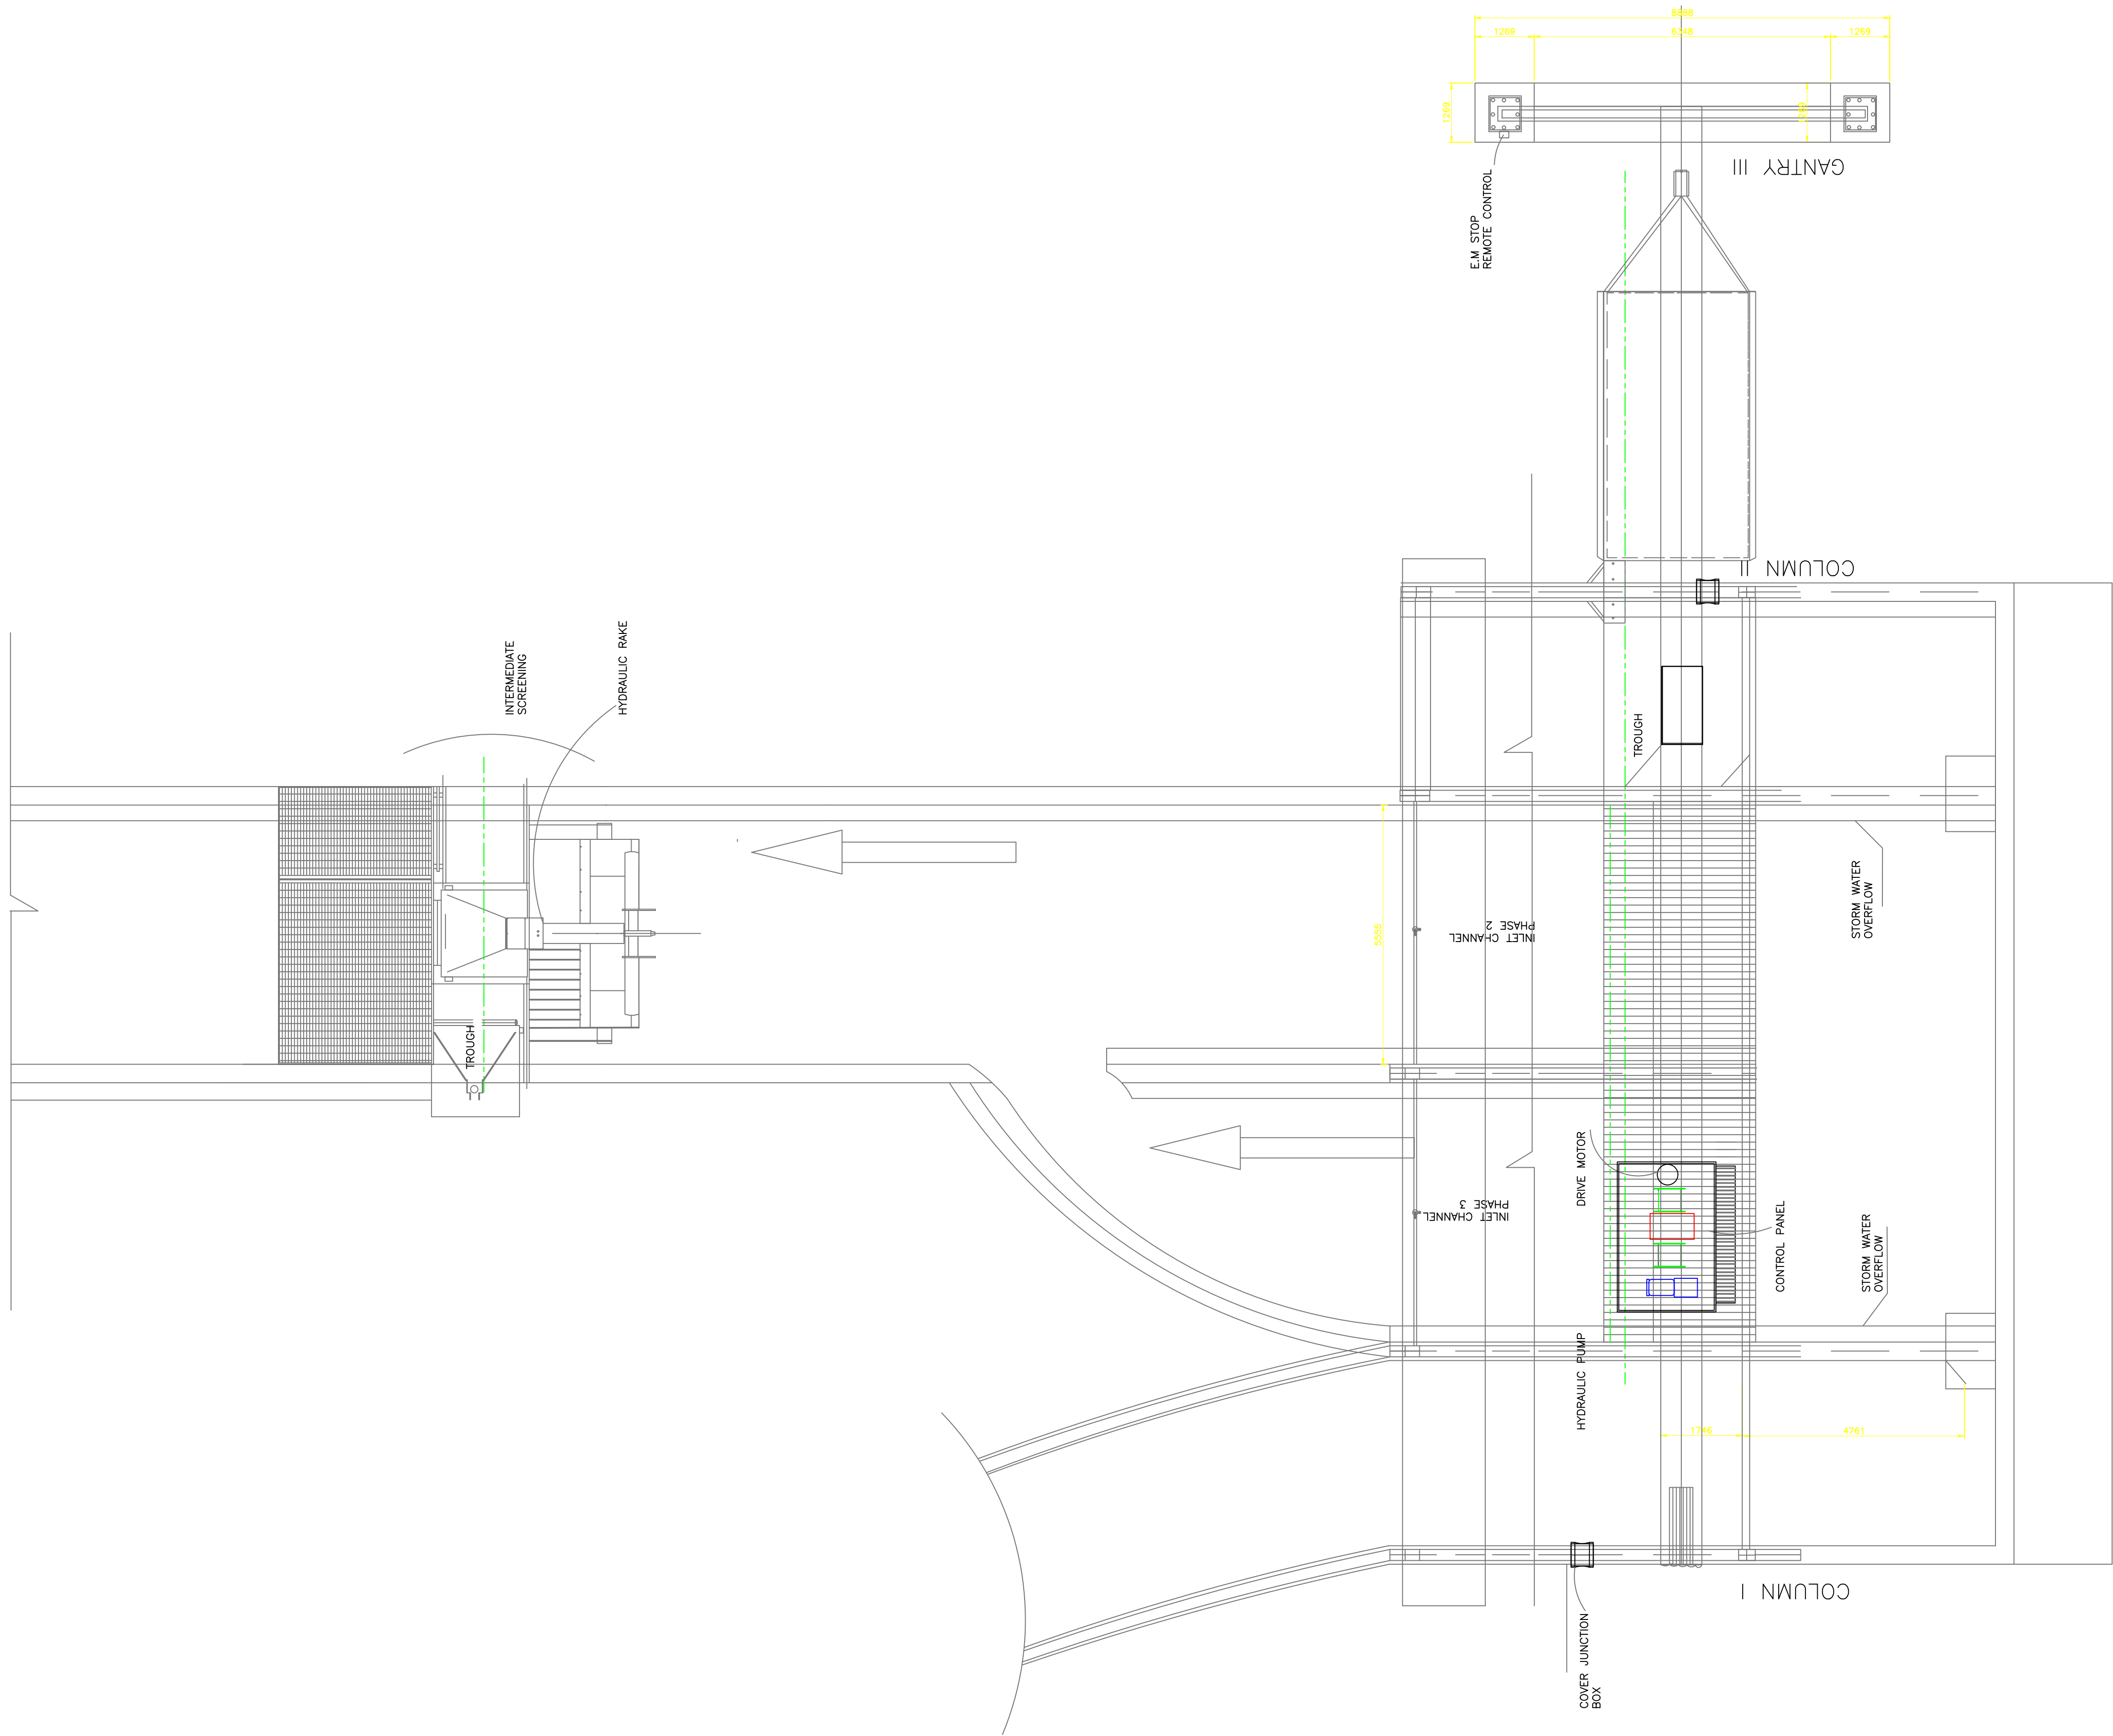

Civil Engineer:



Frame Consultants Ltd.
P.O. BOX 58624-00200, NAIROBI.
TEL: 2213744, 2251505, 0720523850
E-mail: info@frameconsultants.com

Client:



ATHI WATER WORK DEVELOPMENT AGENCY
P.O BOX 45283 - 00100 NAIROBI,
Tel: +254 (0) 274292/3
Email: info@awwda.go.ke

Project

NAIROBI RIVERS BASIN REHABILITATION AND
RESTORATION PROGRAMME: SEWERAGE
IMPROVEMENT PROJECT PHASE II (NaRSIP II)

REHABILITATION AND EXPANSION OF DANDORA
ESTATE SEWERAGE TREATMENT PLANT (DESTP) INLET
WORKS

SERVICES ENGINEER:



Electro mechanical Turn-key engineers
P.O BOX 231-00507 NAIROBI
Tel: +254 728162245
Email: design@ditech.co.ke


Drawing Title

INTERMEDIATE SCREENING

NOTES

1. DRAWING TO SCALE ON A1 PAPER SIZE
2. DRAWING TO BE READ INCONJUNCTION WITH OTHER RELEVANT CIVIL, STRUCTURAL, ELECTRICAL AND MECHANICAL DRAWINGS
3. ALL DIMENSIONS AND LEVELS TO CHECKED ON SITE BEFORE COMMENCING ANY WORK. ANY DISCREPANCY TO BE REPORTED TO THE ENGINEER
4. ONLY FIGURED DIMENSIONS TO BE TAKEN FROM THIS DRAWING

REV	R E V I S I O N S			SIGN	DATE	APPROVED	Designed by		Drawn by	
		BY	CHECKED				P.K	P.K	P.K	P.K
D							Checked by	DON	Approved by	DON
C							Scales		NTS	
B							Job No.		Date: JULY 2021	
A							P STATUS		ACAD File: CE108_PL_02	
							DRG No.		FC/CE108/PL/01	
									REV	

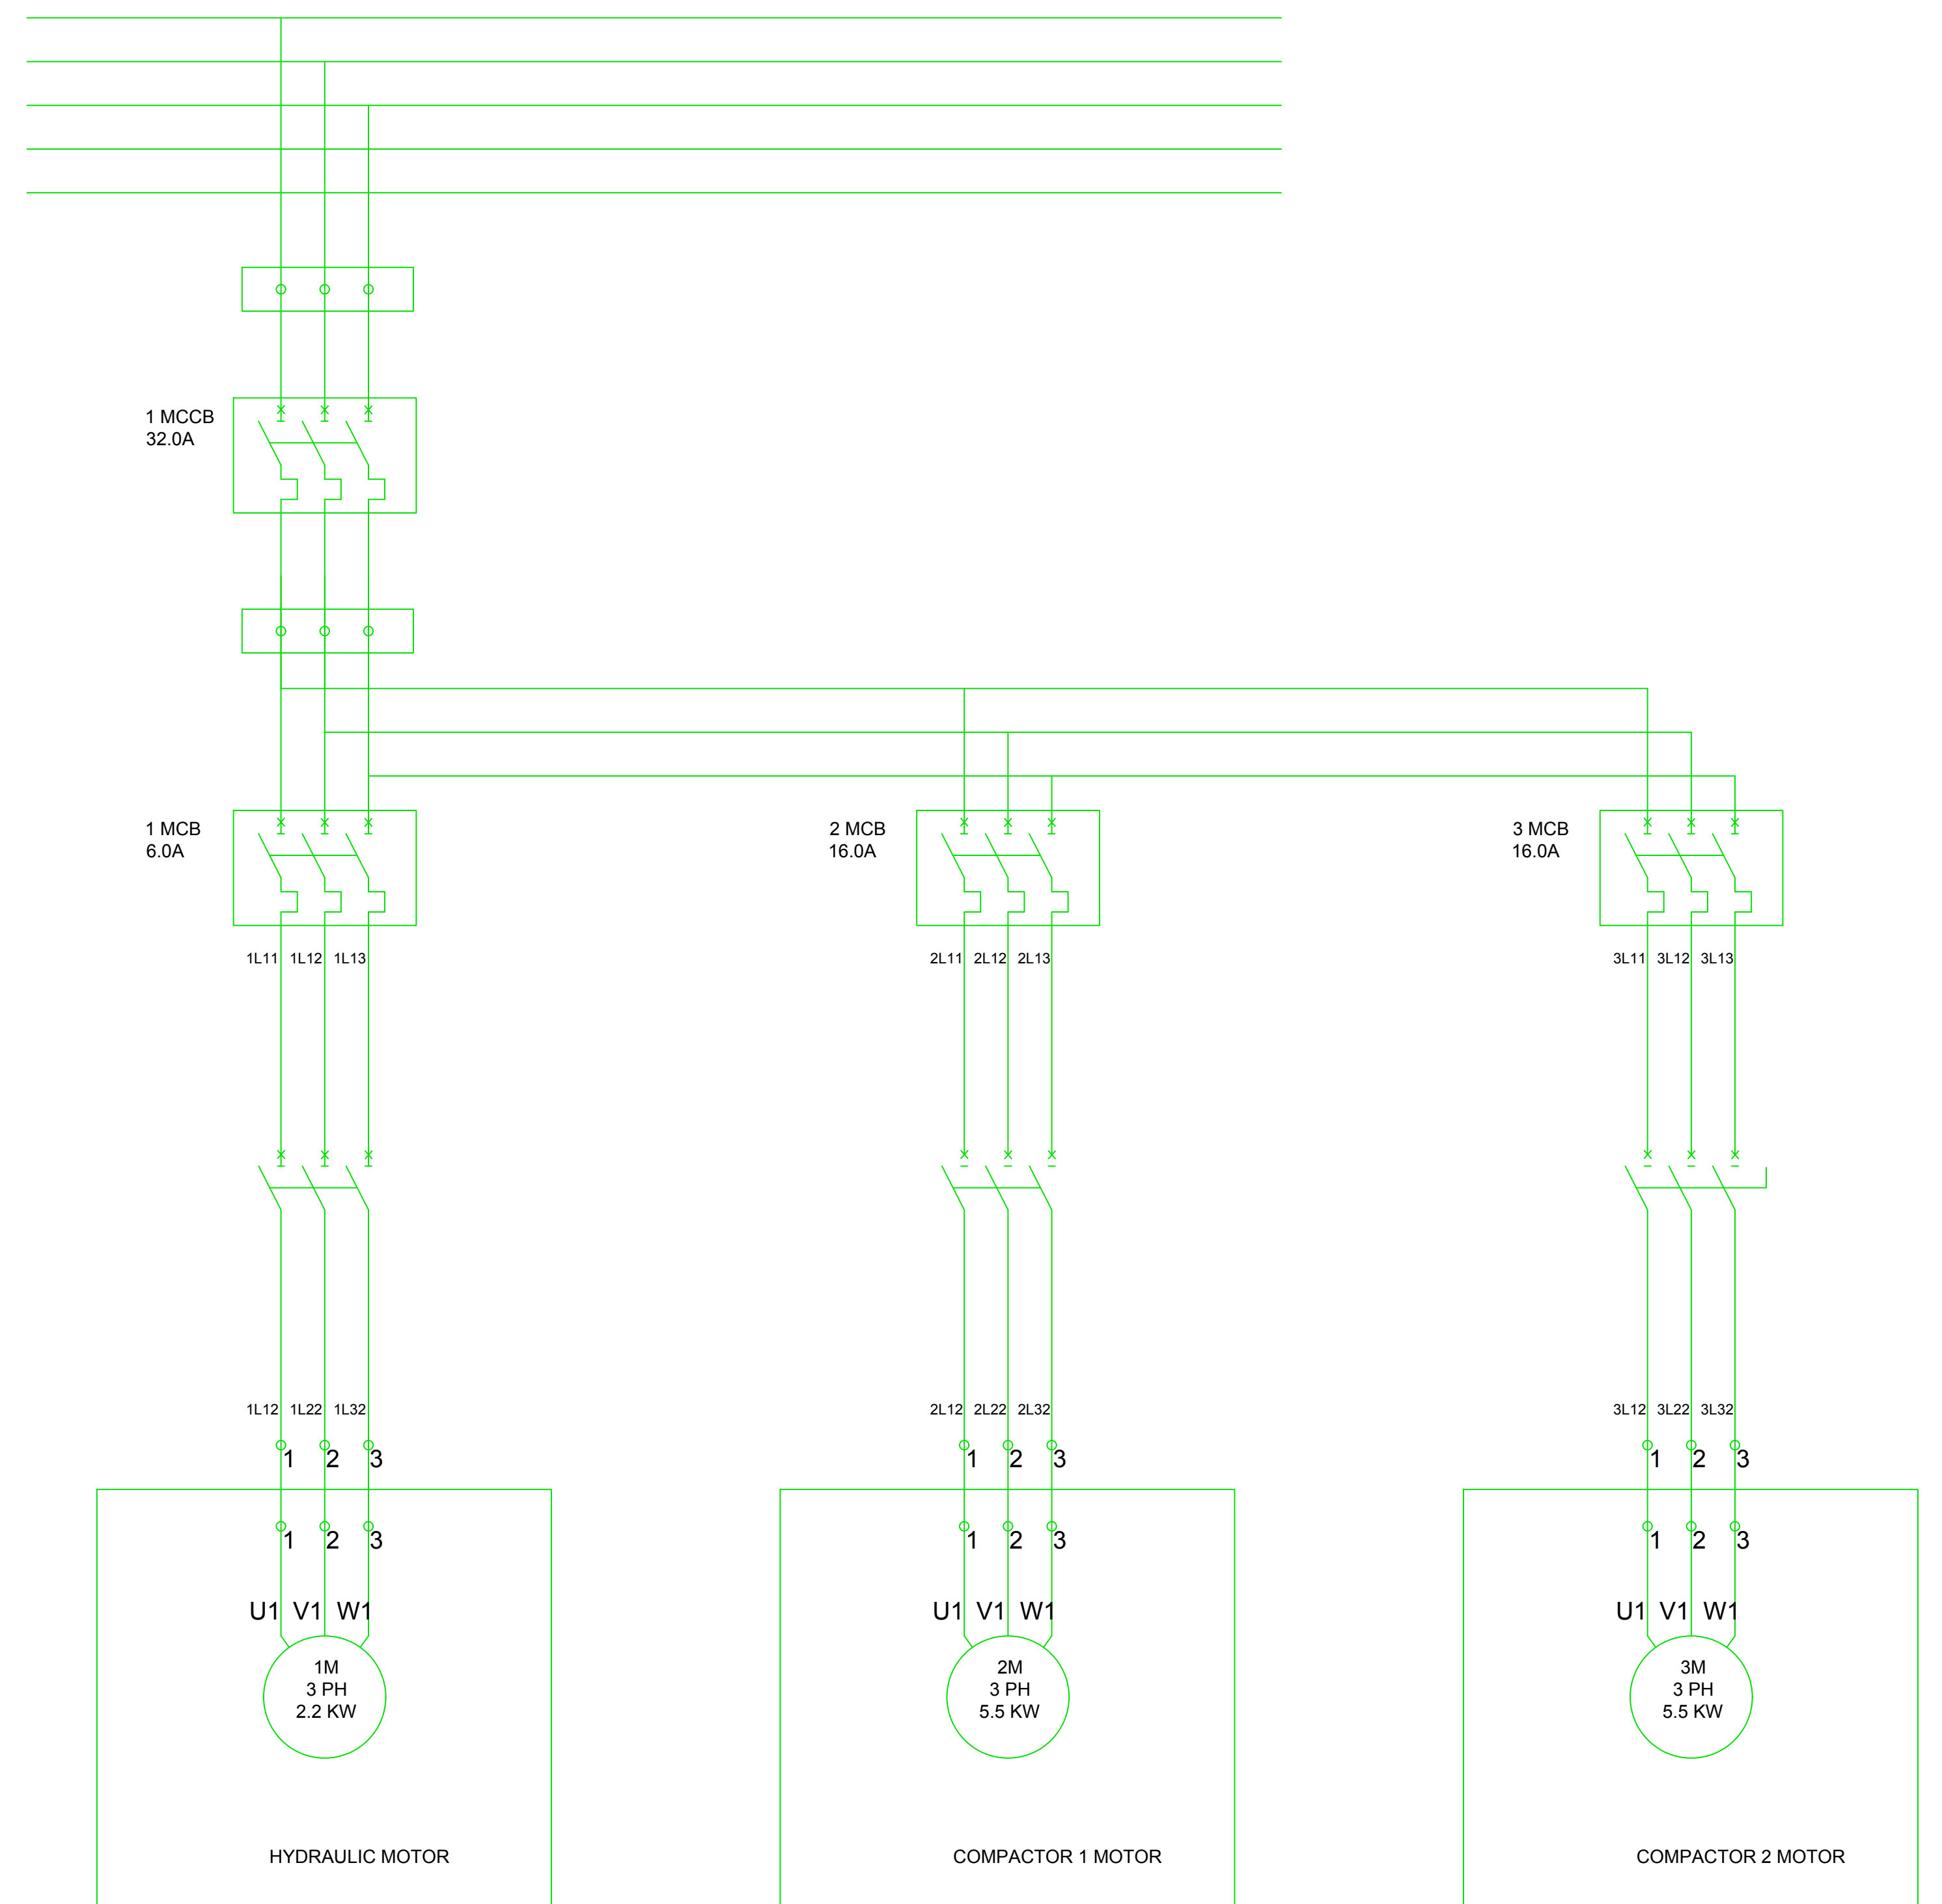





1 MCCB
16.0 A

DOL STARTER
0.5 KW

DOL STARTER
0.5 KW

DOL STARTER
0.5 KW

DOL STARTER
0.5 KW

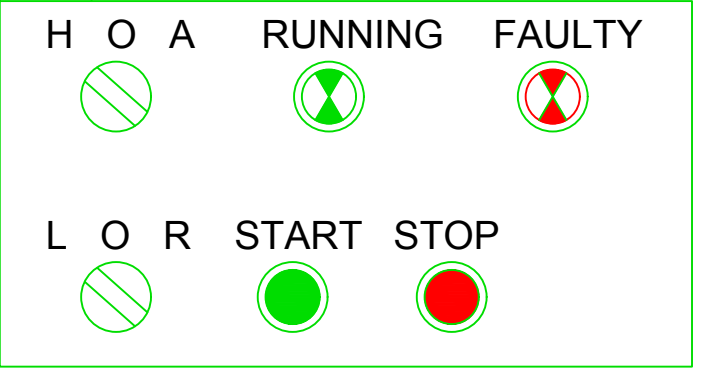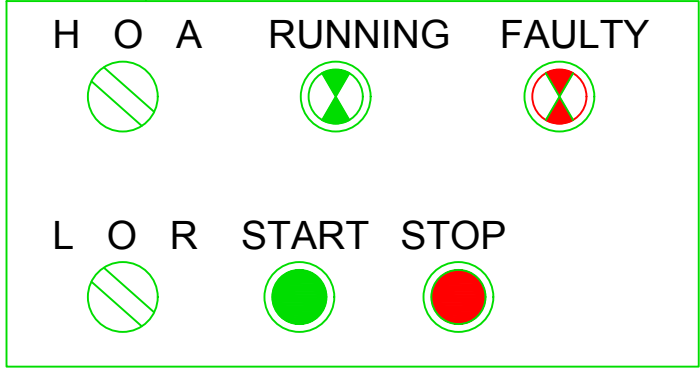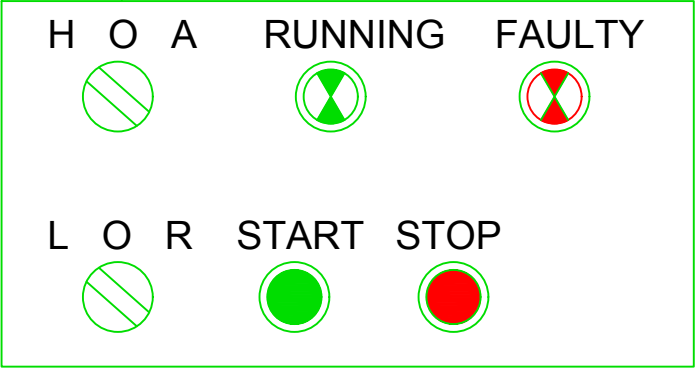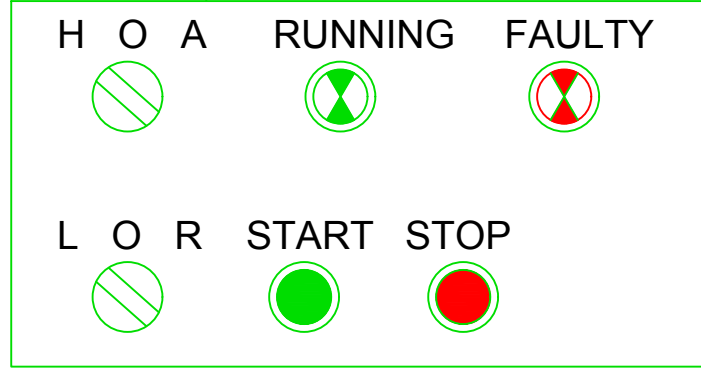

FR

FR

FR

FR

1M
3 PH
0.37 KW

2M
3 PH
0.37 KW

3M
3 PH
0.37 KW

4M
3 PH
0.37 KW

ROTOR STRAINER 1 GEAR MOTOR

ROTOR STRAINER 2 GEAR MOTOR

ROTOR STRAINER 3 GEAR MOTOR

ROTOR STRAINER 4 GEAR MOTOR

Civil Engineer:



Frame Consultants Ltd
P.O. BOX 58624-00200, NAIROBI.
TEL: 2213744, 2251505, 0720523850
E-mail: info@frameconsultants.com


Client:



ATHI WATER WORK DEVELOPMENT AGENCY
P.O BOX 45283 - 00100 NAIROBI,
Tel: +254 (0) 274292/3
Email: info@awwda.go.ke

Project:
NAIROBI RIVERS BASIN REHABILITATION AND
RESTORATION PROGRAMME- SEWERAGE
IMPROVEMENT PROJECT PHASE II (NARSIP II)
REHABILITATION AND EXPANSION OF DANDORA
ESTATE SEWERAGE TREATMENT PLANT (DESTP) INLET
WORKS

SERVICES ENGINEER:

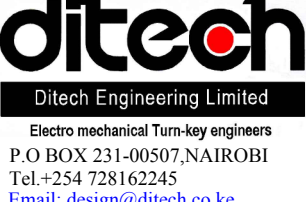

Electro Mechanical Turn-key engineers
P.O BOX 231-00507, NAIROBI
Tel: +254 728162245
Email: design@ditech.co.ke


Drawing Title:

ROTOR STRAINERS ELECTRICAL SCHEMATICS

NOTES

1. DRAWING NOT TO SCALE
2. DRAWING TO BE READ IN CONJUNCTION WITH OTHER RELEVANT CIVIL STRUCTURE, ELECTRICAL AND MECHANICAL DRAWINGS
3. ALL DIMENSIONS AND LEVELS TO BE CHECKED ON SITE BEFORE COMMENCING ANY WORK. ANY DISCREPANCY TO BE REPORTED TO THE ENGINEER
4. ONLY FIGURED IMENSIONS TO BE TAKEN FROM THIS DRAWING

REV	R E V I S I O N S		SIGN	DATE	APPROVED	Designed by DON		Drawn by E.M	
		BY				Checked by	P.M	Approved by	DON
D		CHECKED				Scales NTS		Date: SEPT 2021	
C		BY							
		CHECKED				Job No.		ACAD File:CE108_PL_02	
B		BY							
		CHECKED				P STATUS		DRG No. E01/40-3	
A		BY							
		CHECKED						REV	

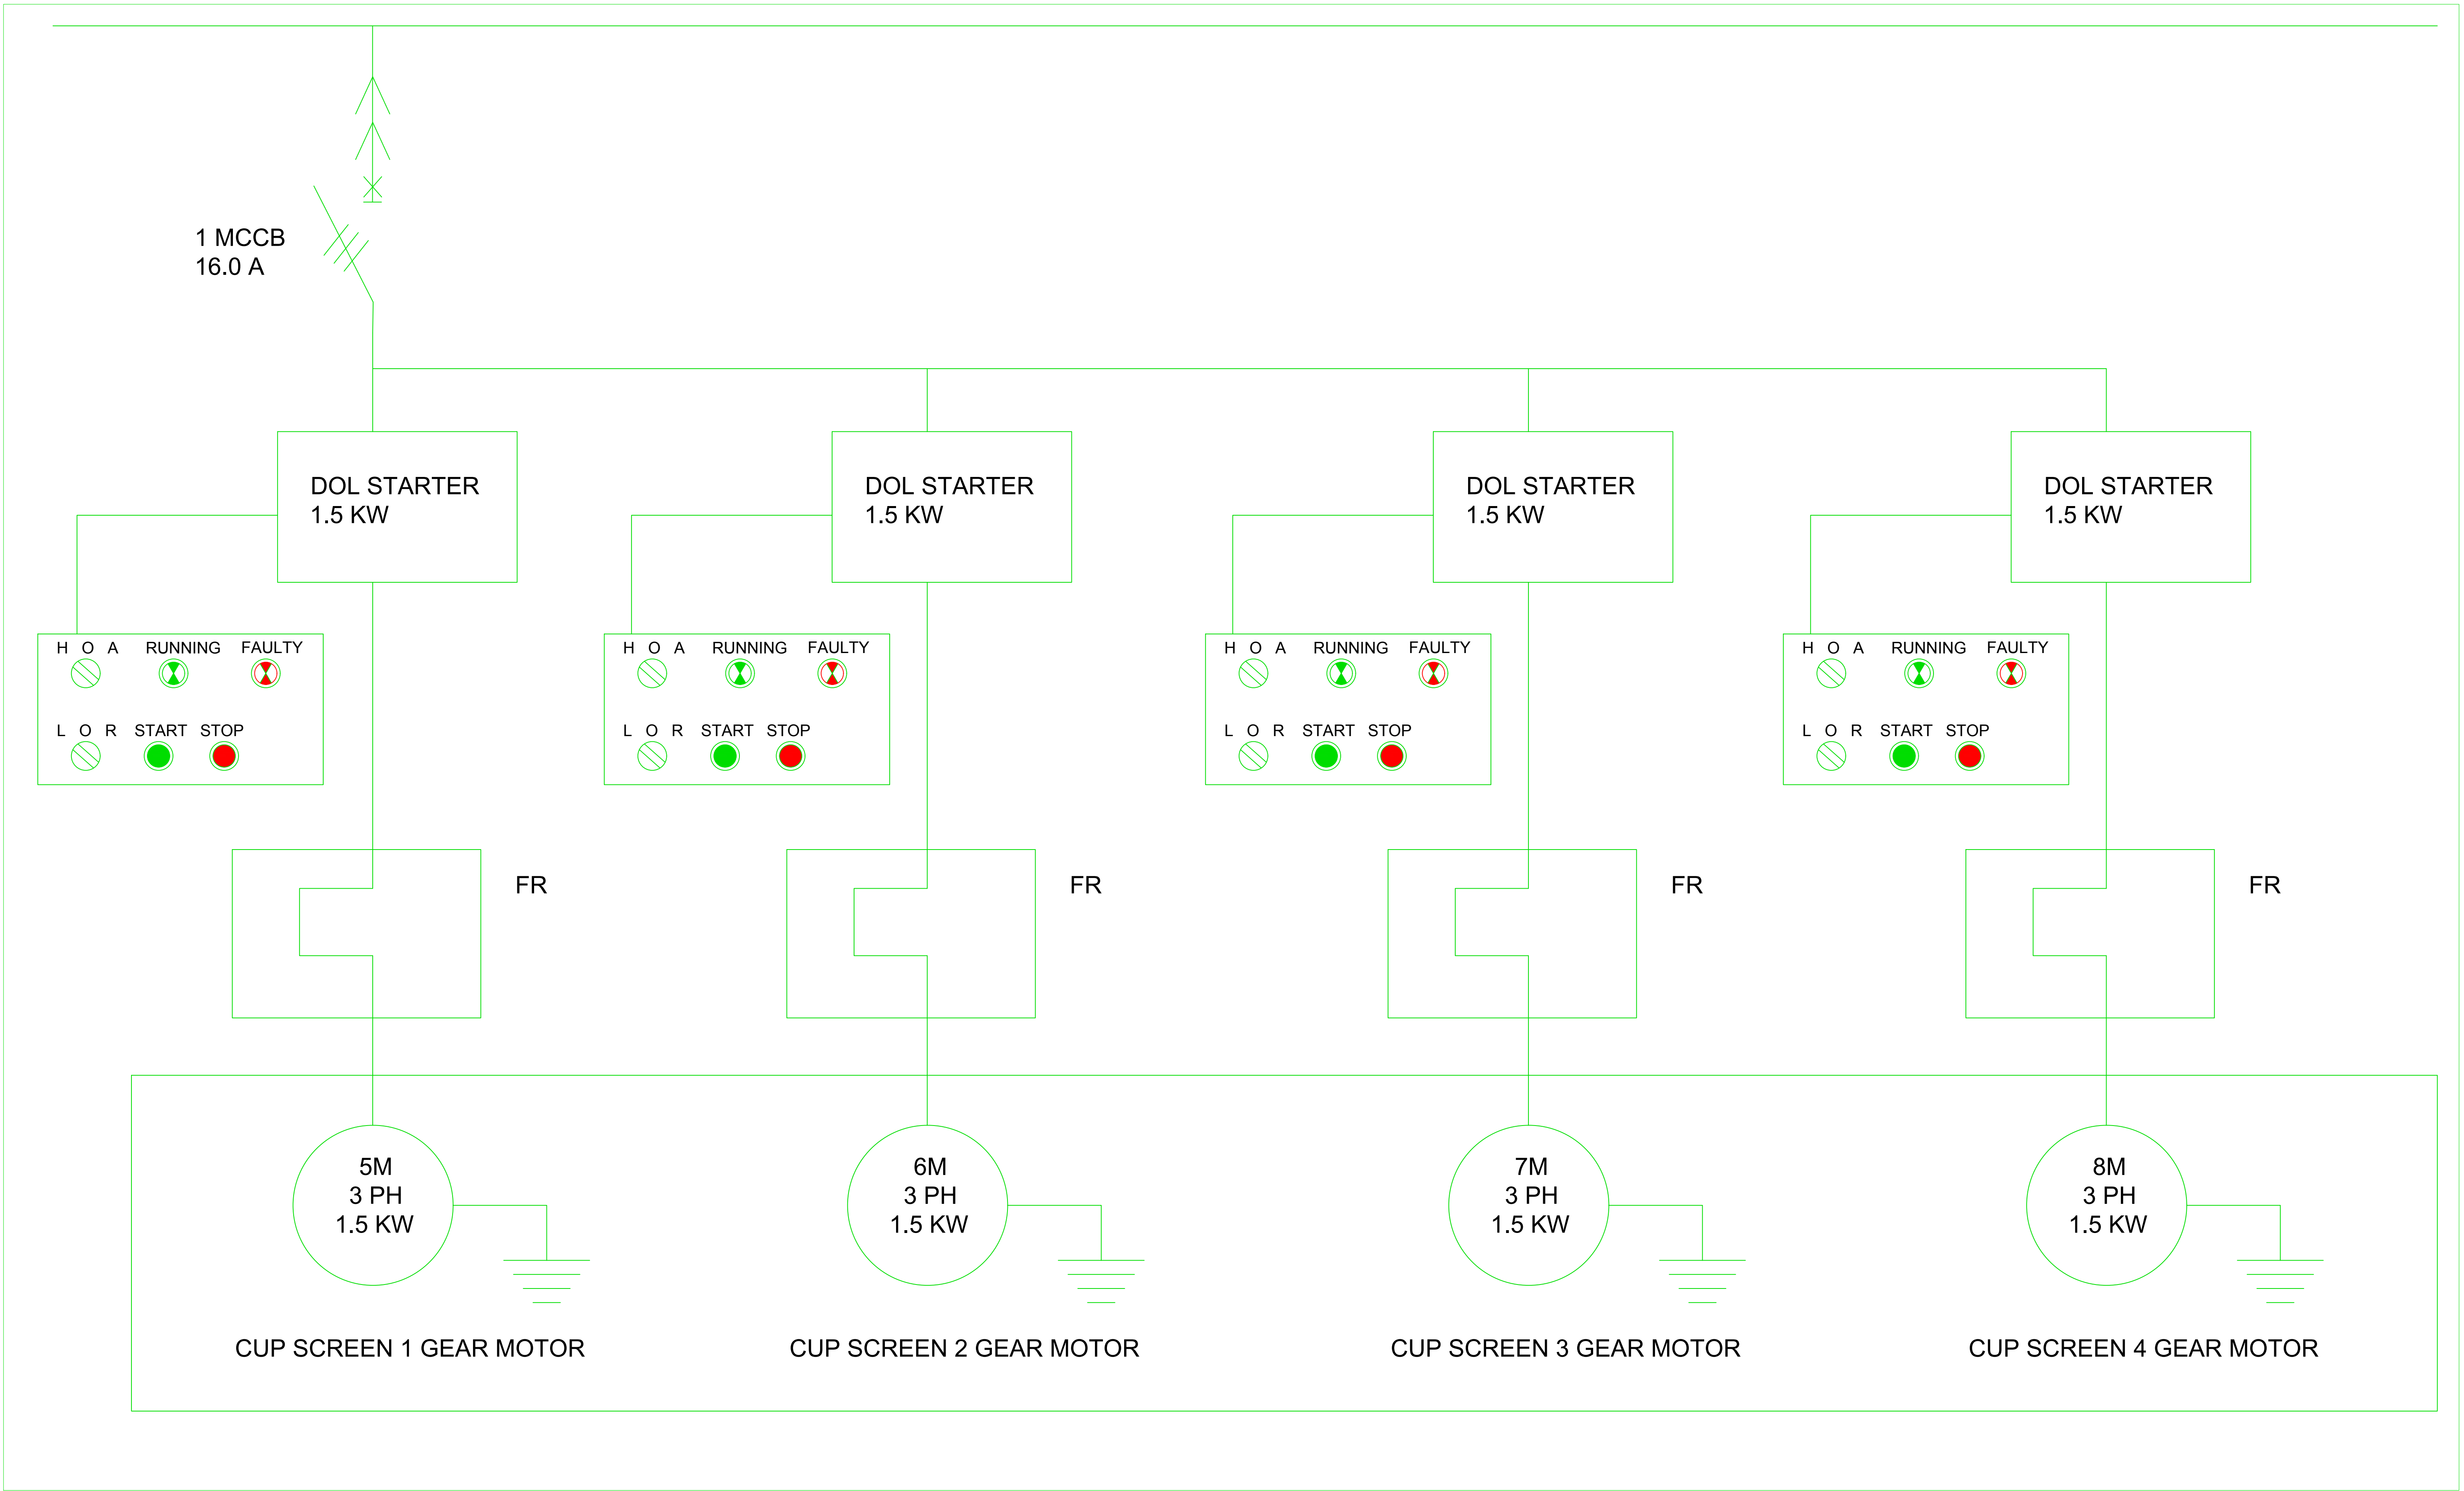

Civil Engineer:
FCL
Frame Consultants Ltd.
P.O. BOX 58624-00200, NAIROBI.
TEL: 2213744, 2251505, 0720523850
E-mail: info@frameconsultants.com

Client:
ATHI WATER WORKS
ATHI WATER WORK DEVELOPMENT AGENCY
P.O BOX 45383 - 00100 NAIROBI,
Tel: +254 (0) 274292/3
Email: info@awwds.go.ke


Project:
NAIROBI RIVERS BASIN REHABILITATION AND
RESTORATION PROGRAMME: SEWERAGE
IMPROVEMENT PROJECT PHASE II (NARSIP II)
REHABILITATION AND EXPANSION OF DANDORA
ESTATE SEWERAGE TREATMENT PLANT (DESTP) INLET
WORKS

SERVICES ENGINEER:
ditech
Ditech Engineering Limited
Electro mechanical Turn-key engineers
P.O BOX 231-00507 NAIROBI
Tel: +254 728162245
Email: design@ditech.co.ke

Drawing Title:
CUP SCREEN ELECTRICAL SCHEMATICS

NOTES
1. DRAWING NOT TO SCALE
2. DRAWING TO BE READ IN CONJUNCTION WITH OTHER RELEVANT CIVIL STRUCTURE, ELECTRICAL AND MECHANICAL DRAWINGS
3. ALL DIMENSIONS AND LEVELS TO BE CHECKED ON SITE BEFORE COMMENCING ANY WORK. ANY DISCREPANCY TO BE REPORTED TO THE ENGINEER
4. ONLY FIGURED IMENSIONS TO BE TAKEN FROM THIS DRAWING

REV.	R E V I S I O N S		SIGN	DATE	APPROVED	Designed by DON	Drawn by E.M
D	BY	CHECKED				Checked by P.M	Approved by DON
C	BY	CHECKED				Scales NTS	Date: SEPT 2021
B	BY	CHECKED				Job No.	ACAD File:CE108_PL_02
A	BY	CHECKED				P STATUS	DRG No. E01/40-4
						REV	

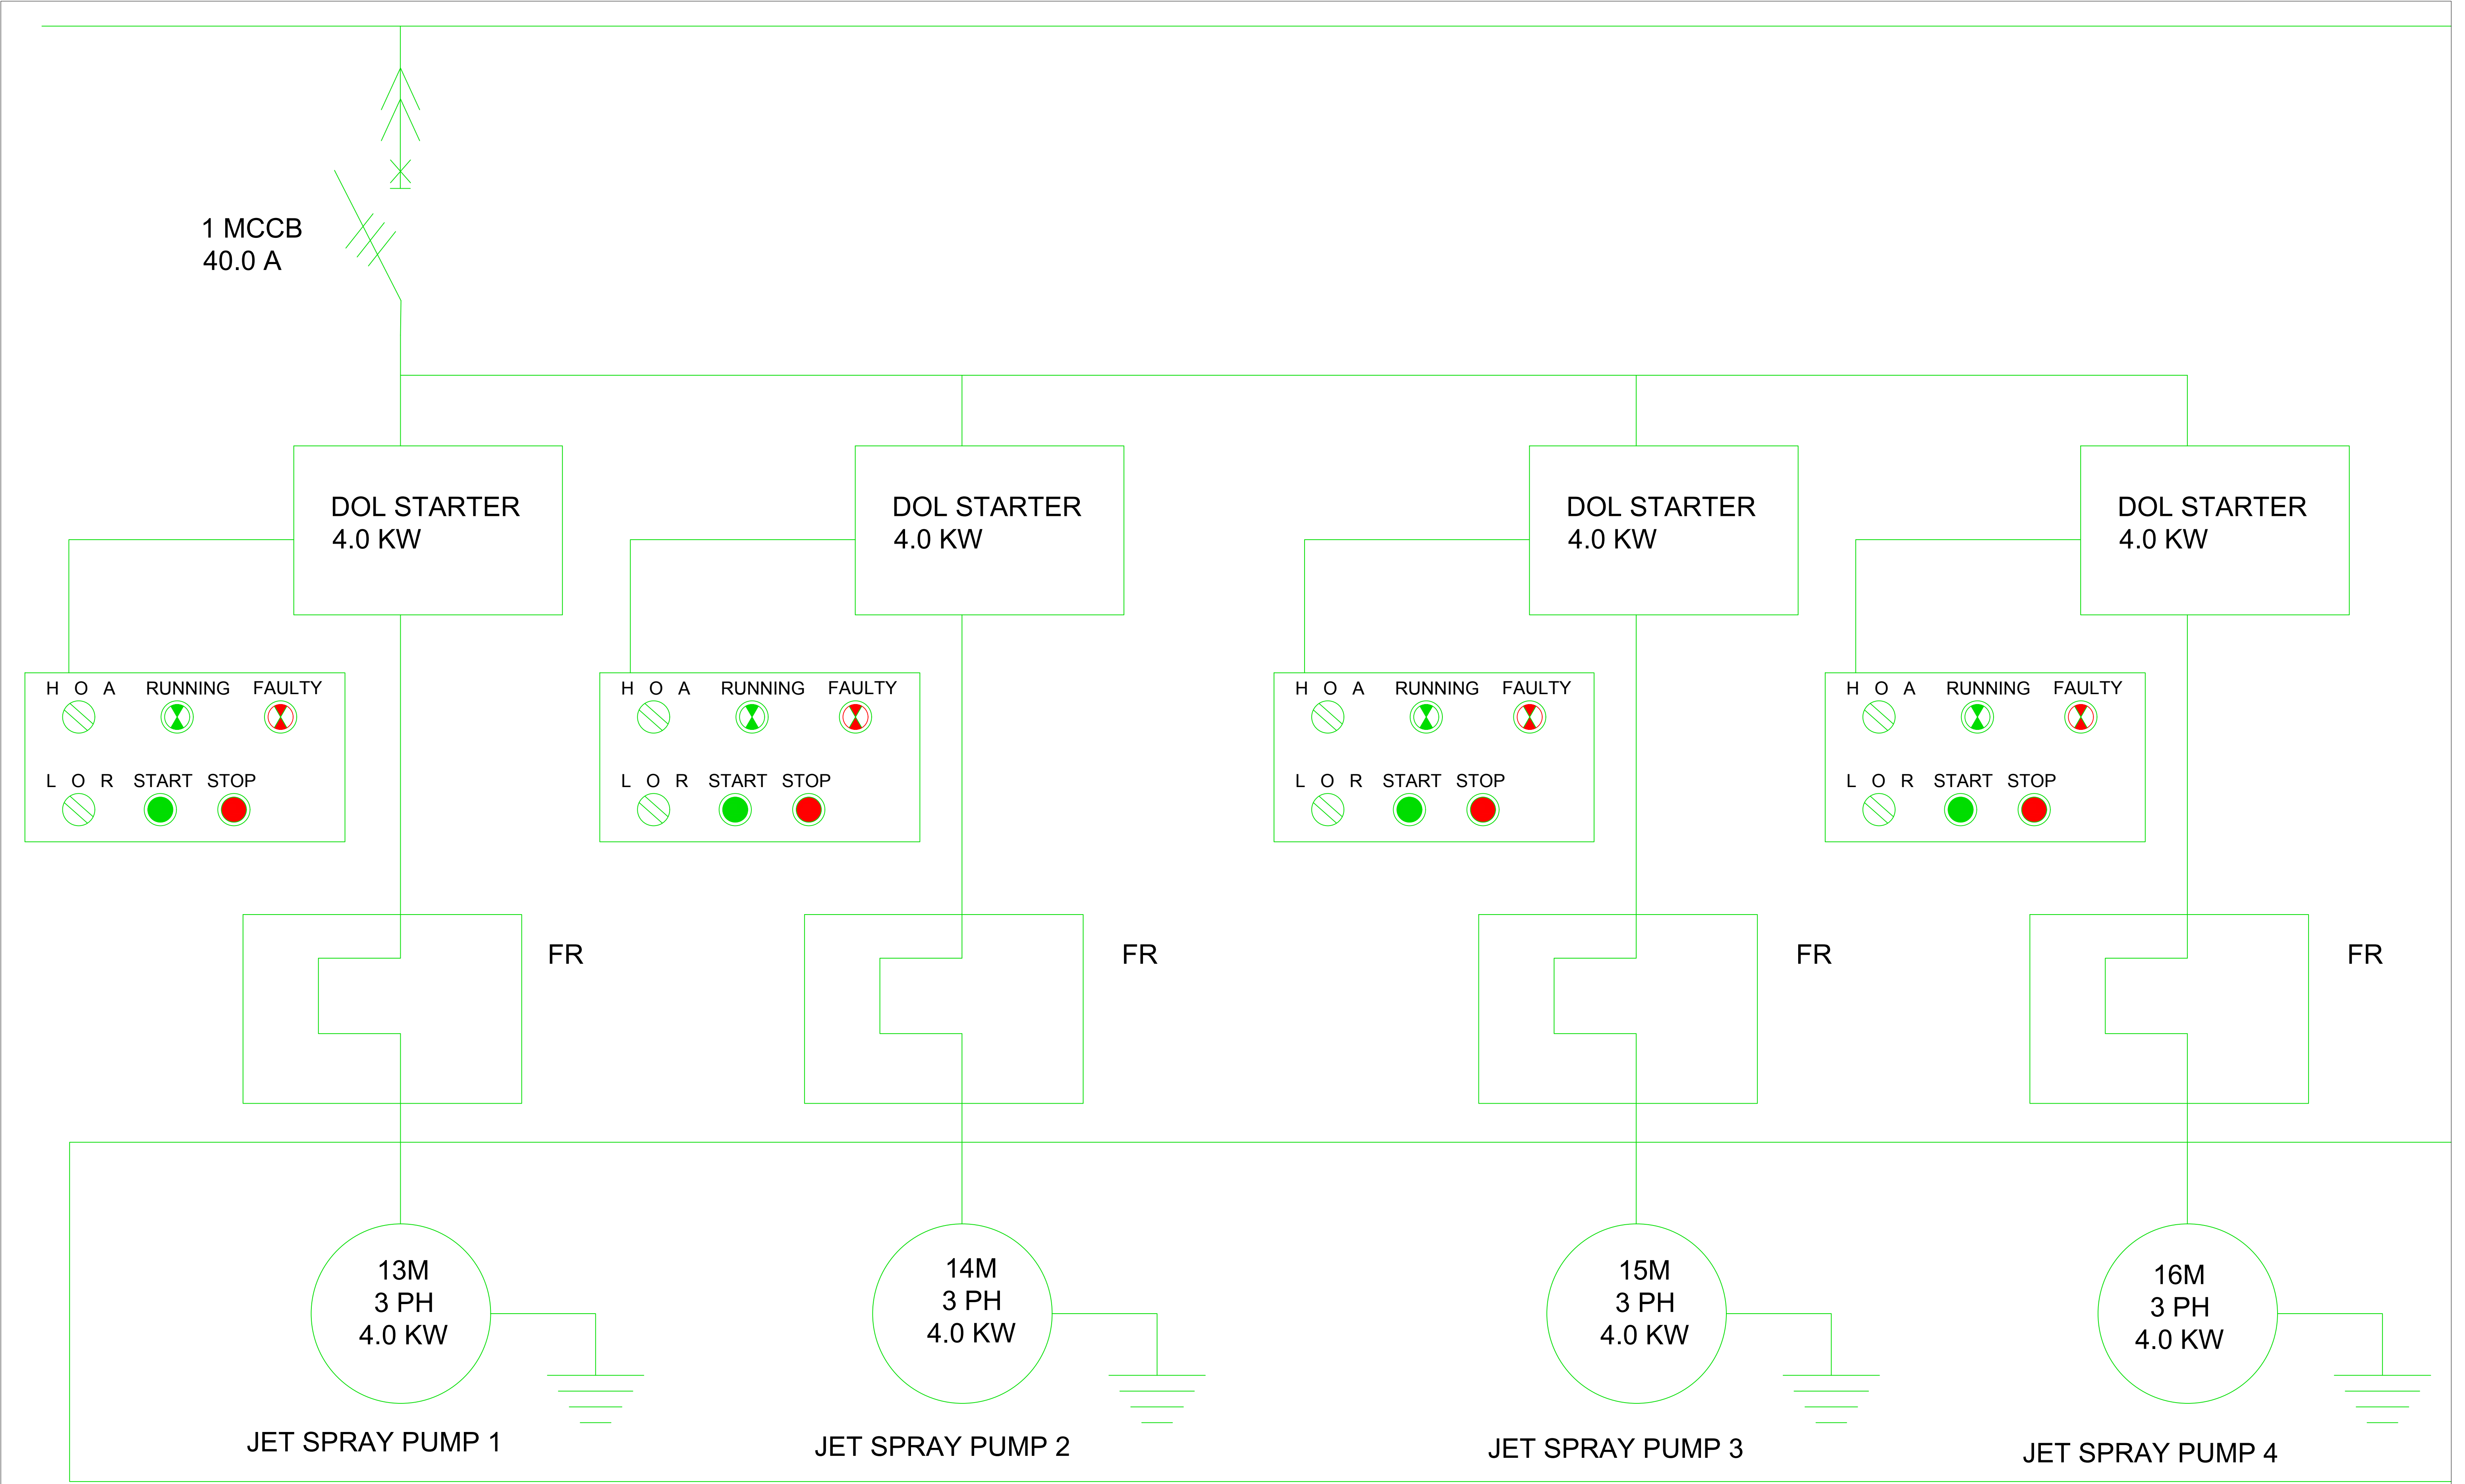

Civil Engineer:
FCL
Frame Consultants Ltd
P.O. BOX 58624-00200, NAIROBI.
TEL: 2213744, 2251505, 0720523850
E-mail: info@frameconsultants.com

Client:
ATHI WATER WORK DEVELOPMENT AGENCY
P.O BOX 45283 - 00100 NAIROBI,
Tel: +254 (0) 274292/3
Email: info@awwda.go.ke


Project:
NAIROBI RIVERS BASIN REHABILITATION AND
RESTORATION PROGRAMME: SEWERAGE
IMPROVEMENT PROJECT PHASE II (NARSIP-II)
REHABILITATION AND EXPANSION OF DANDORA
ESTATE SEWERAGE TREATMENT PLANT (DESTP) INLET
WORKS

SERVICES ENGINEER:
ditech
Ditech Engineering Limited
Electro-mechanical Turn-key engineers
P.O BOX 231-00507 NAIROBI
Tel: +254 728162245
Email: design@ditech.co.ke

Drawing Title:
JET SPRAY PUMPS ELECTRICAL SCHEMATICS

NOTES
1. DRAWING NOT TO SCALE
2. DRAWING TO BE READ IN CONJUNCTION WITH OTHER RELEVANT CIVIL STRUCTURE, ELECTRICAL AND MECHANICAL DRAWINGS
3. ALL DIMENSIONS AND LEVELS TO BE CHECKED ON SITE BEFORE COMMENCING ANY WORK. ANY DISCREPANCY TO BE REPORTED TO THE ENGINEER
4. ONLY FIGURED IMENSIONS TO BE TAKEN FROM THIS DRAWING

REV	R E V I S I O N S			SIGN	DATE	APPROVED	Designed by DON		Drawn by E.M	
	D	BY	CHECKED				Checked by	P.M	Approved by	DON
C		BY	CHECKED				Scales NTS		Date: SEPT 2021	
B		BY	CHECKED				Job No.		ACAD File:CE108_PL_02	
A		BY	CHECKED				P STATUS	DRG No. E01/40-6		REV

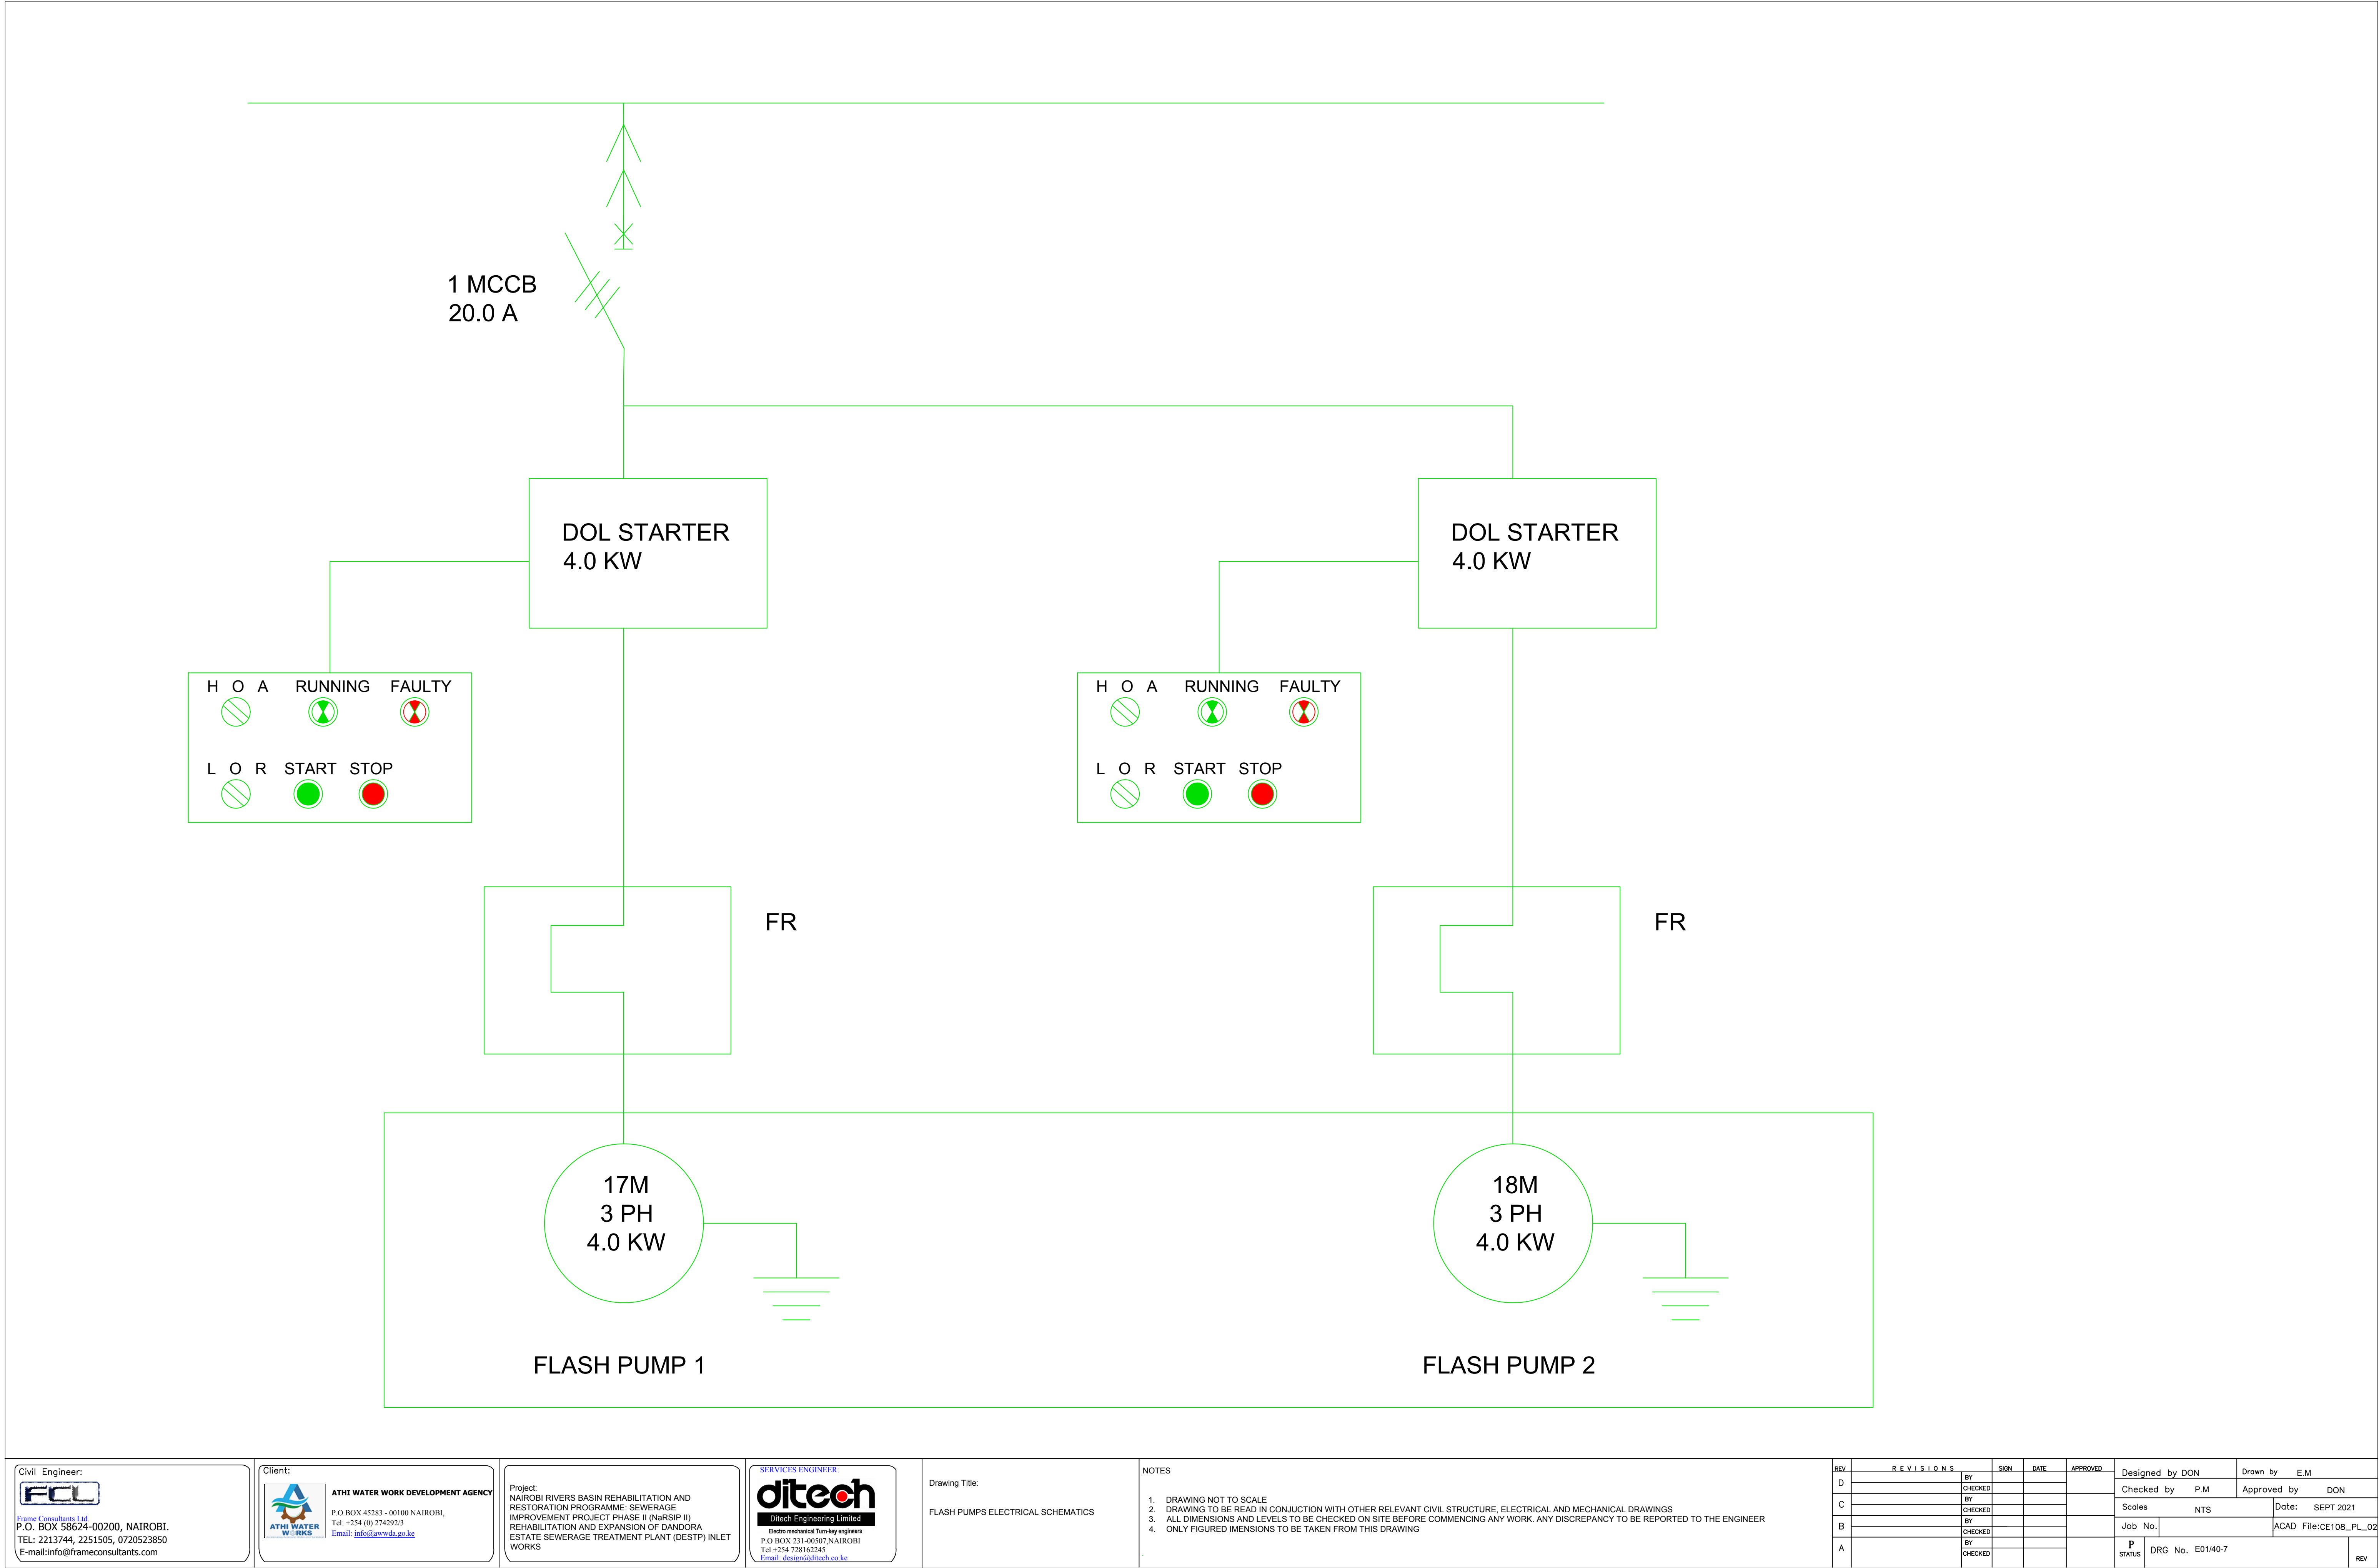

Civil Engineer:



Frame Consultants Ltd.
P.O. BOX 58624-00200, NAIROBI.
TEL: 2213744, 2251505, 0720523850
E-mail: info@frameconsultants.com


Client:



ATHI WATER WORK DEVELOPMENT AGENCY
P.O BOX 45283 - 00100 NAIROBI,
Tel: +254 (0) 274292/3
Email: info@awwda.go.ke

Project:
NAIROBI RIVERS BASIN REHABILITATION AND
RESTORATION PROGRAMME: SEWERAGE
IMPROVEMENT PROJECT PHASE II (NARSIP II)
REHABILITATION AND EXPANSION OF DANDORA
ESTATE SEWERAGE TREATMENT PLANT (DESTP) INLET
WORKS

SERVICES ENGINEER:

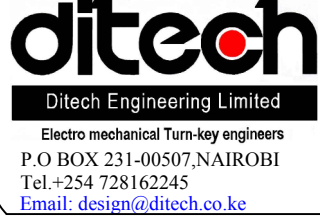


Drawing Title:



FLASH PUMPS ELECTRICAL SCHEMATICS

NOTES


1. DRAWING NOT TO SCALE
2. DRAWING TO BE READ IN CONJUNCTION WITH OTHER RELEVANT CIVIL STRUCTURE, ELECTRICAL AND MECHANICAL DRAWINGS
3. ALL DIMENSIONS AND LEVELS TO BE CHECKED ON SITE BEFORE COMMENCING ANY WORK. ANY DISCREPANCY TO BE REPORTED TO THE ENGINEER
4. ONLY FIGURED IMENSIONS TO BE TAKEN FROM THIS DRAWING

REV	R E V I S I O N S		SIGN	DATE	APPROVED	Designed by DON		Drawn by E.M	
D		BY				Checked by P.M		Approved by DON	
C		CHECKED BY				Scales NTS		Date:	SEPT 2021
B		BY				Job No.		ACAD File:CE108_PL_02	
A		CHECKED BY				P STATUS DRG No. E01/40-7		REV	

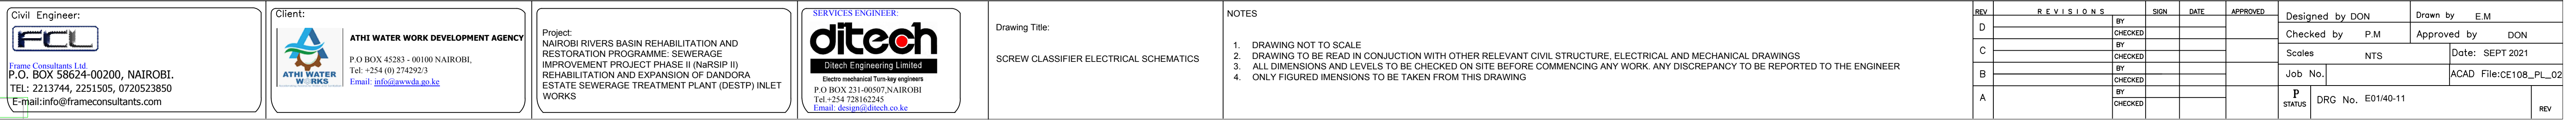

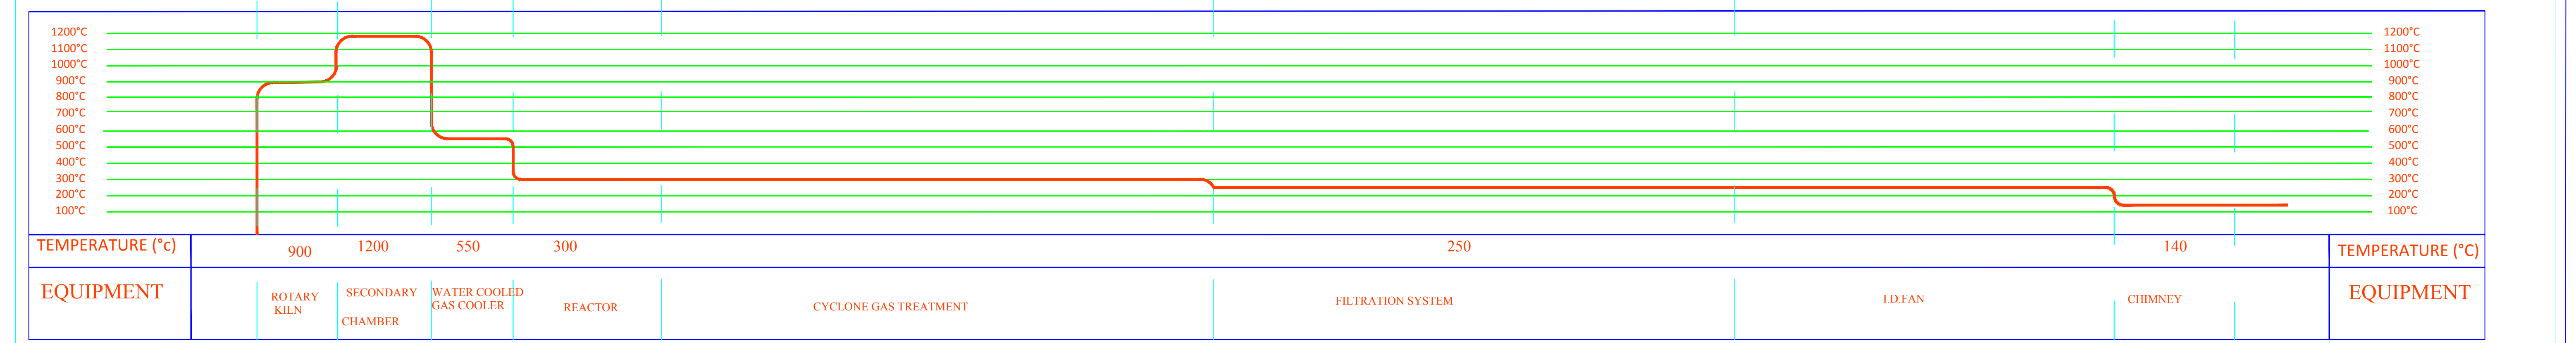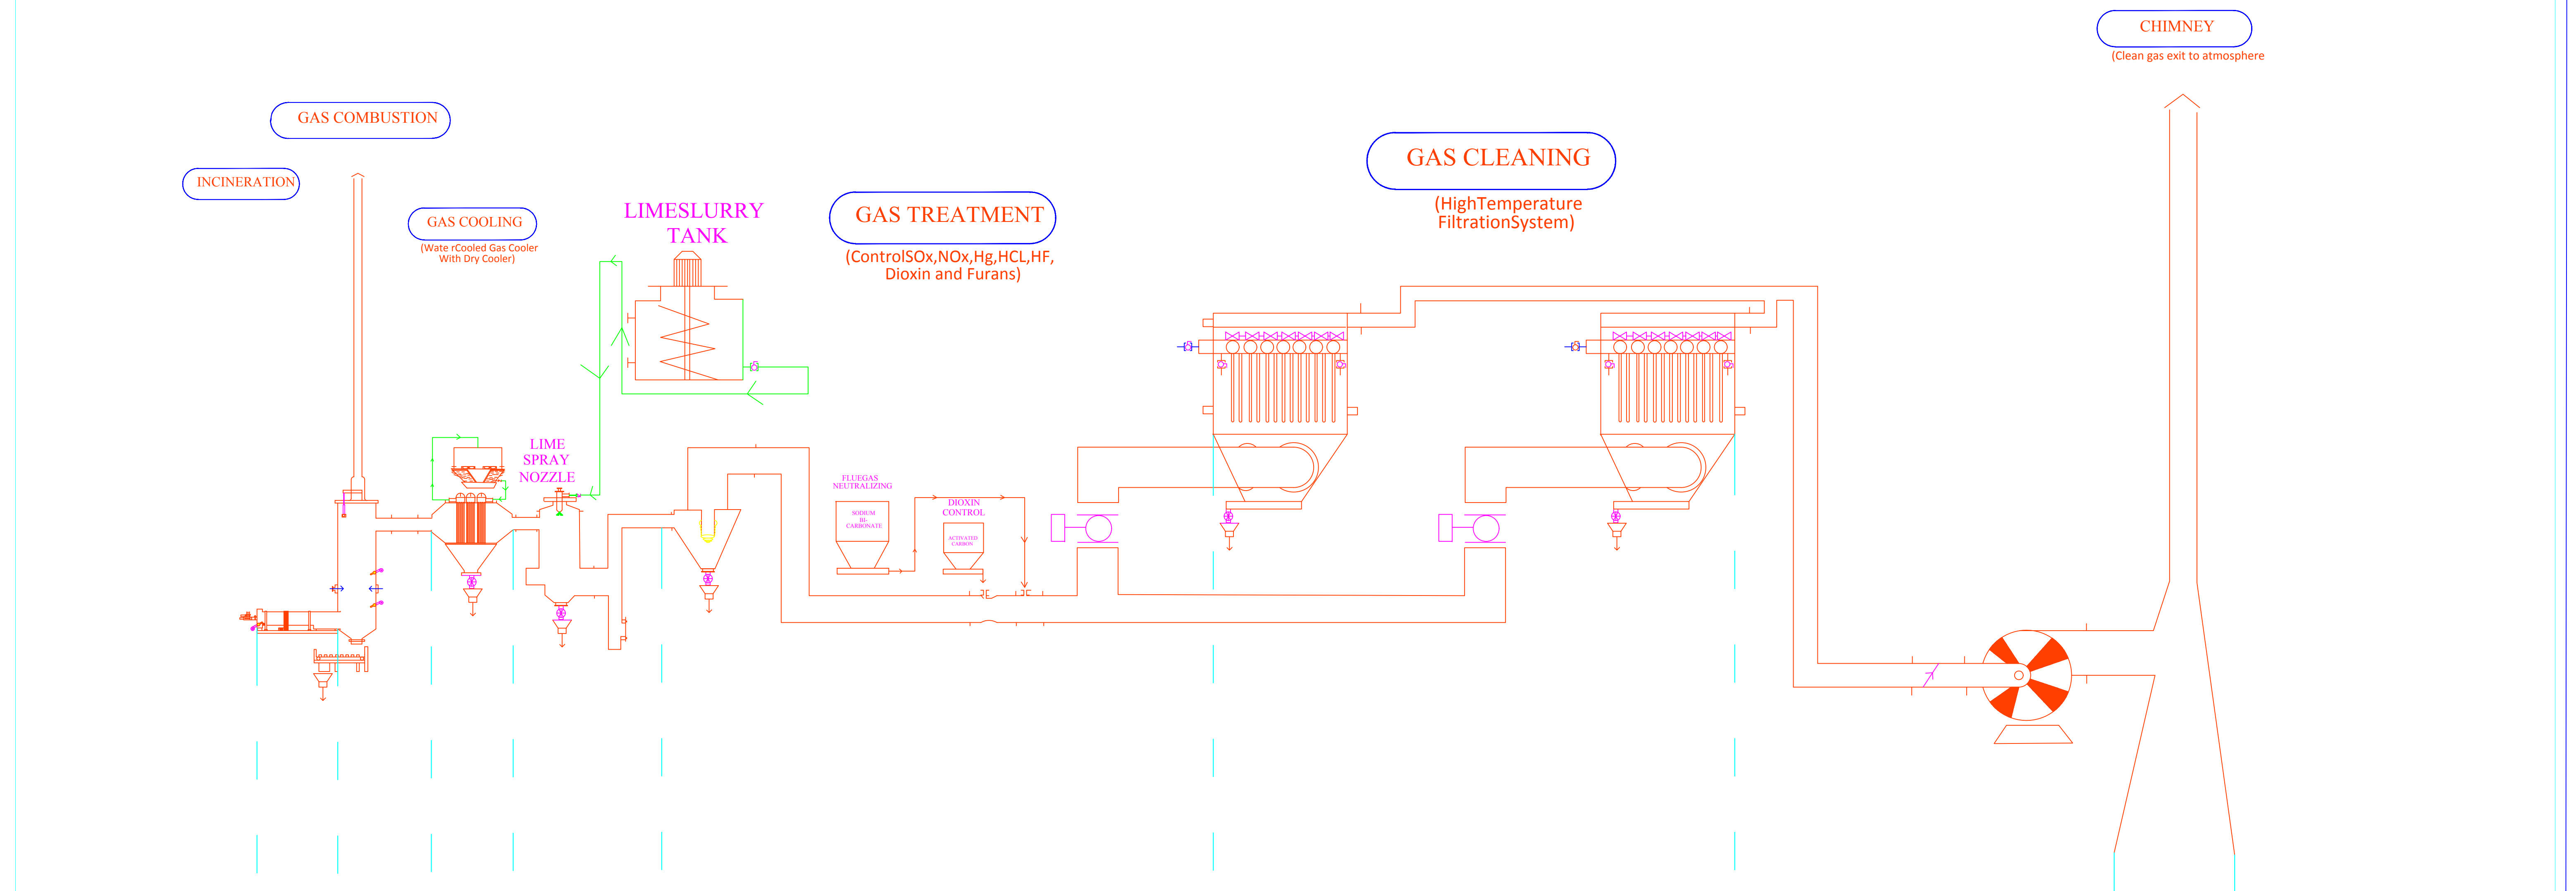

SCHEMATIC REPRESENTATION OF ROTARY KILN INCINERATOR WITH FLUE GAS TREATMENT

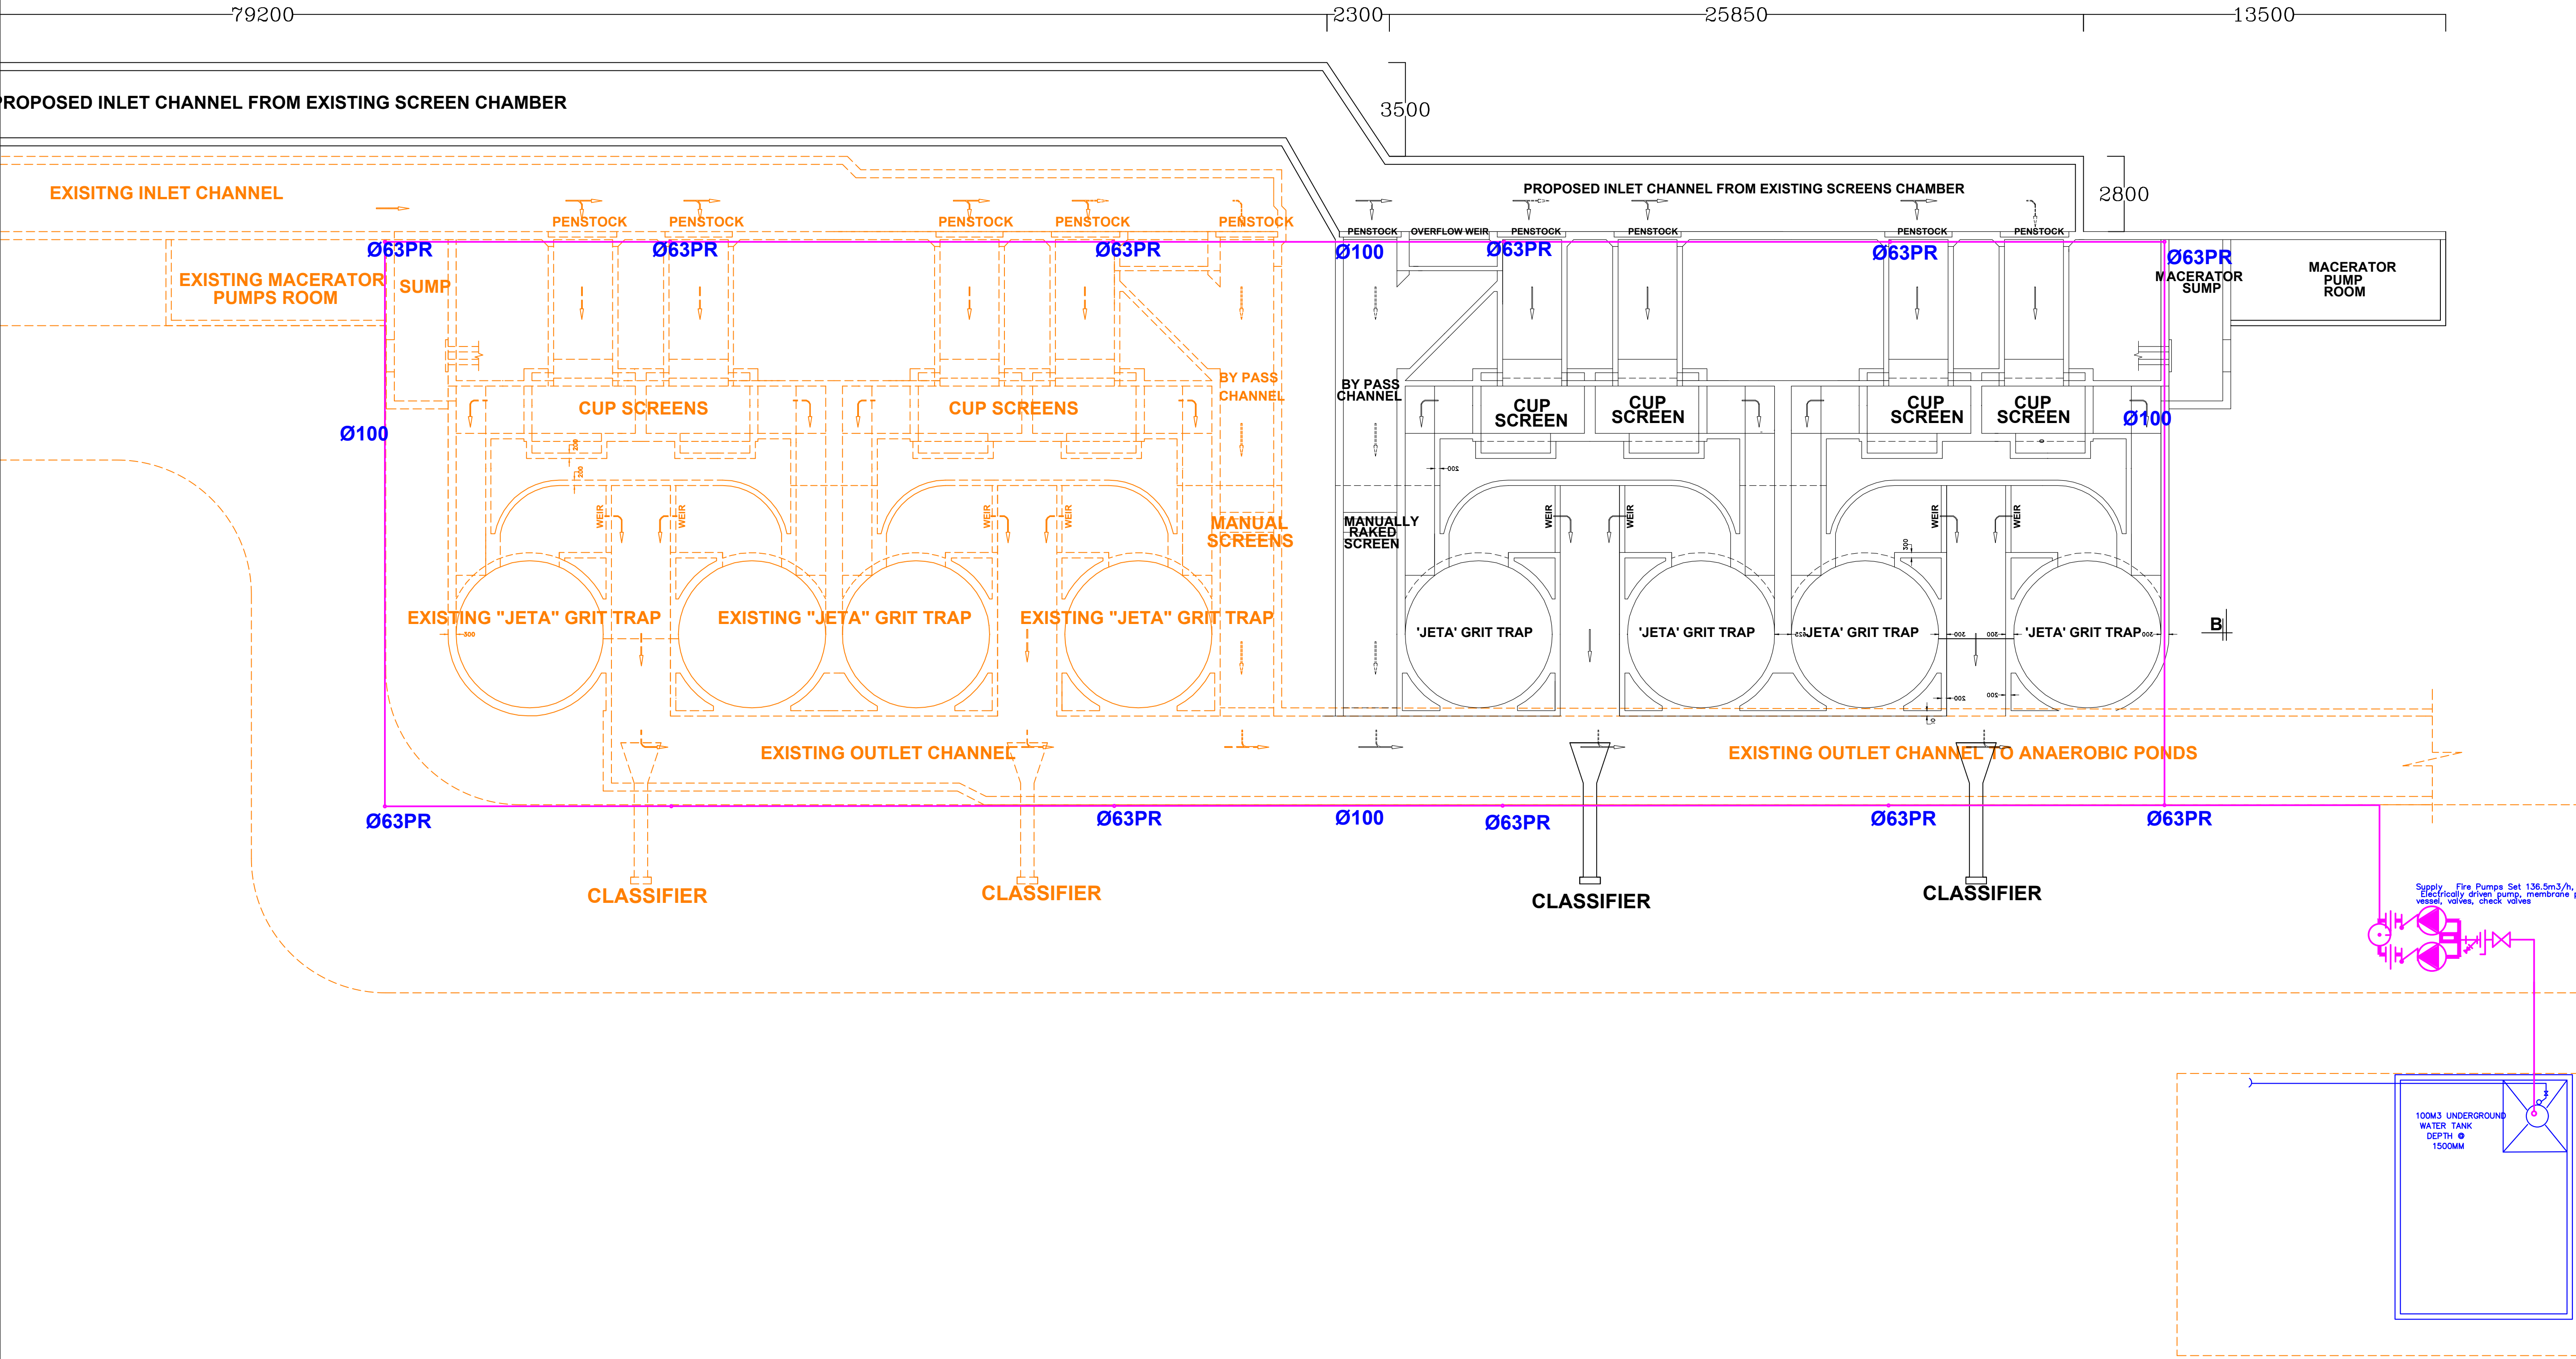

Civil Engineer:



Frame Consultants Ltd
P.O. BOX 58624-00200, NAIROBI.
TEL: 2213744, 2251505, 0720523850
Email: info@frameconsultants.com

Client:



ATHI WATER WORK DEVELOPMENT AGENCY
P.O BOX 45283 - 00100 NAIROBI,
Tel: +254 (0) 274292/3
Email: info@awwa.co.ke

Project:
NAIROBI RIVERS BASIN REHABILITATION AND
RESTORATION PROGRAMME: SEWERAGE
IMPROVEMENT PROJECT PHASE II (NARSIP II)
REHABILITATION AND EXPANSION OF DANDORA
ESTATE SEWERAGE TREATMENT PLANT (DESTP) INLET
WORKS

SERVICES ENGINEER:



Ditech Engineering Limited
Electro-mechanical Turn-key engineers
P.O BOX 231-00507, NAIROBI
Tel: +254 728162245
Email: design@ditech.co.ke


Drawing Title:

DESTP PROPOSED FIRE HYDRANTS LAYOUT


NOTES

1. DRAWING NOT TO SCALE
2. DRAWING TO BE READ IN CONJUNCTION WITH OTHER RELEVANT CIVIL STRUCTURE, ELECTRICAL AND MECHANICAL DRAWINGS
3. ALL DIMENSIONS AND LEVELS TO BE CHECKED ON SITE BEFORE COMMENCING ANY WORK. ANY DISCREPANCY TO BE REPORTED TO THE ENGINEER
4. ONLY FIGURED DIMENSIONS TO BE TAKEN FROM THIS DRAWING

REV	R E V I S I O N S			SIGN	DATE	APPROVED	Designed by DON		Drawn by E.M	
D		BY					Checked by P.M		Approved by DON	
C		CHECKED					Scales		Date: SEPT 2021	
B		BY					Job No.		ACAD File:CE108_PL_02	
A		CHECKED					P STATUS	DRG No. E0140-14		REV

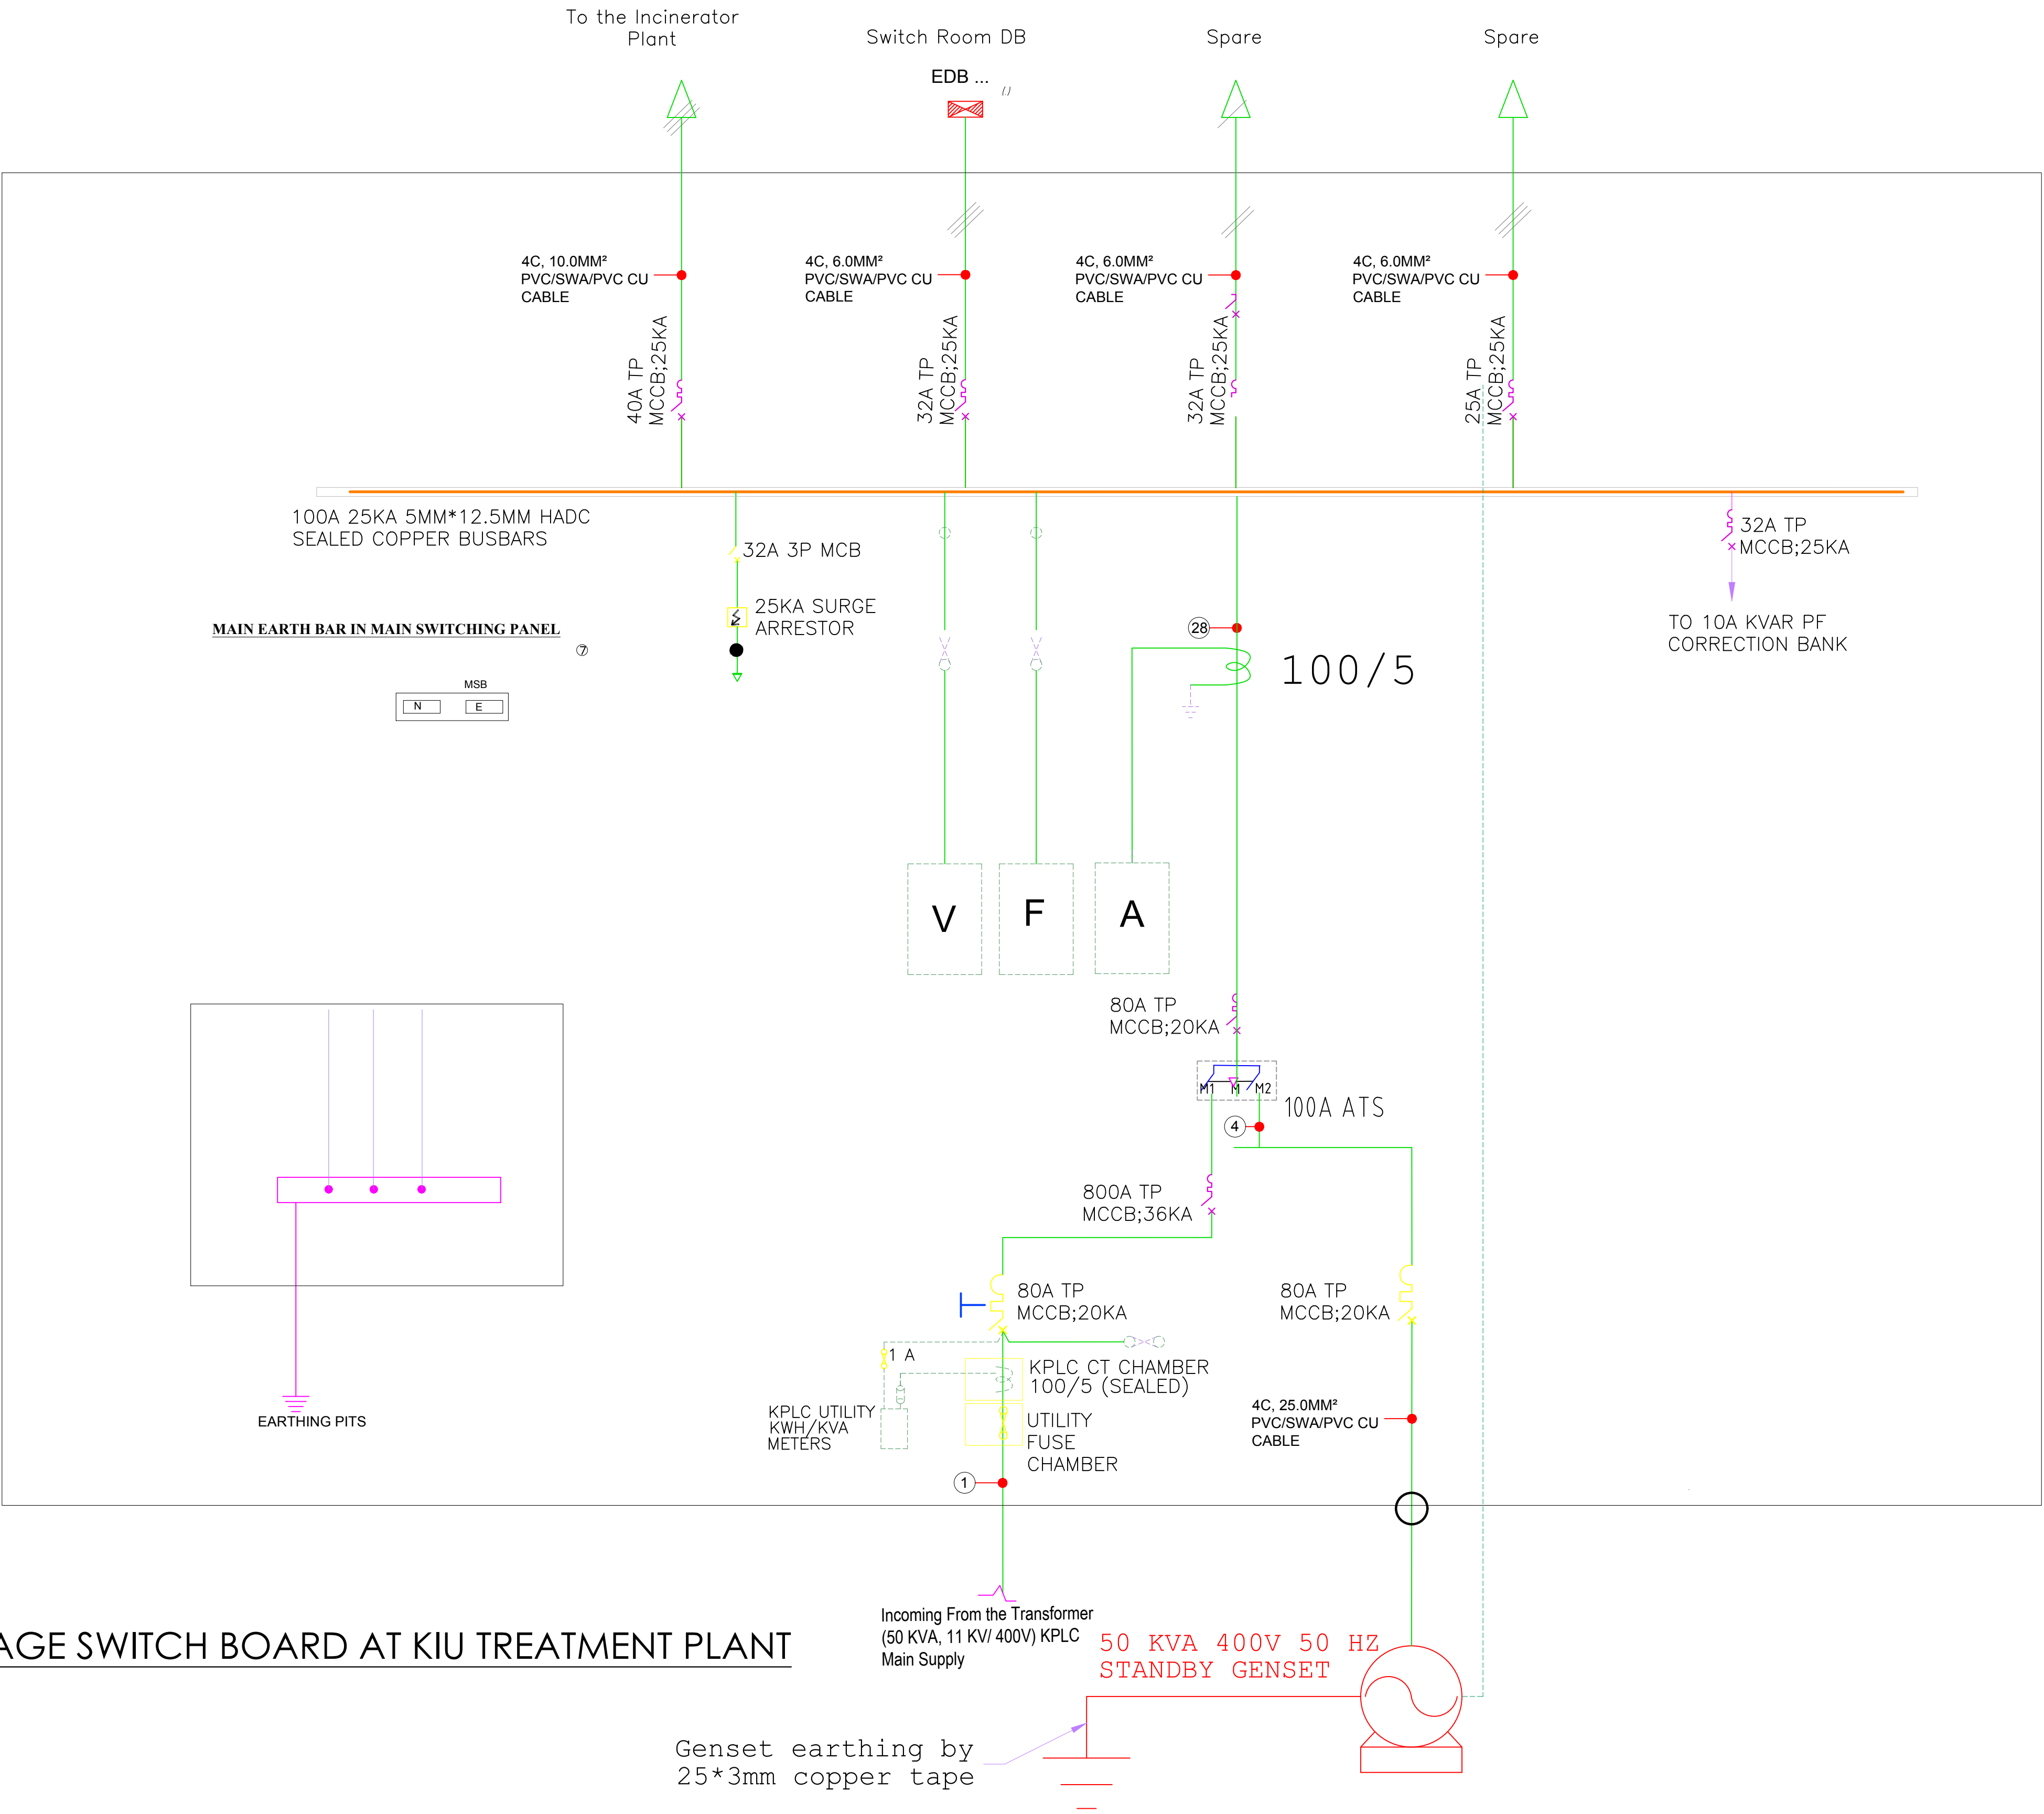

LOW VOLTAGE SWITCH BOARD AT KIU TREATMENT PLANT

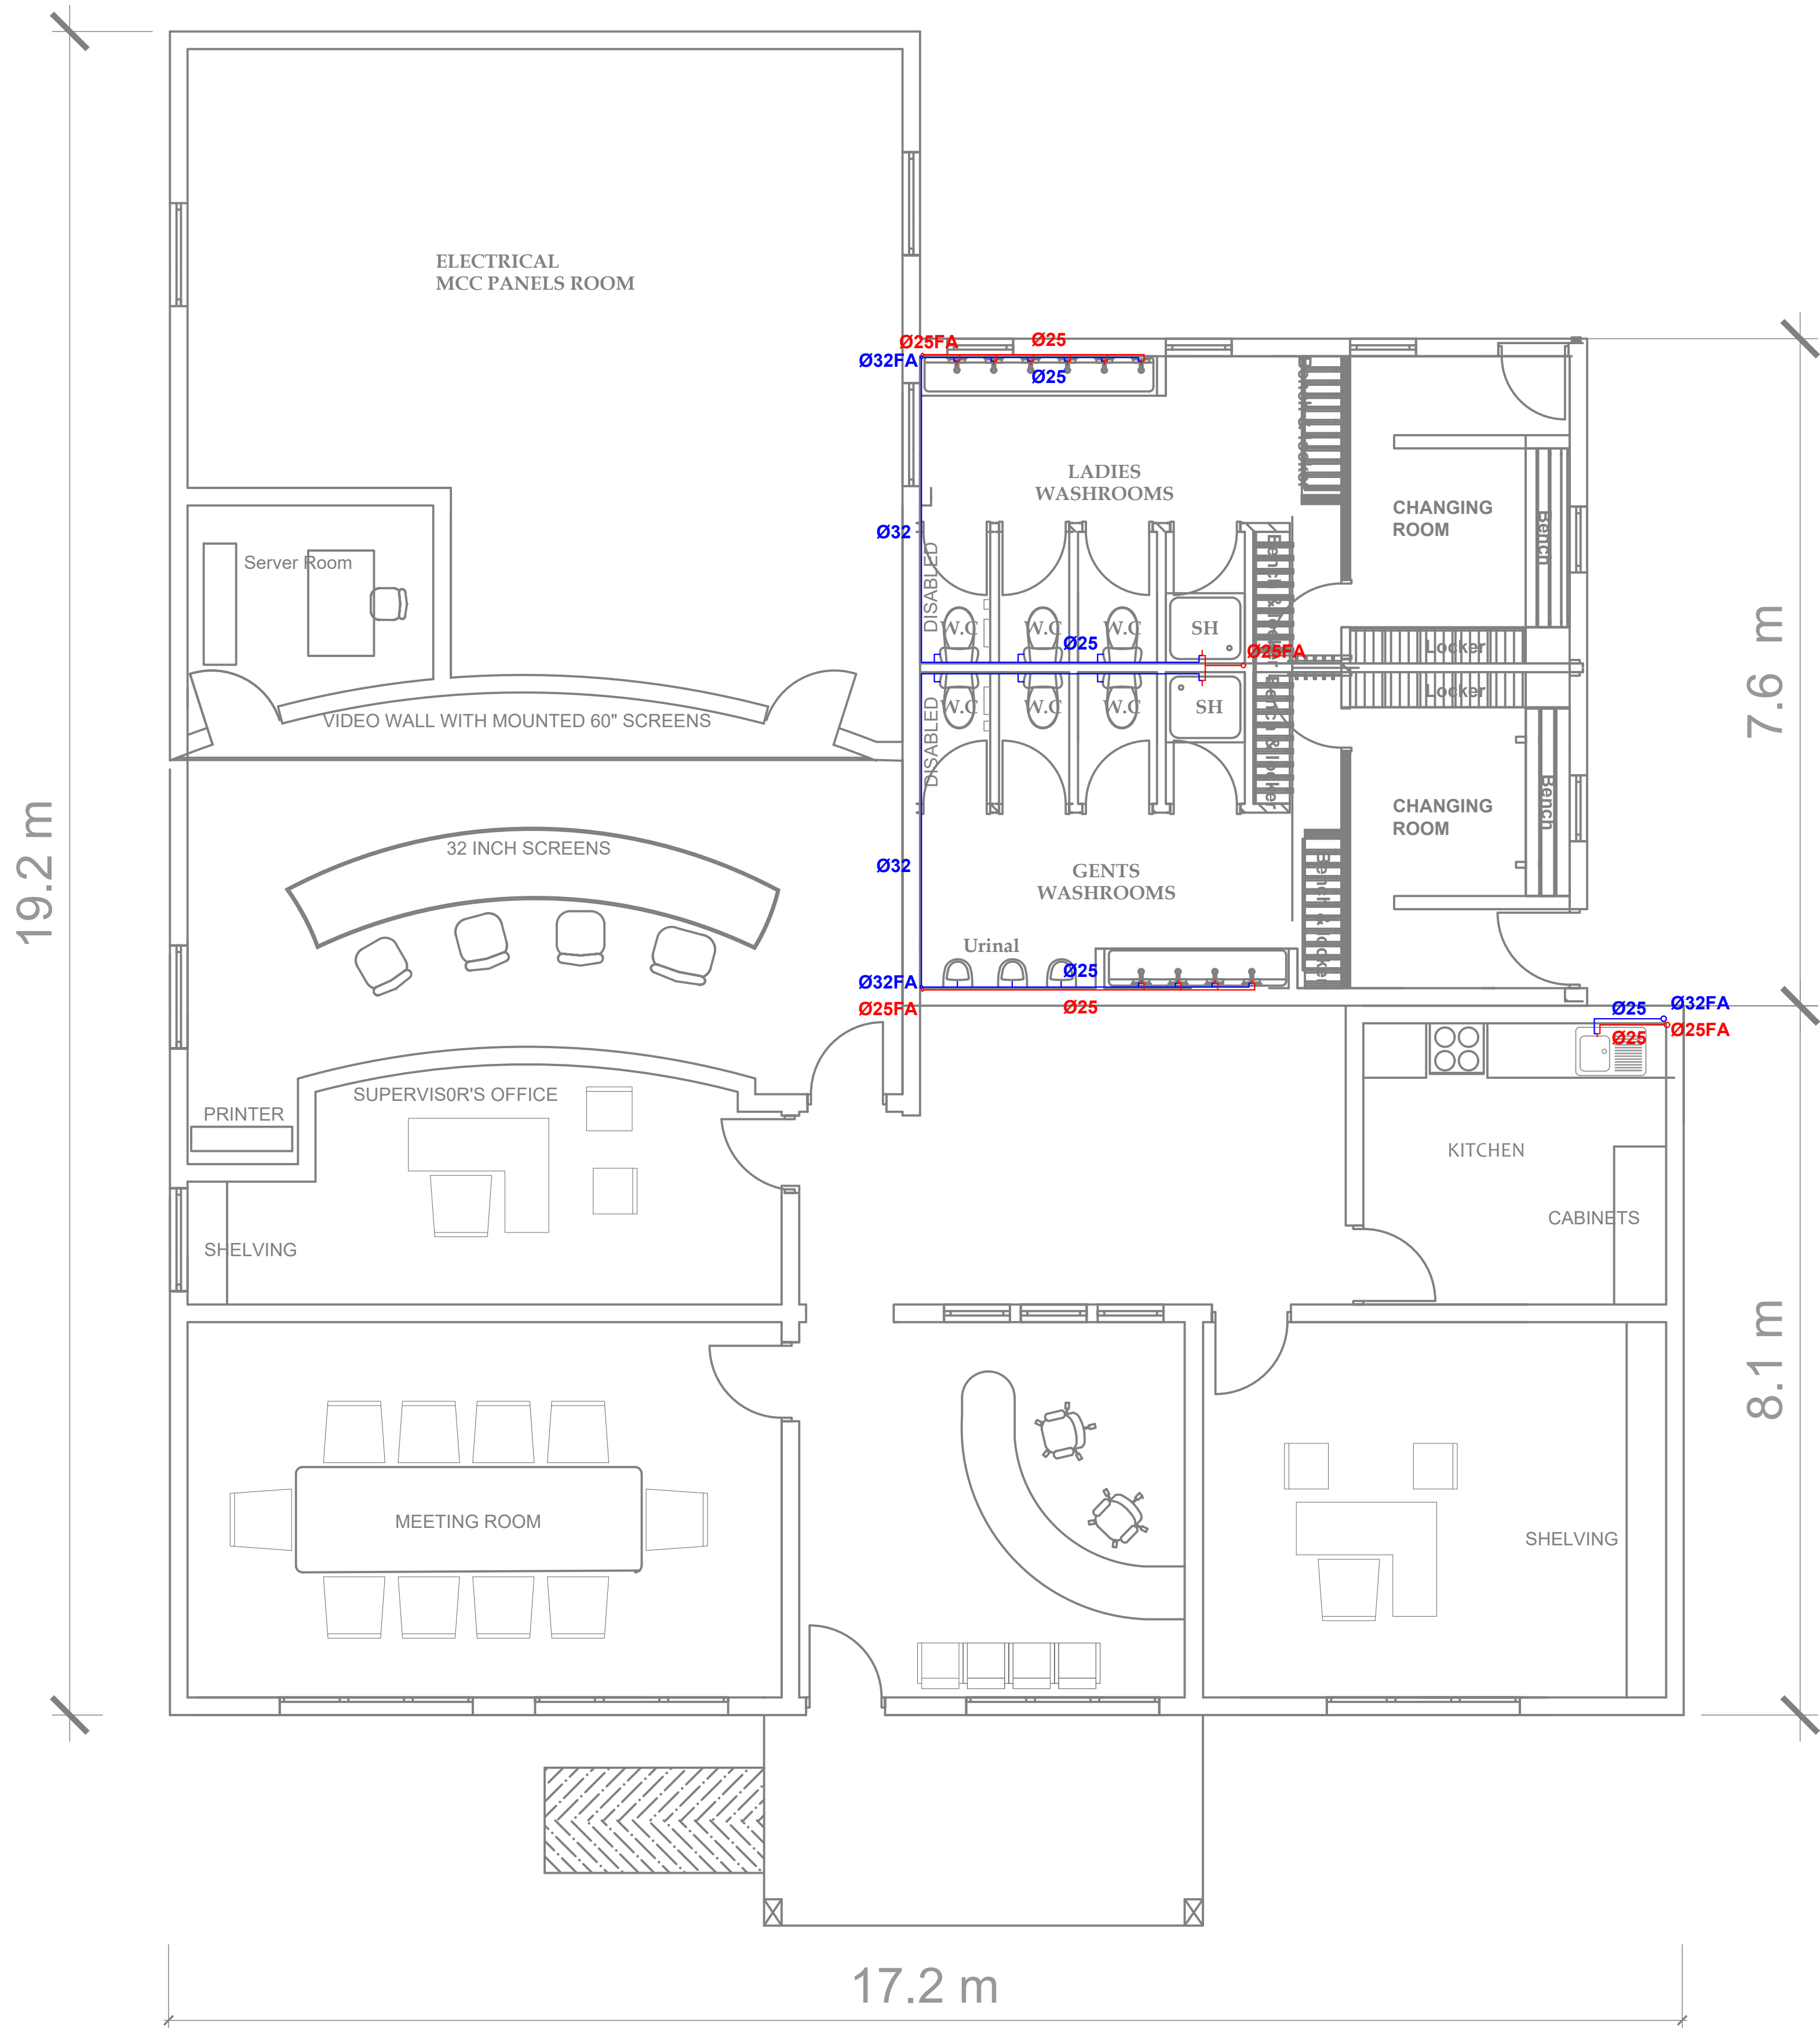

Civil Engineer:



Frame Consultants Ltd.
P.O. BOX 58624-00200, NAIROBI.
TEL: 2213744, 2251505, 0720523850
E-mail: info@frameconsultants.com

Client:



ATHI WATER WORK DEVELOPMENT AGENCY
P.O. BOX 45283 - 00100 NAIROBI,
Tel: +254 (0) 2742925
Email: info@awwda.go.ke

Project:
NAIROBI RIVERS BASIN REHABILITATION AND
RESTORATION PROGRAMME: SEWERAGE
IMPROVEMENT PROJECT PHASE II (NaRSIP II)
REHABILITATION AND EXPANSION OF DANDORA
ESTATE SEWERAGE TREATMENT PLANT (DESTP) INLET
WORKS

SERVICES ENGINEER:



Ditech Engineering Limited
Electro mechanical Turn-key engineers
P.O. BOX 231-00507, NAIROBI
Tel: +254 728162345
Email: design@ditech.co.ke


Drawing Title:


PROPOSED CONTROL ROOM PLUMBING LAYOUT

NOTES

1. DRAWING NOT TO SCALE
2. DRAWING TO BE READ IN CONJUNCTION WITH OTHER RELEVANT CIVIL STRUCTURE, ELECTRICAL AND MECHANICAL DRAWINGS
3. ALL DIMENSIONS AND LEVELS TO BE CHECKED ON SITE BEFORE COMMENCING ANY WORK. ANY DISCREPANCY TO BE REPORTED TO THE ENGINEER
4. ONLY FIGURED IMENSIONS TO BE TAKEN FROM THIS DRAWING

REV	R E V I S I O N S		SIGN	DATE	APPROVED	Designed by DON		Drawn by K.M	
	BY	CHECKED				Checked by	P.M	Approved by	DON
D		CHECKED				Scales		Date: SEPT 2021	
C		CHECKED				Job No.		ACAD File:CE108_PL_02	
B		CHECKED				P STATUS		DRG No. E01/40-16	
A		CHECKED						REV	

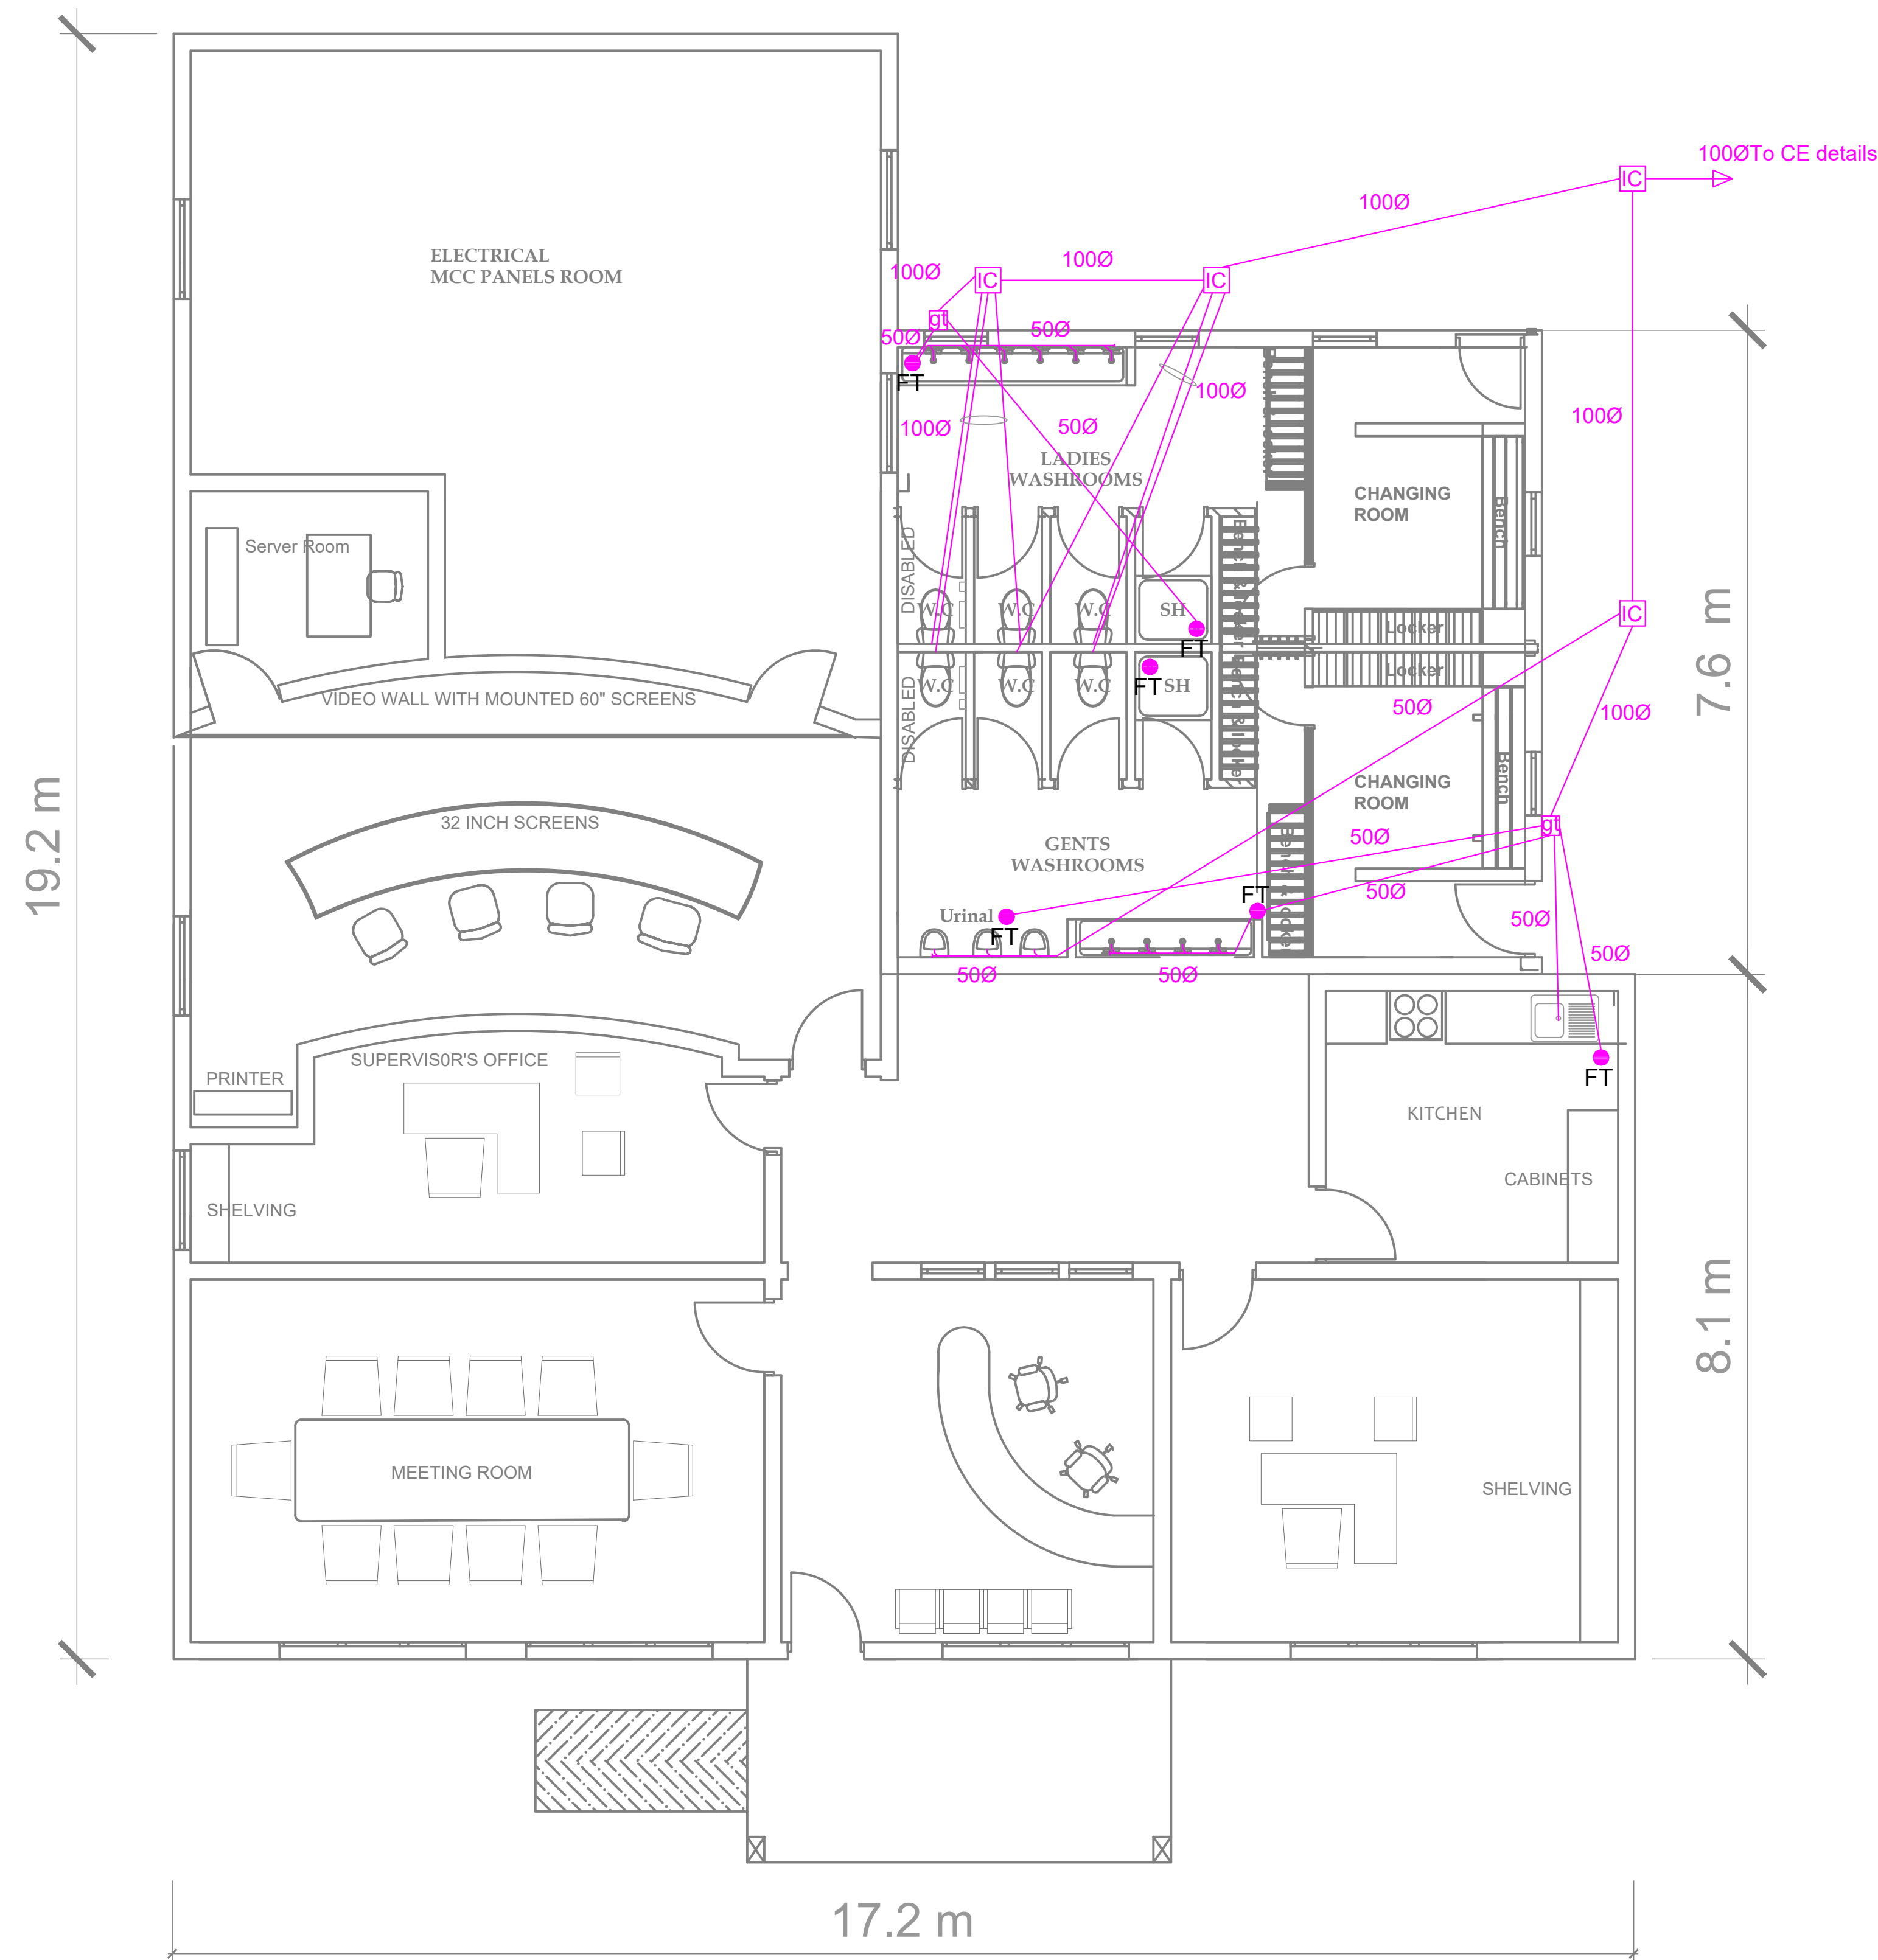

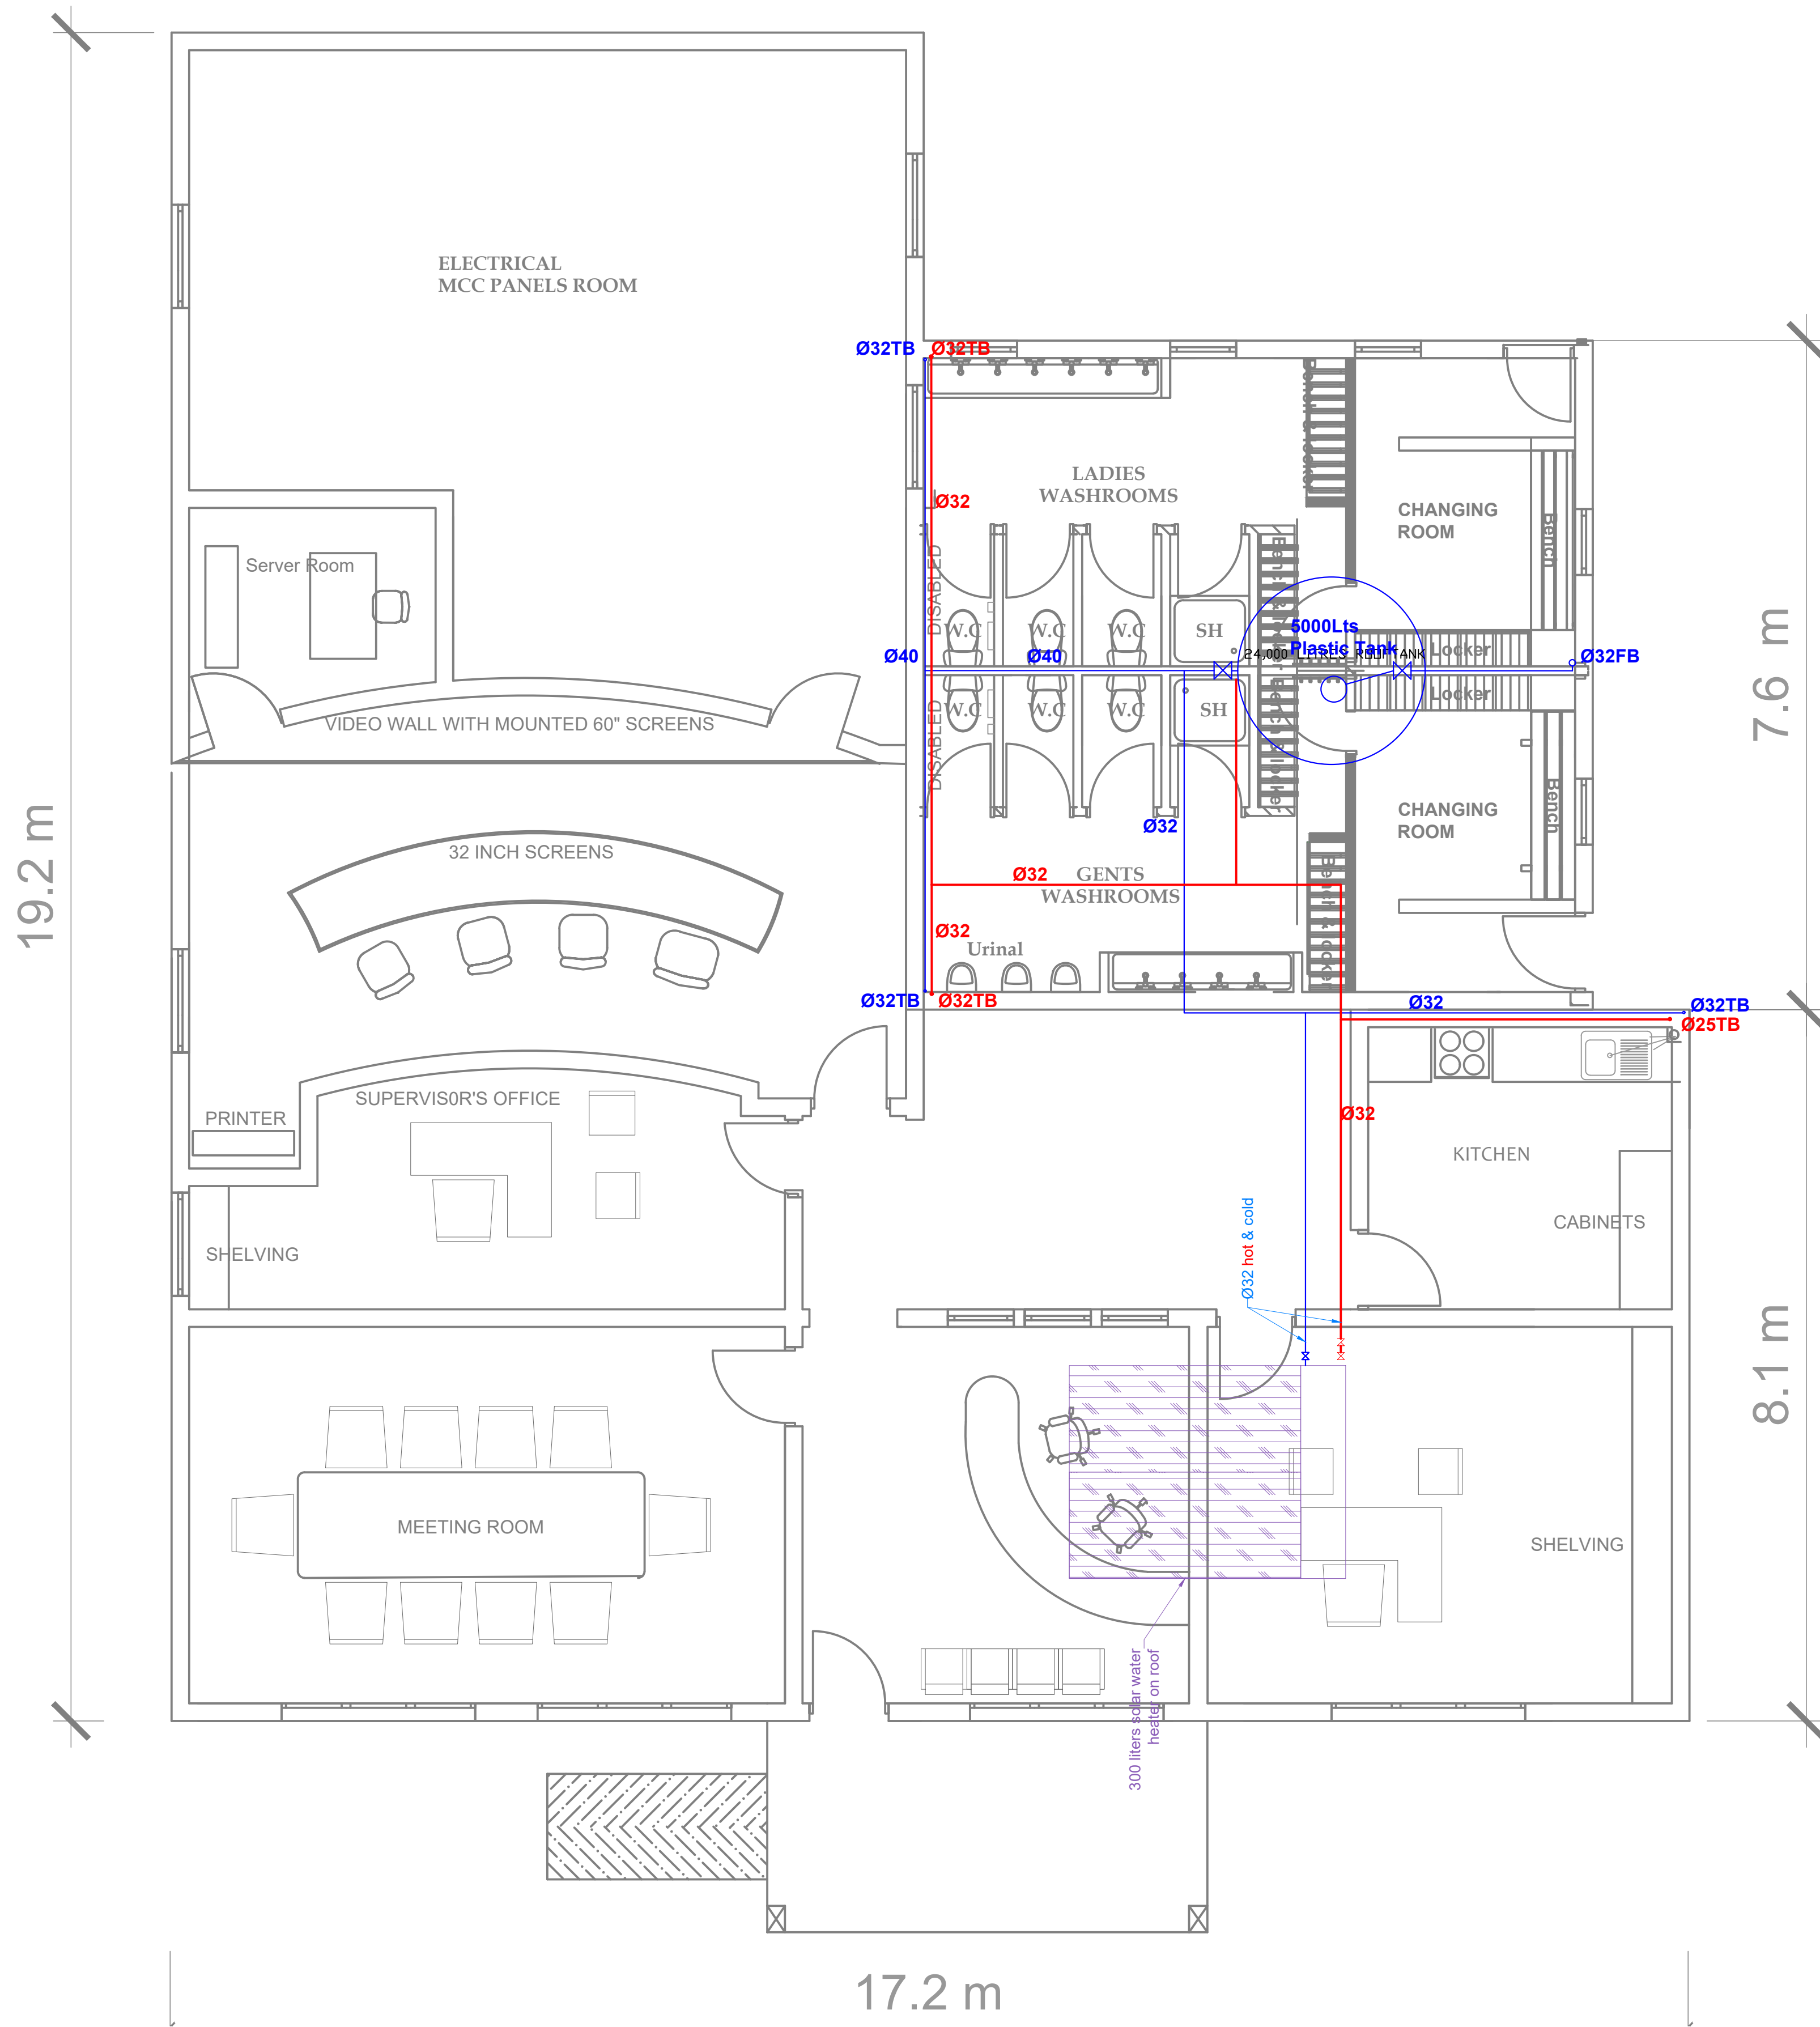

Civil Engineer:



Frame Consultants Ltd.
P.O. BOX 58624-00200, NAIROBI.
TEL: 2213744, 2251505, 0720523850
E-mail: info@frameconsultants.com

Client:



ATHI WATER WORK DEVELOPMENT AGENCY
P.O BOX 45283 - 00100 NAIROBI,
Tel: +254 (0) 274292/3
Email: info@awwda.go.ke

Project:
NAIROBI RIVERS BASIN REHABILITATION AND
RESTORATION PROGRAMME: SEWERAGE
IMPROVEMENT PROJECT PHASE II (NaRSIP II)
REHABILITATION AND EXPANSION OF DANDORA
ESTATE SEWERAGE TREATMENT PLANT (DESTP) INLET
WORKS

SERVICES ENGINEER:



Electro-mechanical Turn key engineers
P.O BOX 331-00507, NAIROBI
Tel: +254 728162245
Email: design@ditech.co.ke


Drawing Title:

PROPOSED CONTROL ROOM ROOF TOP PLAN
PLUMBING LAYOUT

NOTES

1. DRAWING NOT TO SCALE
2. DRAWING TO BE READ IN CONJUNCTION WITH OTHER RELEVANT CIVIL STRUCTURE, ELECTRICAL AND MECHANICAL DRAWINGS
3. ALL DIMENSIONS AND LEVELS TO BE CHECKED ON SITE BEFORE COMMENCING ANY WORK. ANY DISCREPANCY TO BE REPORTED TO THE ENGINEER
4. ONLY FIGURED IMENSIONS TO BE TAKEN FROM THIS DRAWING

REV	R E V I S I O N S				SIGN	DATE	APPROVED	Designed by DON		Drawn by K.M	
	BY	CHECKED	BY	CHECKED							
D								Checked by P.M	Approved by DON		
C								Scales NTS	Date: SEPT 2021		
B								Job No.		ACAD File:CE108_PL_02	
A								P STATUS	DRG No. E01/40-18		REV

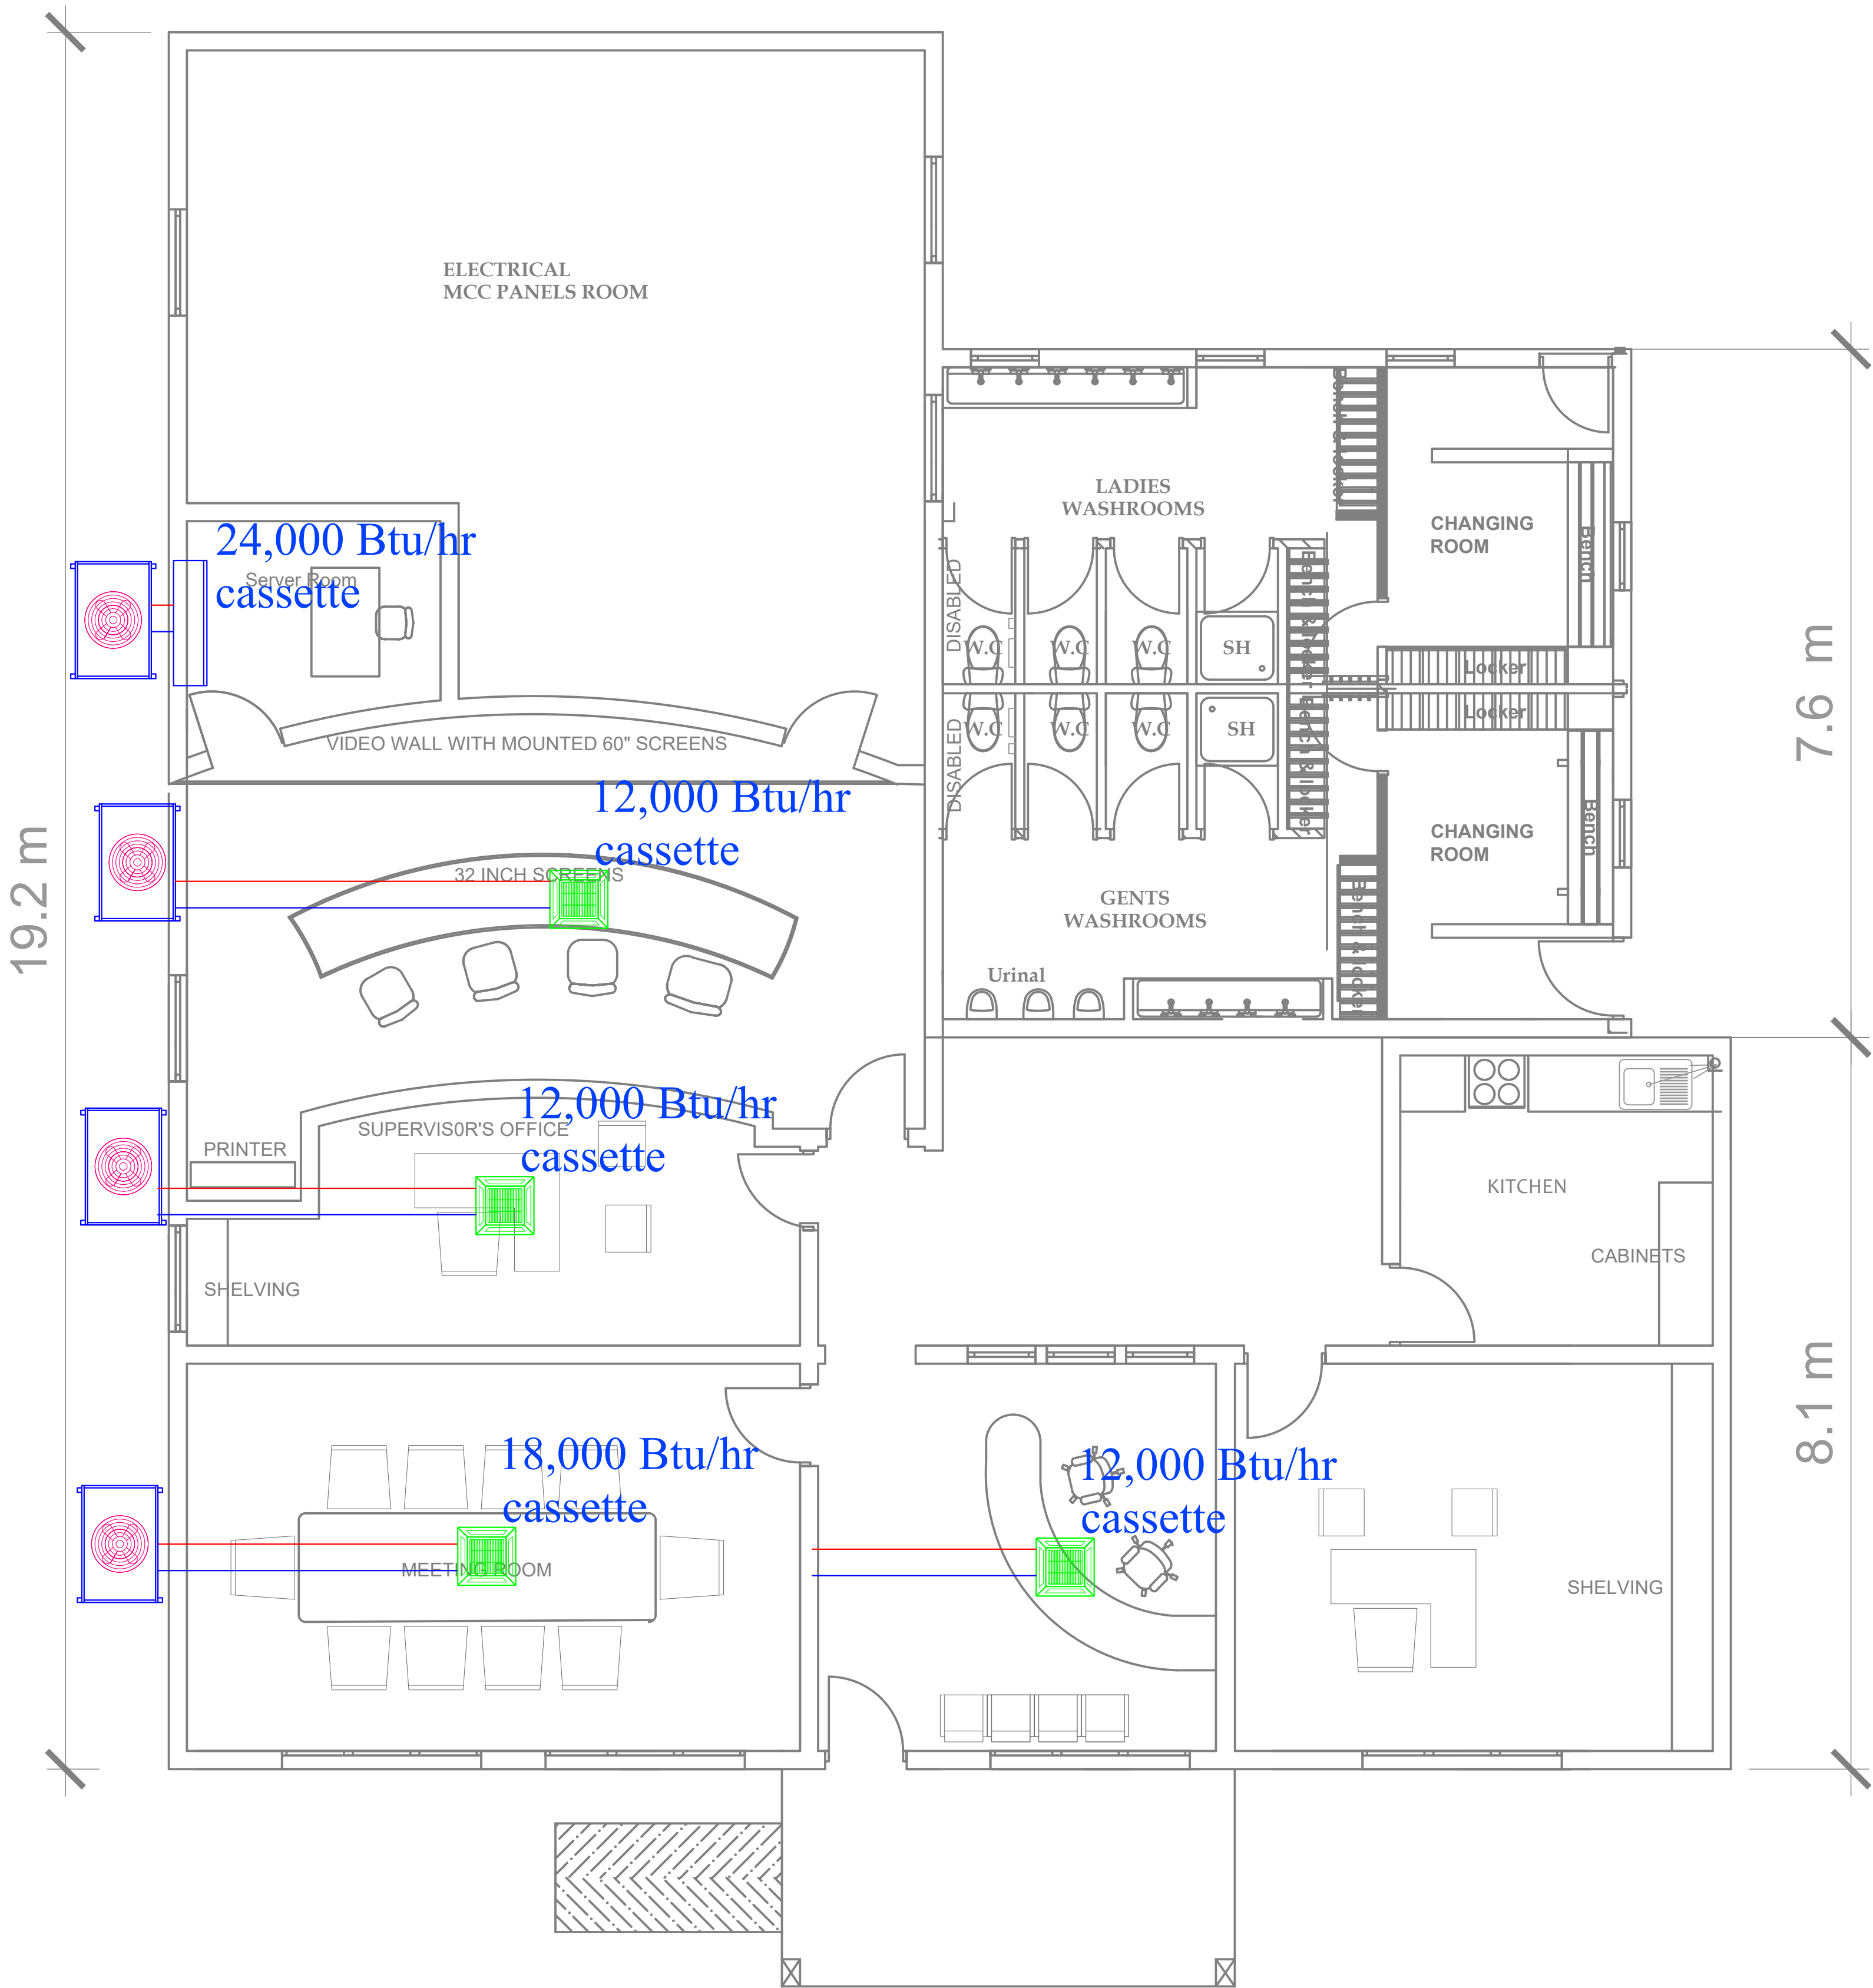

Civil Engineer:



Frame Consultants Ltd.
P.O. BOX 58624-00200, NAIROBI.
TEL: 2213744, 2251505, 0720523850
E-mail: info@frameconsultants.com


Client:



ATHI WATER WORK DEVELOPMENT AGENCY
P.O BOX 45383 - 00100 NAIROBI.
Tel: +254 (0) 2742923
Email: info@awwda.go.ke

Project:
NAIROBI RIVERS BASIN REHABILITATION AND
RESTORATION PROGRAMME: SEWERAGE
IMPROVEMENT PROJECT PHASE II (NaRSIP II)
REHABILITATION AND EXPANSION OF DANDORA
ESTATE SEWERAGE TREATMENT PLANT (DESTP) INLET
WORKS

SERVICES ENGINEER:

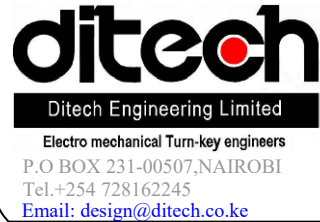


Drawing Title:


PROPOSED CONTROL ROOM AC LAYOUT

NOTES

1. DRAWING NOT TO SCALE
2. DRAWING TO BE READ IN CONJUNCTION WITH OTHER RELEVANT CIVIL STRUCTURE, ELECTRICAL AND MECHANICAL DRAWINGS
3. ALL DIMENSIONS AND LEVELS TO BE CHECKED ON SITE BEFORE COMMENCING ANY WORK. ANY DISCREPANCY TO BE REPORTED TO THE ENGINEER
4. ONLY FIGURED IMENSIONS TO BE TAKEN FROM THIS DRAWING

REV.	R E V I S I O N S				SIGN.	DATE	APPROVED	Designed by DON	Drawn by K.M
D		BY						Checked By: P.M	Approved by DON
		CHECKED							
		BY							
B		CHECKED						Scales NTS	Date: SEPT 2021
		BY						Job No.	ACAD File:CE108_PL_02
		CHECKED							
A		BY						P STATUS	DRG No. E01/40-19
		CHECKED							REV

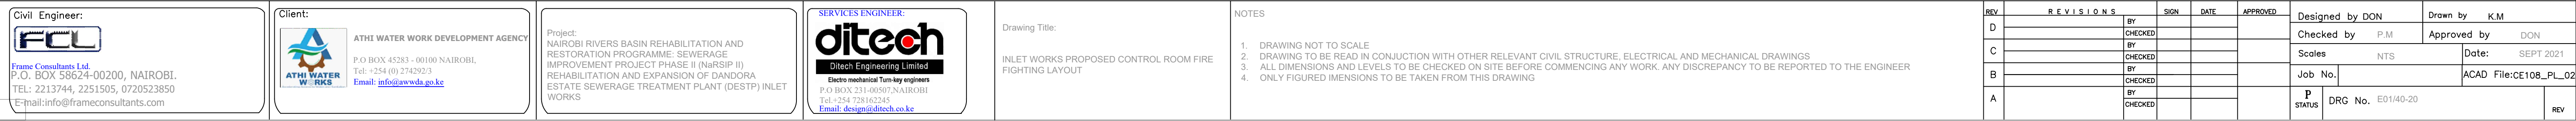

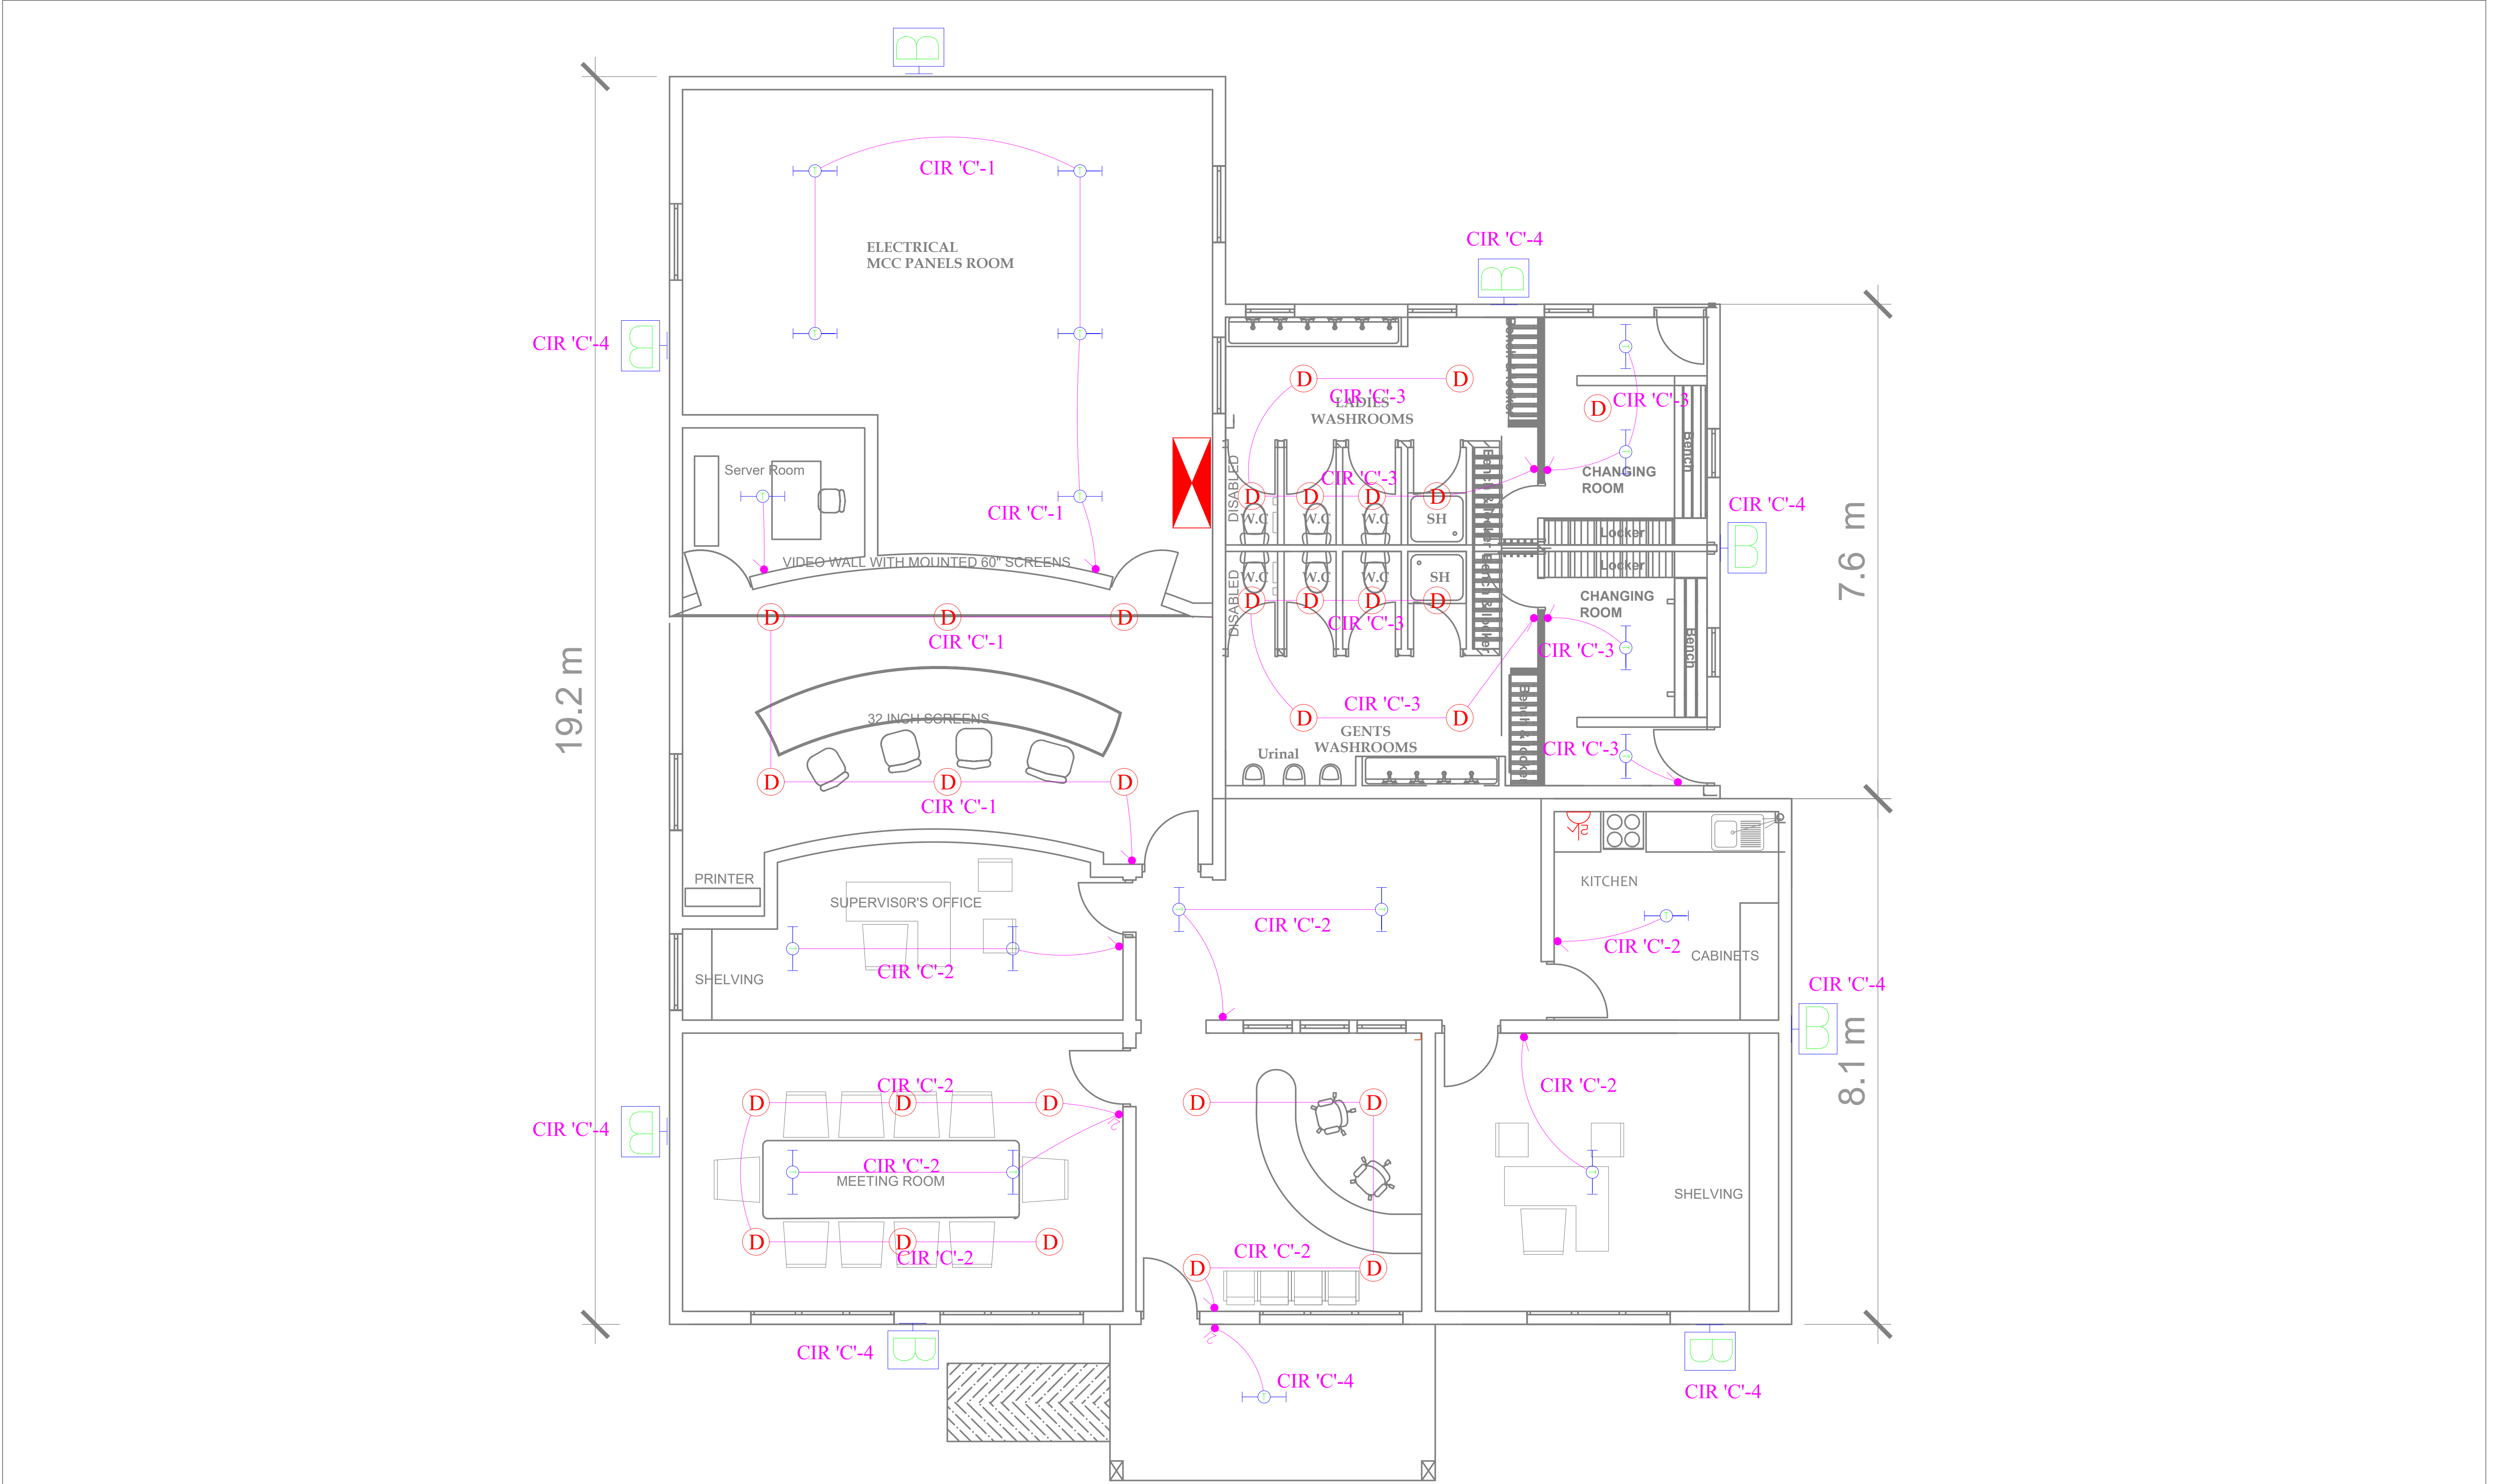

Civil Engineer:  Frame Consultants Ltd. P.O. BOX 58624-00200, NAIROBI. TEL: 2213744, 2251505, 0720523850 E-mail: info@frameconsultants.com		Client:  ATHI WATER WORK DEVELOPMENT AGENCY P.O BOX 45283 - 00100 NAIROBI, Tel: +254 (0) 2742923 Email: info@awwda.go.ke		Project: NAIROBI RIVERS BASIN REHABILITATION AND RESTORATION PROGRAMME: SEWERAGE IMPROVEMENT PROJECT PHASE II (NaRSIP II) REHABILITATION AND EXPANSION OF DANDORA ESTATE SEWERAGE TREATMENT PLANT (DESTP) INLET WORKS		SERVICES ENGINEER:  Ditech Engineering Limited Electro mechanical Turn-key engineers P.O BOX 231-00507, NAIROBI Tel: +254 728162345 Email: design@ditech.co.ke		Drawing Title: INLET WORKS PROPOSED CONTROL ROOM LIGHTING LAYOUT		NOTES 1. DRAWING NOT TO SCALE 2. DRAWING TO BE READ IN CONJUNCTION WITH OTHER RELEVANT CIVIL STRUCTURE, ELECTRICAL AND MECHANICAL DRAWINGS 3. ALL DIMENSIONS AND LEVELS TO BE CHECKED ON SITE BEFORE COMMENCING ANY WORK. ANY DISCREPANCY TO BE REPORTED TO THE ENGINEER 4. ONLY FIGURED DIMENSIONS TO BE TAKEN FROM THIS DRAWING		<table><tr><th>REV</th><th colspan="3">REVISIONS</th><th>SIGN</th><th>DATE</th><th>APPROVED</th></tr><tr><td>D</td><td></td><td>BY</td><td>CHECKED</td><td></td><td></td><td></td></tr><tr><td>C</td><td></td><td>BY</td><td>CHECKED</td><td></td><td></td><td></td></tr><tr><td>B</td><td></td><td>BY</td><td>CHECKED</td><td></td><td></td><td></td></tr><tr><td>A</td><td></td><td>BY</td><td>CHECKED</td><td></td><td></td><td></td></tr></table>		REV	REVISIONS			SIGN	DATE	APPROVED	D		BY	CHECKED				C		BY	CHECKED				B		BY	CHECKED				A		BY	CHECKED				<table><tr><td colspan="2">Designed by DON</td><td colspan="2">Drawn by E.M</td></tr><tr><td colspan="2">Checked by P.M</td><td colspan="2">Approved by DON</td></tr><tr><td colspan="2">Scales NTS</td><td colspan="2">Date: SEPT 2021</td></tr><tr><td>Job No.</td><td colspan="2">ACAD File:CE108_PL_02</td><td></td></tr><tr><td>P STATUS</td><td colspan="2">DRG No. E01/40-21</td><td>REV</td></tr></table>		Designed by DON		Drawn by E.M		Checked by P.M		Approved by DON		Scales NTS		Date: SEPT 2021		Job No.	ACAD File:CE108_PL_02			P STATUS	DRG No. E01/40-21		REV
REV	REVISIONS			SIGN	DATE	APPROVED																																																																
D		BY	CHECKED																																																																			
C		BY	CHECKED																																																																			
B		BY	CHECKED																																																																			
A		BY	CHECKED																																																																			
Designed by DON		Drawn by E.M																																																																				
Checked by P.M		Approved by DON																																																																				
Scales NTS		Date: SEPT 2021																																																																				
Job No.	ACAD File:CE108_PL_02																																																																					
P STATUS	DRG No. E01/40-21		REV																																																																			

Civil Engineer:  Frame Consultants Ltd. P.O. BOX 58624-00200, NAIROBI. TEL: 2213744, 2251505, 0720523850 Email: info@frameconsultants.com		Client:  ATHI WATER WORK DEVELOPMENT AGENCY P.O BOX 45283 - 00100 NAIROBI. Tel: +254 (0) 2129207 Email: info@awwda.go.ke		Project: ATHI RIVERS BASIN REHABILITATION AND RESTORATION PROGRAMME: SEWERAGE IMPROVEMENT PROJECT PHASE II (NARSIP II) REHABILITATION AND EXPANSION OF DANDORA ESTATE SEWERAGE TREATMENT PLANT (DESTP) INLET WORKS		SERVICES ENGINEER:  Ditech Engineering Limited Electro mechanical Turn-key engineers P.O BOX 231-00507, NAIROBI Tel: +254 238162345 Email: design@ditech.co.ke		Drawing Title: INLET WORKS PROPOSED CONTROL ROOM ELECTRICAL POWER LAYOUT		NOTES 1. DRAWING NOT TO SCALE 2. DRAWINGS TO BE MADE IN CONJUNCTION WITH OTHER RELEVANT CIVIL, STRUCTURE, ELECTRICAL AND MECHANICAL DRAWINGS 3. ALL DIMENSIONS AND LEVELS TO BE CHECKED ON SITE BEFORE COMMENCING ANY WORK. ANY DISCREPANCY TO BE REPORTED TO THE ENGINEER 4. ONLY FIGURED DIMENSIONS TO BE TAKEN FROM THIS DRAWING		<table><tr><th>REV.</th><th colspan="2">REVISIONS</th><th>SIGN</th><th>DATE</th><th>APPROVED</th></tr><tr><td>D</td><td>BY</td><td></td><td></td><td></td><td></td></tr><tr><td>C</td><td>CHECKED</td><td></td><td></td><td></td><td></td></tr><tr><td></td><td>BY</td><td></td><td></td><td></td><td></td></tr><tr><td></td><td>CHECKED</td><td></td><td></td><td></td><td></td></tr><tr><td>B</td><td>BY</td><td></td><td></td><td></td><td></td></tr><tr><td></td><td>CHECKED</td><td></td><td></td><td></td><td></td></tr><tr><td></td><td>BY</td><td></td><td></td><td></td><td></td></tr><tr><td>A</td><td>CHECKED</td><td></td><td></td><td></td><td></td></tr></table>		REV.	REVISIONS		SIGN	DATE	APPROVED	D	BY					C	CHECKED						BY						CHECKED					B	BY						CHECKED						BY					A	CHECKED					<table><tr><th colspan="2">DESIGNED BY DON</th><th colspan="2">DRAWN BY E.M</th></tr><tr><td>CHECKED BY</td><td>P.M</td><td>APPROVED BY</td><td>DON</td></tr><tr><td colspan="2">Scales NTS</td><td colspan="2">Date: SEPT 2021</td></tr><tr><td>JOB NO.</td><td></td><td>ACAD FILE:</td><td>CE108_PL_002</td></tr><tr><td>P STATUS</td><td>DRG No. E01/40-22</td><td colspan="2">REV</td></tr></table>		DESIGNED BY DON		DRAWN BY E.M		CHECKED BY	P.M	APPROVED BY	DON	Scales NTS		Date: SEPT 2021		JOB NO.		ACAD FILE:	CE108_PL_002	P STATUS	DRG No. E01/40-22	REV	
REV.	REVISIONS		SIGN	DATE	APPROVED																																																																																				
D	BY																																																																																								
C	CHECKED																																																																																								
	BY																																																																																								
	CHECKED																																																																																								
B	BY																																																																																								
	CHECKED																																																																																								
	BY																																																																																								
A	CHECKED																																																																																								
DESIGNED BY DON		DRAWN BY E.M																																																																																							
CHECKED BY	P.M	APPROVED BY	DON																																																																																						
Scales NTS		Date: SEPT 2021																																																																																							
JOB NO.		ACAD FILE:	CE108_PL_002																																																																																						
P STATUS	DRG No. E01/40-22	REV																																																																																							